

34"

34"

22"

22"

17"

17"

11"

11"

8.5"

8.5"

8.5"

8.5"

11"

11"

17"


17"

22"

22"

34"

34"

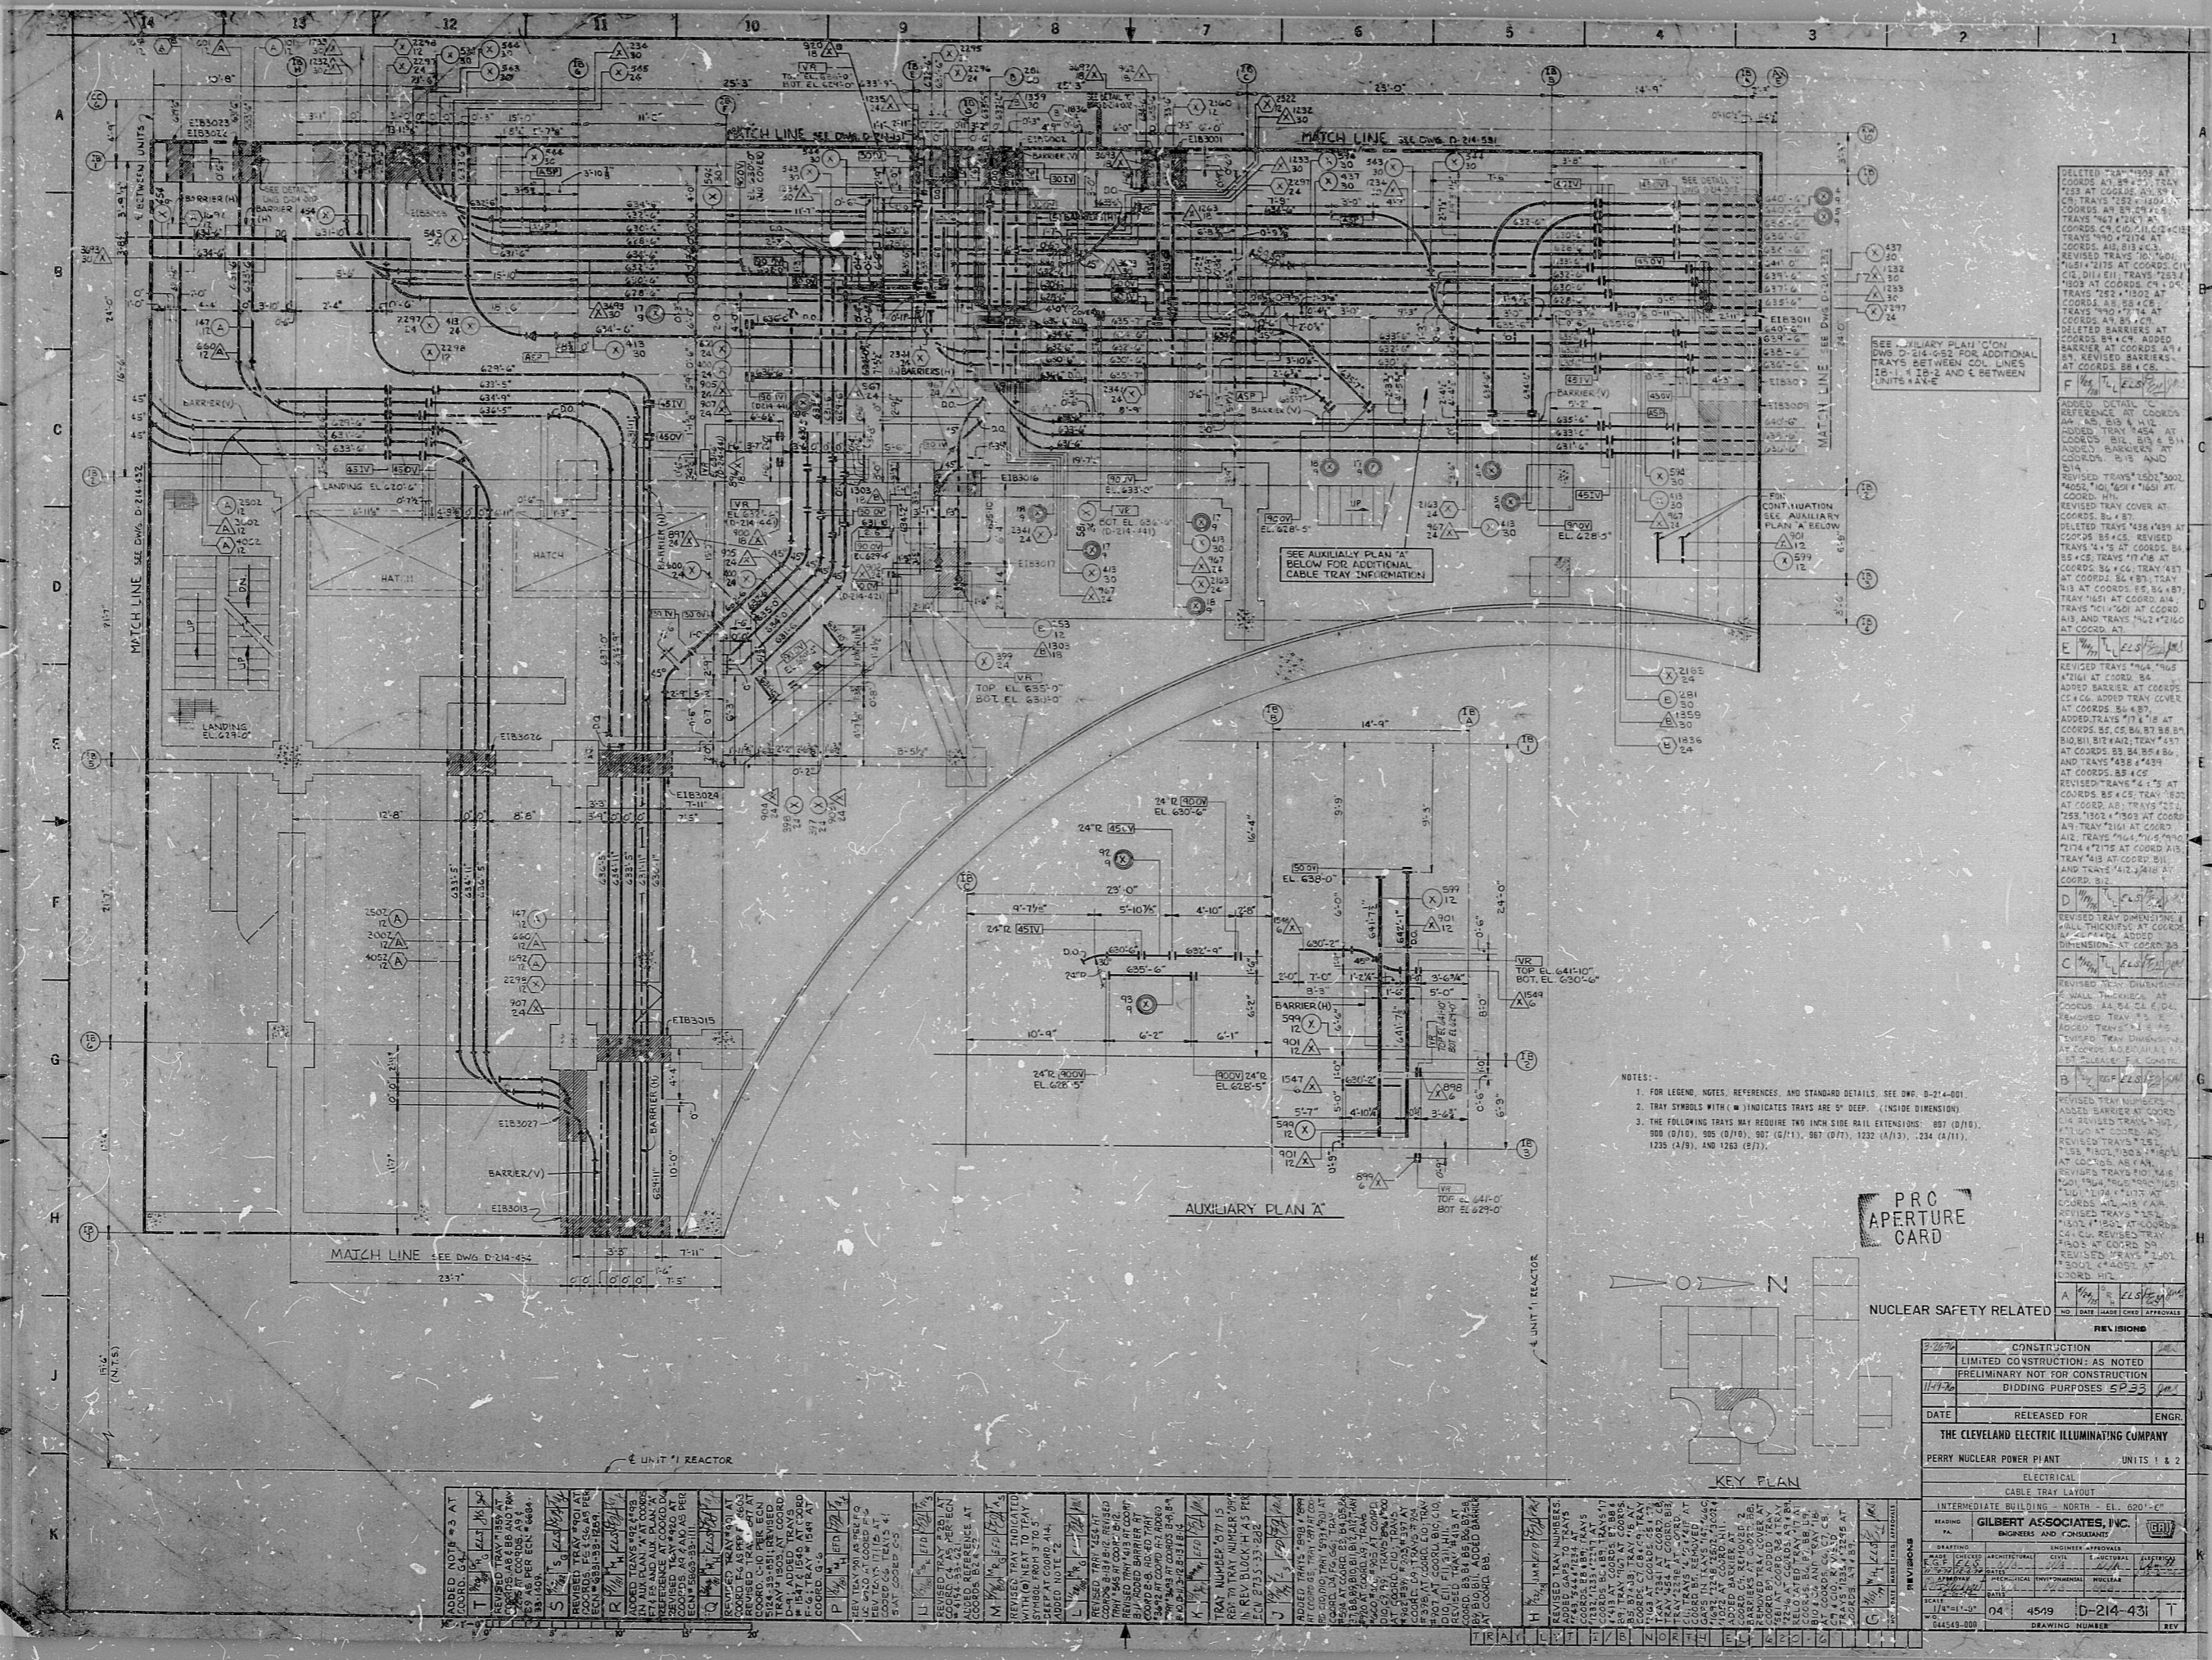


SEE AUXILIARY PLAN 'C' ON DWG D-214-052 FOR ADDITIONAL TRAYS BETWEEN COL. LINES 12-1, 12-2 AND C BETWEEN UNITS 1 & 2

SEE AUXILIARY PLAN 'A' BELOW FOR ADDITIONAL CABLE TRAY INFORMATION

PRC APERTURE CARD

NUCLEAR SAFETY RELATED

- NOTES -
1. FOR LEGEND, NOTES, REFERENCES AND STANDARD DETAILS, SEE DWG. D-214-001
 2. TRAY SYMBOLS WITH (M) INDICATES TRAYS ARE 6" DEEP. (INSIDE DIMENSION)
 3. THE FOLLOWING TRAYS MAY REQUIRE TWO INCH SIDE RAIL EXTENSIONS: 907 (D/1), 900 (D/1), 905 (D/1), 907 (D/1), 967 (D/1), 1232 (A/1), 234 (A/1), 1235 (A/8), AND 1263 (B/7).

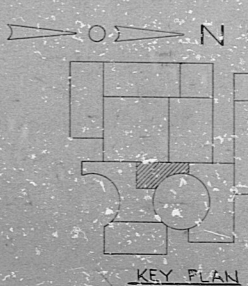

NO.	REVISIONS	DATE	BY	CHKD.	APP'D.
1	ISSUED FOR CONSTRUCTION	11/7/76	[Signature]	[Signature]	[Signature]
2	REVISIONS				
3					
4					
5					
100					

CONSTRUCTION	
LIMITED CONSTRUCTION: AS NOTED	
PRELIMINARY NOT FOR CONSTRUCTION	
DIDDING PURPOSES SP33	
DATE	RELEASED FOR ENGR.
THE CLEVELAND ELECTRIC ILLUMINATING COMPANY	
PERRY NUCLEAR POWER PLANT UNITS 1 & 2	
ELECTRICAL	
CABLE TRAY LAYOUT	
INTERMEDIATE BUILDING - NORTH - EL. 690'-0"	
DRAWING NO. 04 4599 D-214-431 T	
DESIGNED AND CONSULTANT: GILBERT ASSOCIATES, INC.	
DRAWING NUMBER	

82.1208 0344

RIDS

