

108

108

11

11

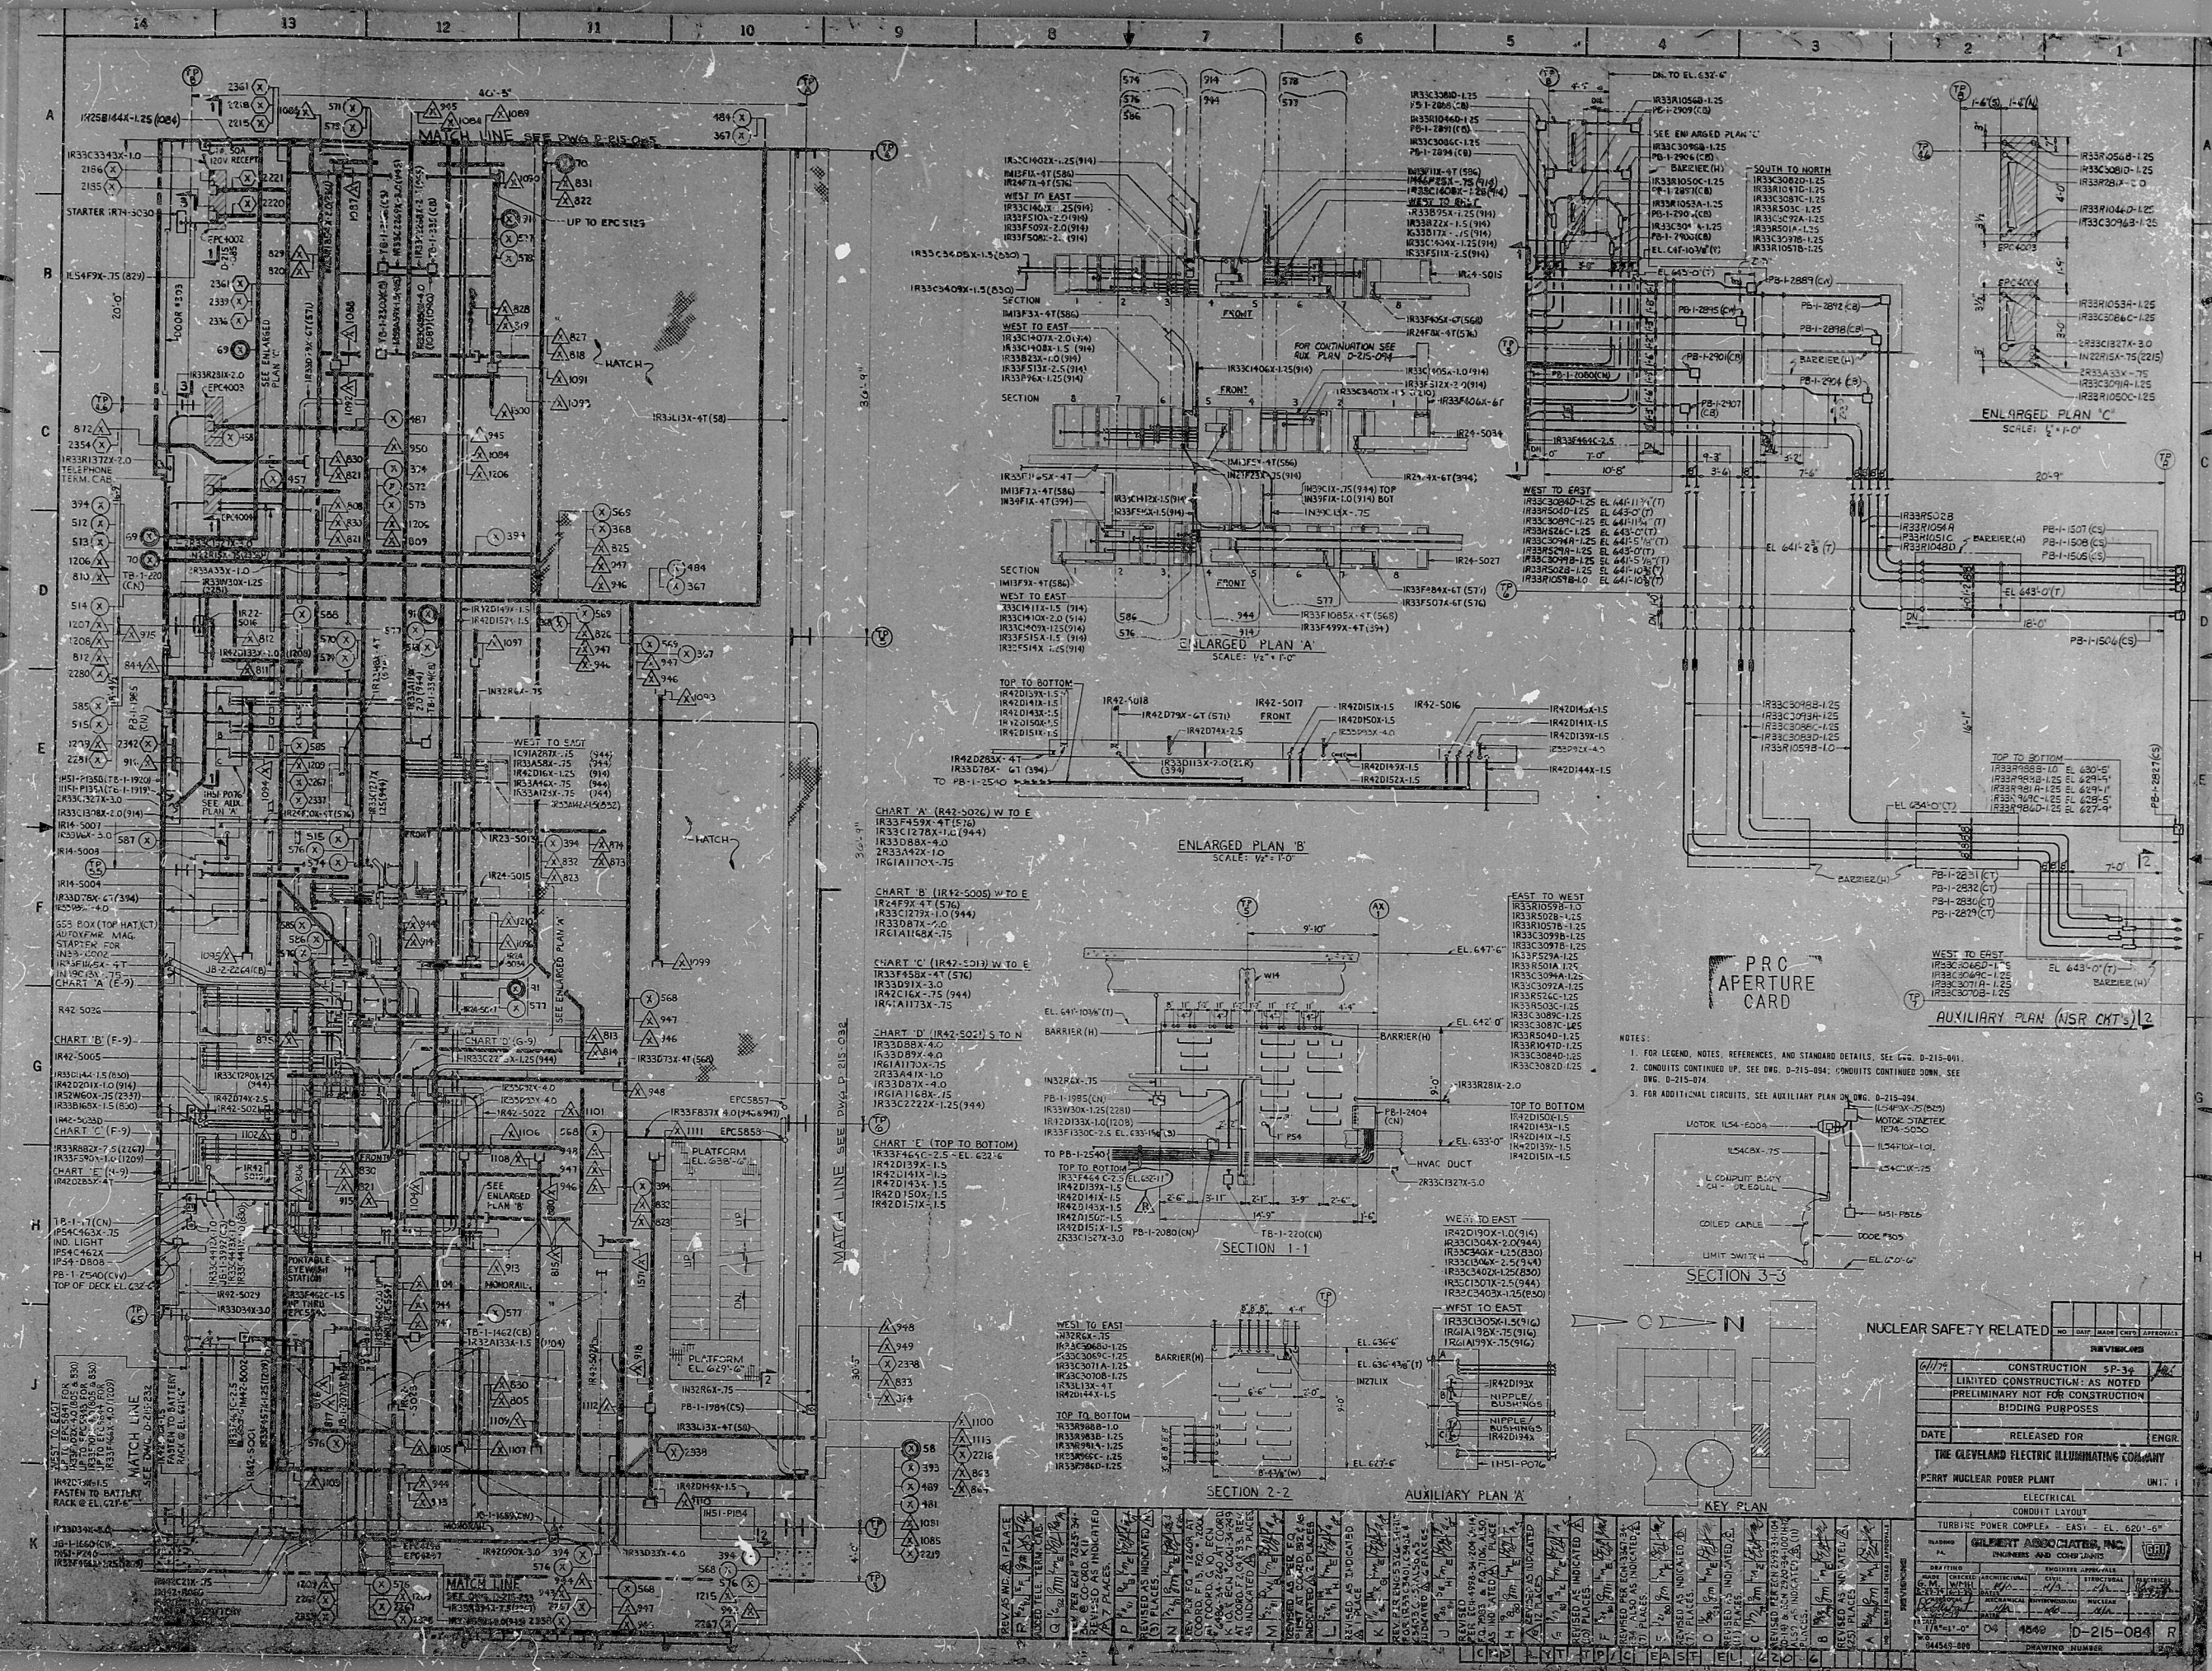


CHART 'A' (R41-5026) W TO E  
 IR33F459X-4T(576)  
 IR33C1278X-1.0(944)  
 IR33D88X-4.0  
 IR33A49X-1.0  
 IR33A1170X-7.5

CHART 'B' (IR42-5005) W TO E  
 IR42F49X-4T(576)  
 IR33C1278X-1.0(944)  
 IR33D88X-4.0  
 IR33A49X-1.0  
 IR42A1173X-7.5



CHART 'C' (IR42-5013) W TO E  
 IR33F459X-4T(576)  
 IR33D88X-4.0  
 IR42C16X-7.5(944)  
 IR42A1173X-7.5

CHART 'D' (IR42-5021) S TO N  
 IR33D88X-4.0  
 IR33D89X-4.0  
 IR33A1170X-7.5  
 IR33A49X-1.0  
 IR33D87X-4.0  
 IR33C222X-1.25(944)

CHART 'E' (TOP TO BOTTOM)  
 IR33F459X-4T(576)  
 IR42D139X-1.5  
 IR33D88X-4.0  
 IR42D139X-1.5  
 IR42D143X-1.5  
 IR42D150X-1.5  
 IR42D151X-1.5

PRC APERTURE CARD

- NOTES:
1. FOR LEGEND, NOTES, REFERENCES, AND STANDARD DETAILS, SEE DWG. D-215-011.
  2. CONDUITS CONTINUED UP, SEE DWG. D-215-004; CONDUITS CONTINUED DOWN, SEE DWG. D-215-074.
  3. FOR ADDITIONAL CIRCUITS, SEE AUXILIARY PLAN ON DWG. D-215-004.

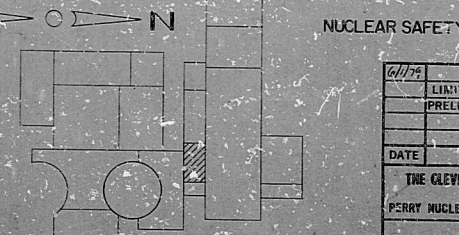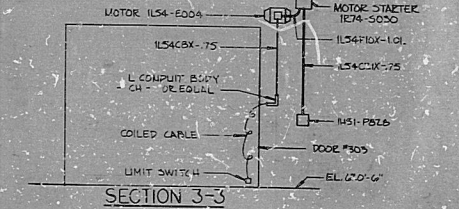

NUCLEAR SAFETY RELATED		NO	DATE	REASON	APPROVALS
CONSTRUCTION	SP-34				
LIMITED CONSTRUCTION	AS NOTED				
PRELIMINARY NOT FOR CONSTRUCTION	BIDDING PURPOSES				
DATE	RELEASED FOR				
THE CLEVELAND ELECTRIC ILLUMINATING COMPANY					
PERRY NUCLEAR POWER PLANT					
ELECTRICAL					
CONDUIT LAYOUT					
TURBINE POWER COMPLEX - EAST - EL. 620'-6"					
DRAWN BY: GILBERT ASSOCIATES, INC.					
CHECKED BY: GILBERT ASSOCIATES, INC.					
APPROVED BY: GILBERT ASSOCIATES, INC.					
DATE: 1/18/60					
DRAWING NUMBER: D-215-084 R					

REV	DATE	BY	DESCRIPTION
1	1/18/60	...	...
2	...	...	...
3	...	...	...
4	...	...	...
100	...	...	...



8212080571

Rids

