
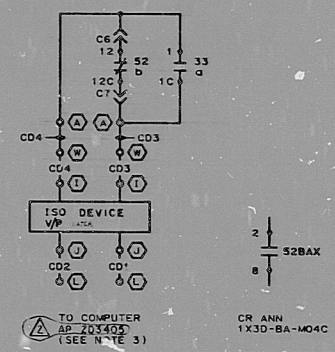
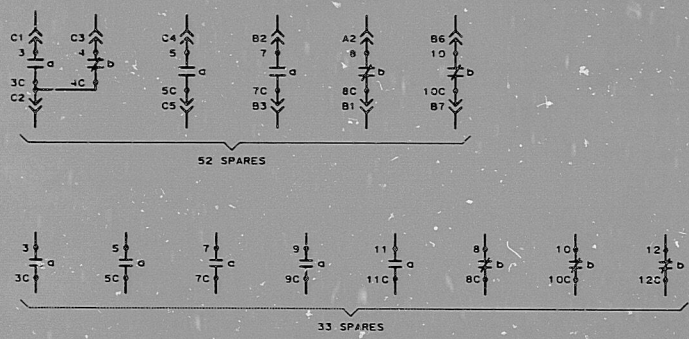
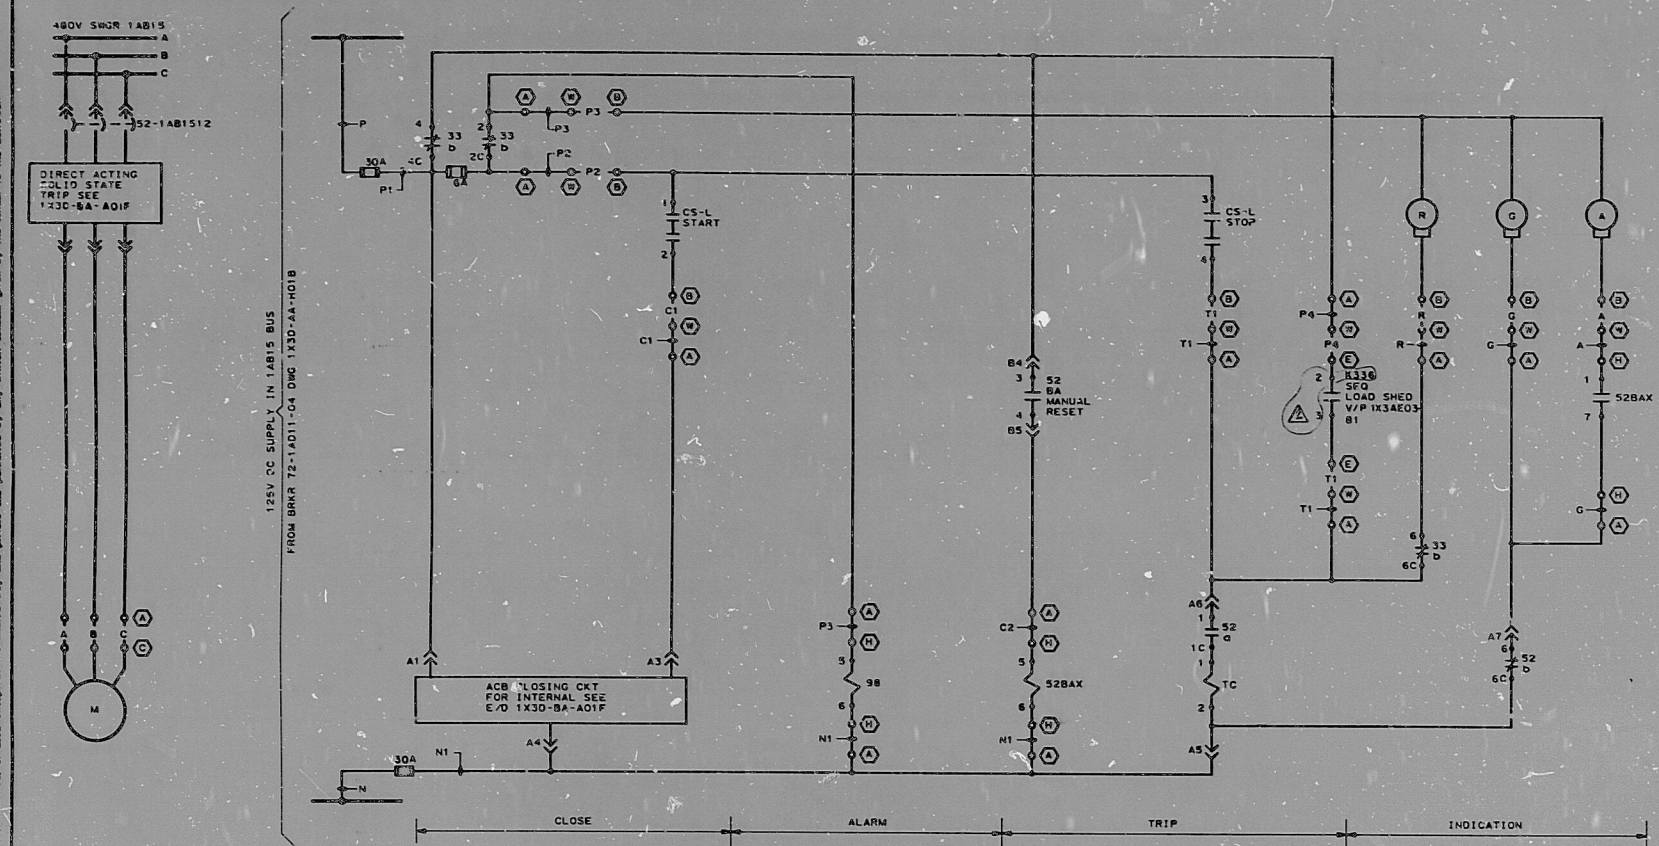


DEVICE	MFR	TYPE	MODEL NO	NUMBER	DESCRIPTION	REV
98	GE	HMA	12MAT1B6	1X4DB130	P.O. 1 DIAGRAM	
52BAX	GE	HMA	12MAT1B6	1X30-AA-E16A	ONE LINE DIAGRAM	
				1/2X6AND3-3	LOGIC DIAGRAM	
					BECHTEL V/P	

REVISIONS	DATE	DR	CHK	SUPV	EQS	CHK	P.E.	N.A.E.	NO.
1									
2									
3									
4									
5									
6									
7									

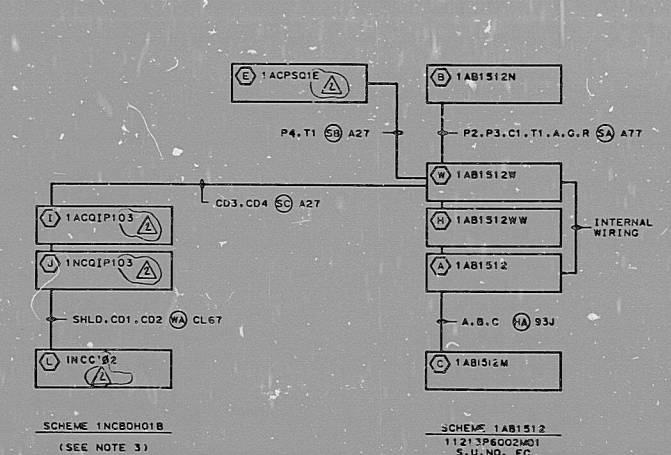

PRC APERTURE CARD

NUCLEAR SAFETY RELATED

SPENT FUEL PIT PUMP MOTOR

BECHTEL
LOS ANGELES

GEORGIA POWER COMPANY
ALVIN W. VOGTLE NUCLEAR PLANT

ELEMENTARY DIAGRAM
SPENT FUEL COOLING & PURIFICATION SYSTEM
1-1213-P8-002-M01

SCALE: NONE

DRAWING NO. 1X30-B0-M01B

REV. 2

This drawing and the design it contains are the property of BECHTEL. They are hereby loaned and used on the borrower's express agreement that they will not be reproduced, copied, loaned, sold, or otherwise disposed of in any manner without the prior written consent given by the lender to the borrower.

I CERTIFY THAT THE ABOVE CABLES ARE ON THIS FRAME WAS MADE IN THE NORMAL AND STANDARD COURSE OF BUSINESS ON THE DATE STATED ABOVE AND THAT IT IS THE PROPERTY OF BECHTEL AND IS LOANED TO THE BORROWER.

RIDS

8310030208

