


34


34

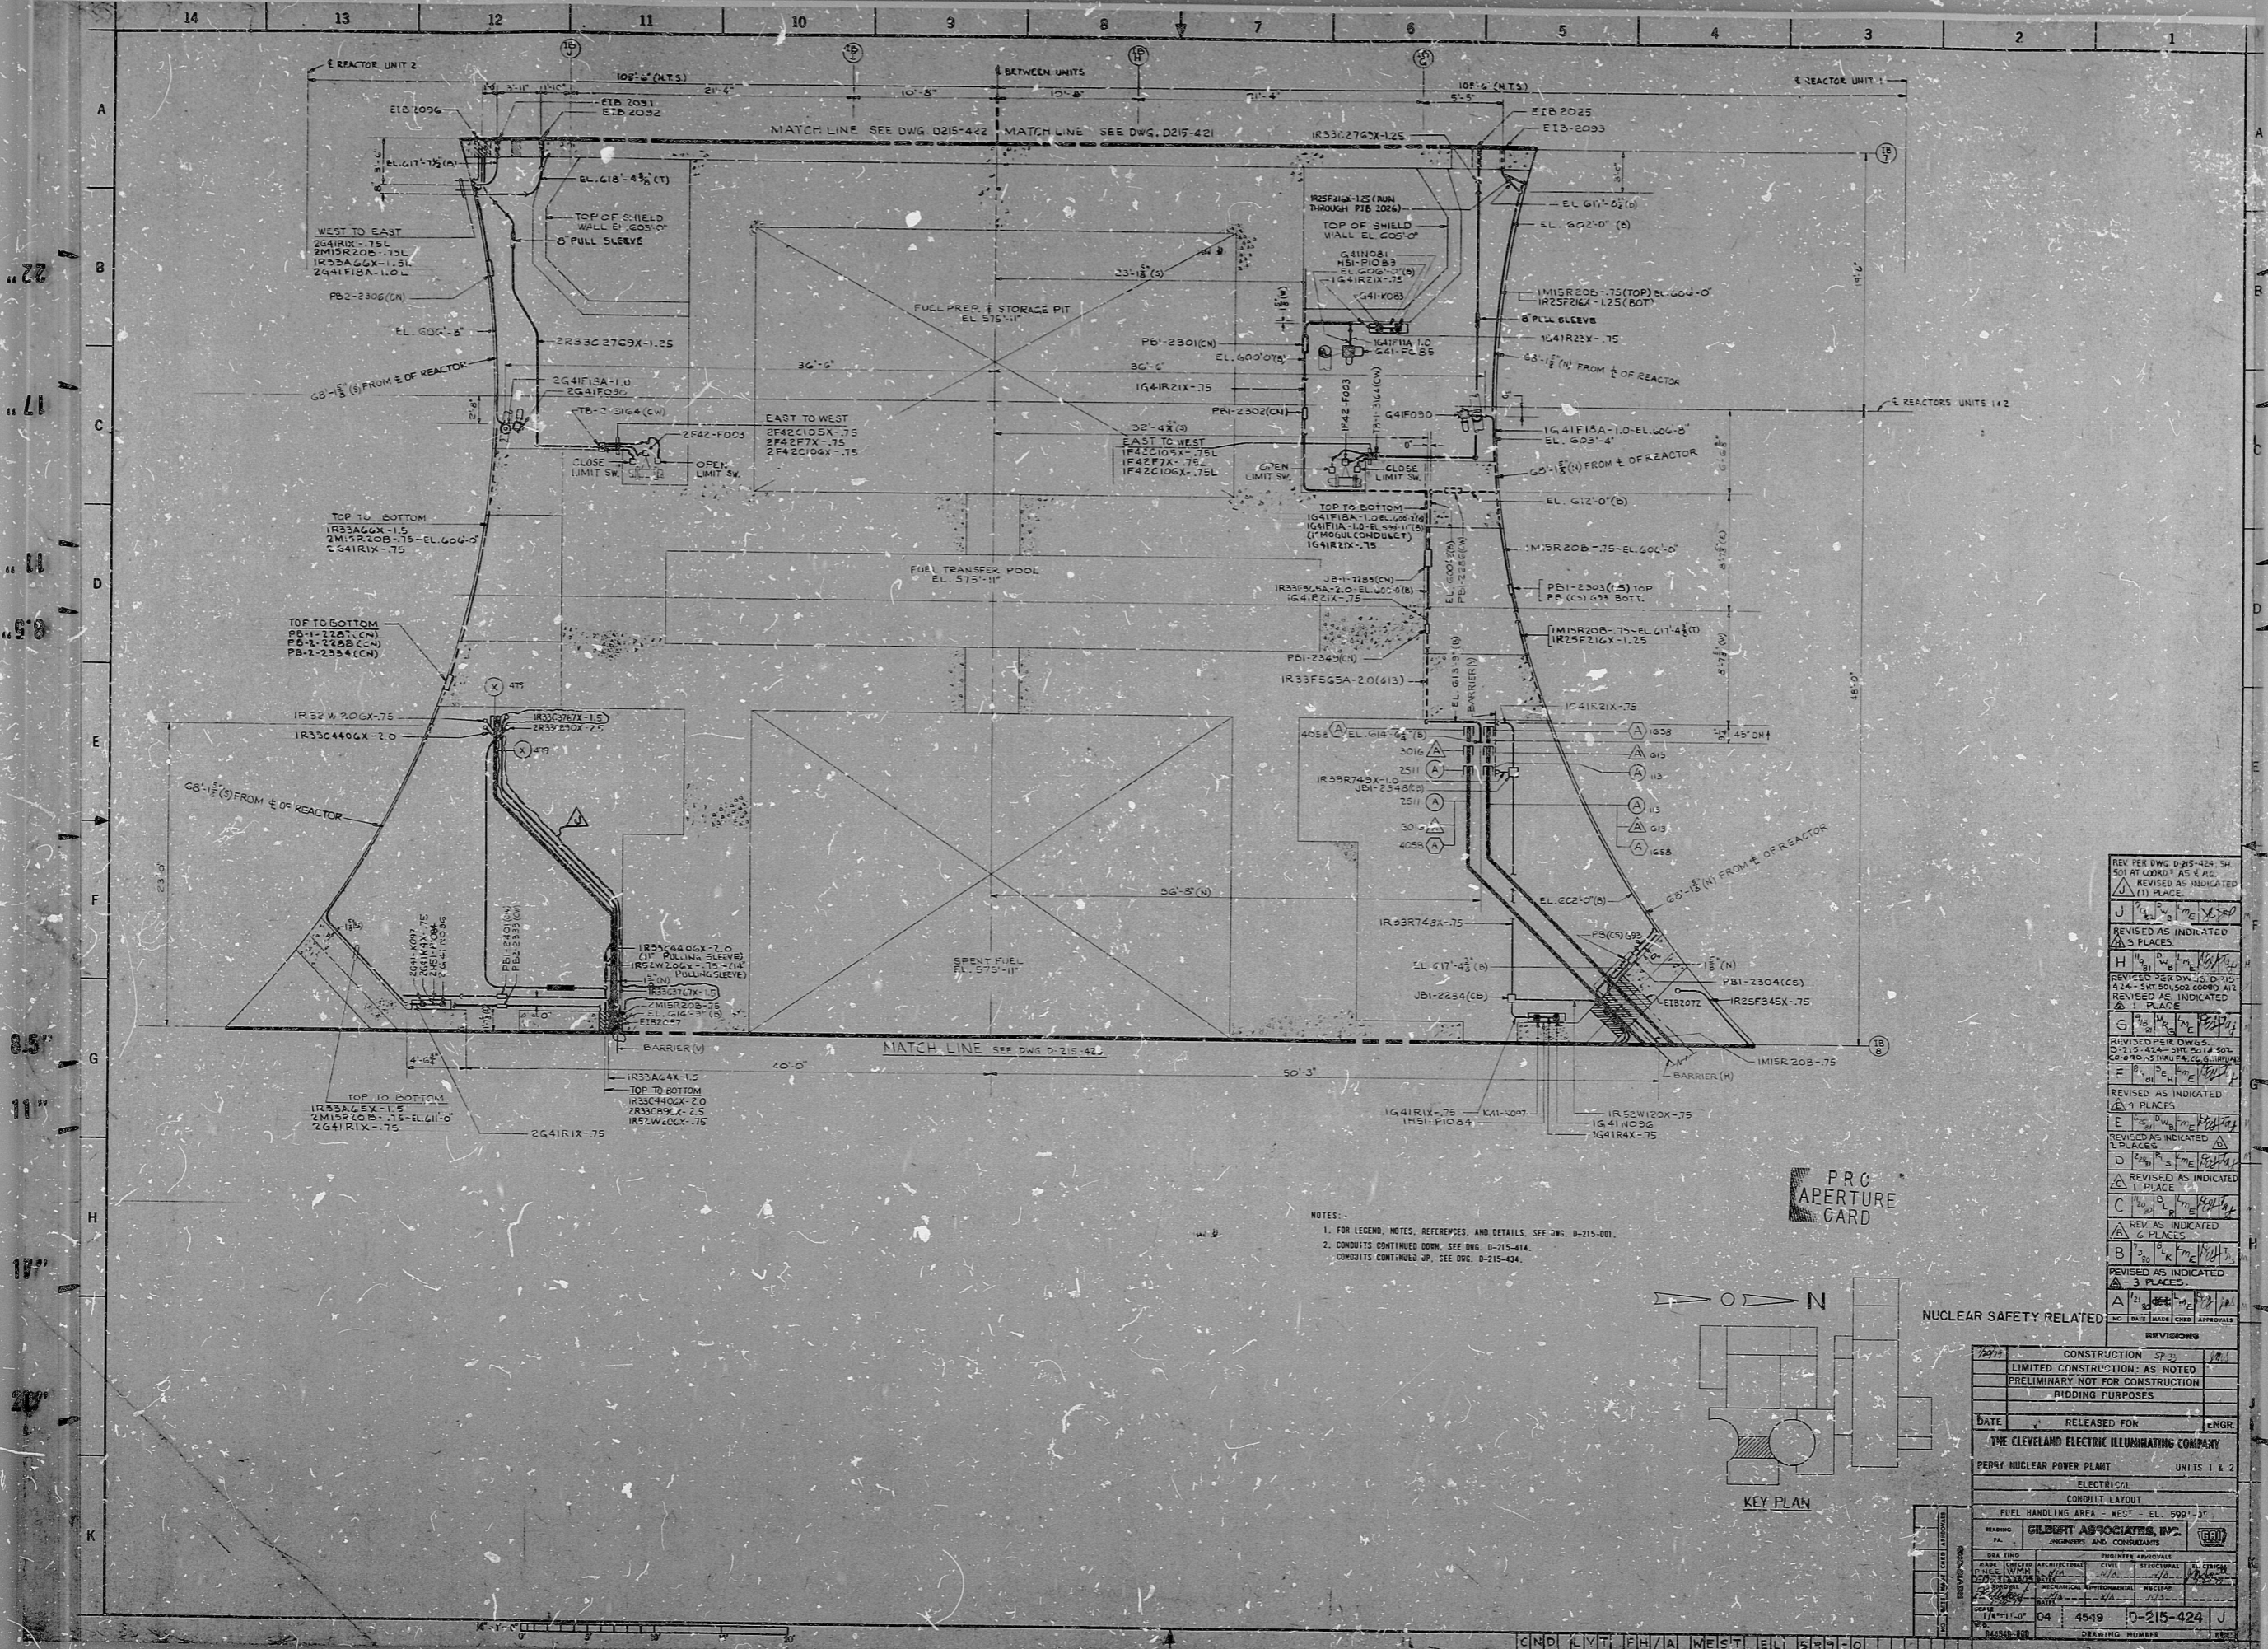

REV	BY	DATE	DESCRIPTION
1	J	10/20/75	REVISED PER DWG. D-215-424. 34" DIA. AT 600' AS 4" DIA. REVISED AS INDICATED (1) PLACE.
2	J	10/20/75	REVISED AS INDICATED (1) PLACE.
3	J	10/20/75	REVISED AS INDICATED (1) PLACE.
4	J	10/20/75	REVISED PER DWG. D-215-424. 34" DIA. AT 600' AS 4" DIA. REVISED AS INDICATED (1) PLACE.
5	J	10/20/75	REVISED PER DWG. D-215-424. 34" DIA. AT 600' AS 4" DIA. REVISED AS INDICATED (1) PLACE.
6	J	10/20/75	REVISED PER DWG. D-215-424. 34" DIA. AT 600' AS 4" DIA. REVISED AS INDICATED (1) PLACE.
7	J	10/20/75	REVISED PER DWG. D-215-424. 34" DIA. AT 600' AS 4" DIA. REVISED AS INDICATED (1) PLACE.
8	J	10/20/75	REVISED PER DWG. D-215-424. 34" DIA. AT 600' AS 4" DIA. REVISED AS INDICATED (1) PLACE.
9	J	10/20/75	REVISED PER DWG. D-215-424. 34" DIA. AT 600' AS 4" DIA. REVISED AS INDICATED (1) PLACE.
10	J	10/20/75	REVISED PER DWG. D-215-424. 34" DIA. AT 600' AS 4" DIA. REVISED AS INDICATED (1) PLACE.
11	J	10/20/75	REVISED PER DWG. D-215-424. 34" DIA. AT 600' AS 4" DIA. REVISED AS INDICATED (1) PLACE.
12	J	10/20/75	REVISED PER DWG. D-215-424. 34" DIA. AT 600' AS 4" DIA. REVISED AS INDICATED (1) PLACE.
13	J	10/20/75	REVISED PER DWG. D-215-424. 34" DIA. AT 600' AS 4" DIA. REVISED AS INDICATED (1) PLACE.
14	J	10/20/75	REVISED PER DWG. D-215-424. 34" DIA. AT 600' AS 4" DIA. REVISED AS INDICATED (1) PLACE.
15	J	10/20/75	REVISED PER DWG. D-215-424. 34" DIA. AT 600' AS 4" DIA. REVISED AS INDICATED (1) PLACE.
16	J	10/20/75	REVISED PER DWG. D-215-424. 34" DIA. AT 600' AS 4" DIA. REVISED AS INDICATED (1) PLACE.
17	J	10/20/75	REVISED PER DWG. D-215-424. 34" DIA. AT 600' AS 4" DIA. REVISED AS INDICATED (1) PLACE.
18	J	10/20/75	REVISED PER DWG. D-215-424. 34" DIA. AT 600' AS 4" DIA. REVISED AS INDICATED (1) PLACE.
19	J	10/20/75	REVISED PER DWG. D-215-424. 34" DIA. AT 600' AS 4" DIA. REVISED AS INDICATED (1) PLACE.
20	J	10/20/75	REVISED PER DWG. D-215-424. 34" DIA. AT 600' AS 4" DIA. REVISED AS INDICATED (1) PLACE.

NOTES:
 1. FOR LEGEND, NOTES, REFERENCES, AND DETAILS, SEE DWG. D-215-001.
 2. CONDUITS CONTINUED DOWN, SEE DWG. D-215-414.
 3. CONDUITS CONTINUED UP, SEE DWG. D-215-434.

PRG
 APERTURE
 GARD

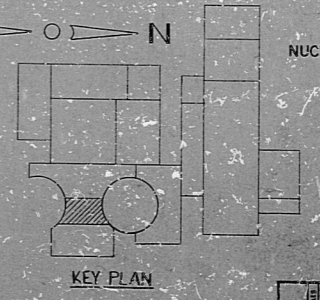

REVISIONS	
1/2/75	CONSTRUCTION 57-31
LIMITED CONSTRUCTION AS NOTED. PRELIMINARY NOT FOR CONSTRUCTION RIDDING PURPOSES.	
DATE	RELEASED FOR ENGR.
THE CLEVELAND ELECTRIC ILLUMINATING COMPANY	
PEPPI NUCLEAR POWER PLANT UNITS 1 & 2	
ELECTRICAL	
CONDUIT LAYOUT	
FUEL HANDLING AREA - WEST - EL. 599'-0"	
DESIGNED BY	GILBERT ASSOCIATES, INC.
CHECKED BY	ENGINEER AND CONSULTANT
DATE	10/20/75
SCALE	AS SHOWN
PROJECT NO.	04 4549 D-215-424 J
DRAWING NO.	04 4549 D-215-424 J

34

34

8212100173

RIDS

