

..73

..73

..72

..72

..71

..71

..70

..70

..69

..69

8.5"

8.5"

11"


11"

17"

17"

22"

22"

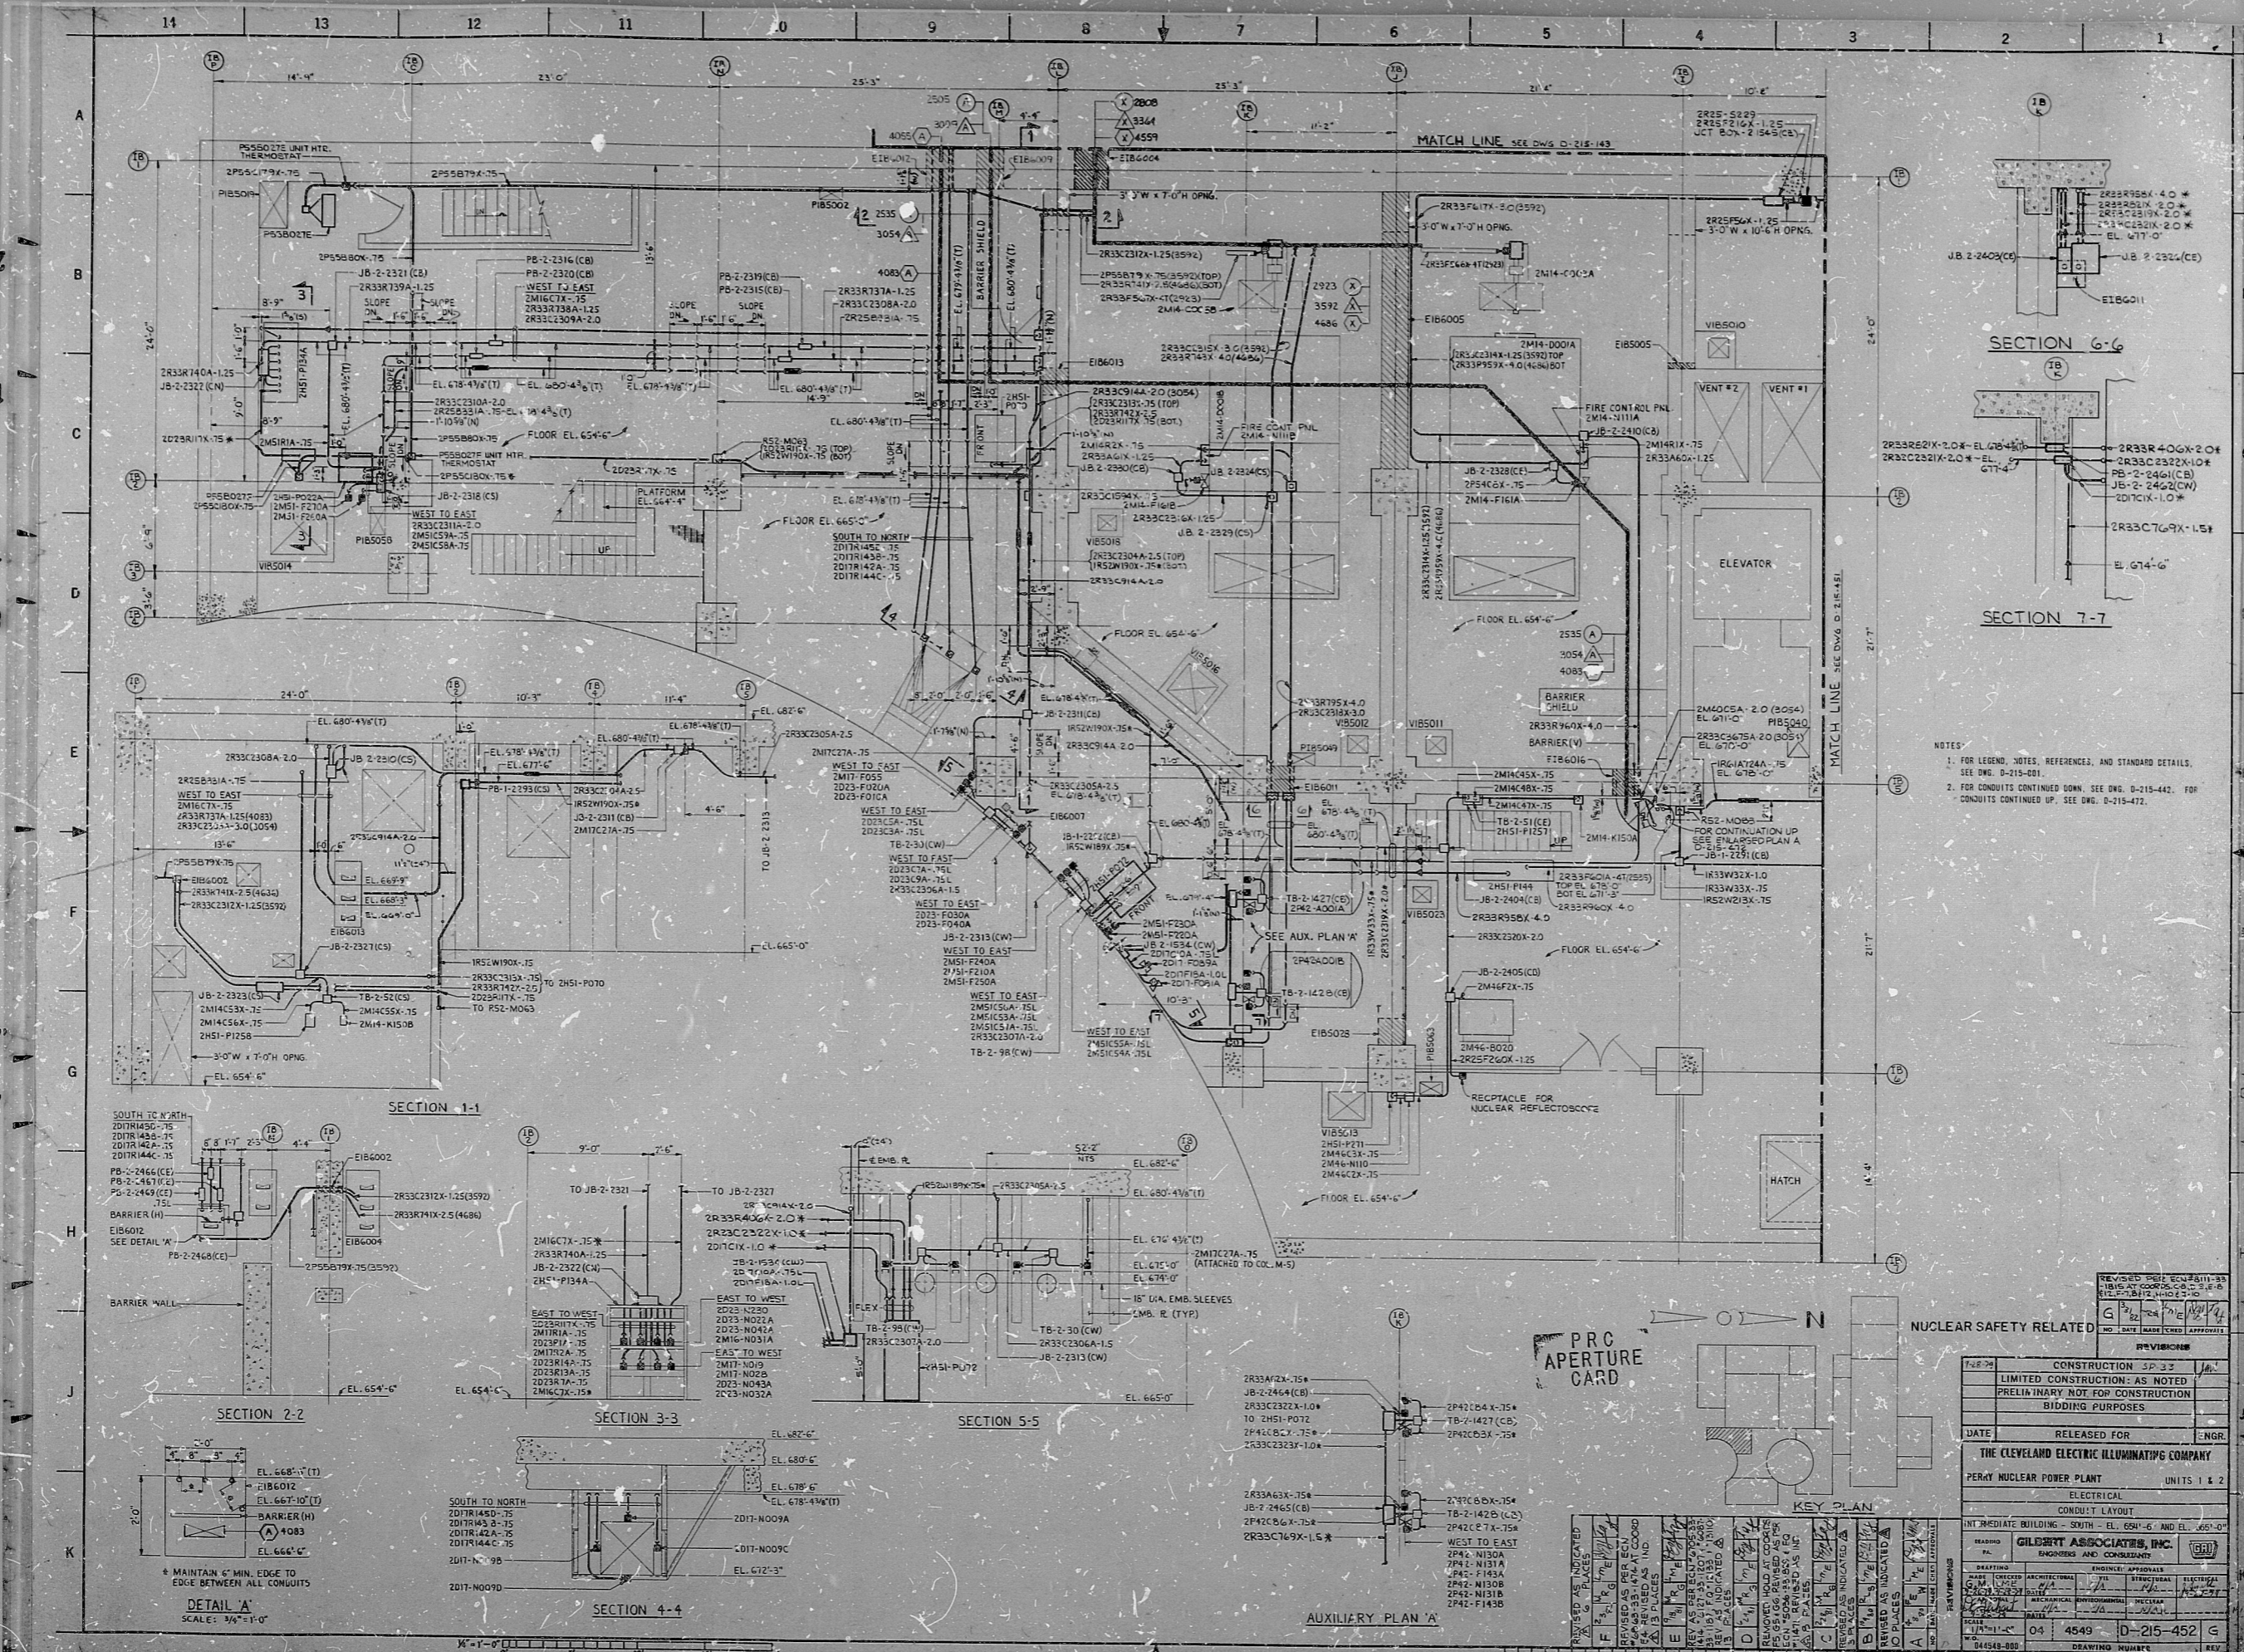

NOTES

1. FOR LEGEND, NOTES, REFERENCES, AND STANDARD DETAILS. SEE DWG. D-215-401.
2. FOR CONDUITS CONTINUED DOWN, SEE DWG. D-215-442. FOR CONDUITS CONTINUED UP, SEE DWG. D-215-412.

REVISION	DATE	BY	CHKD	APP'D
G				

NUCLEAR SAFETY RELATED

DATE	RELEASED FOR	ENGR.

THE CLEVELAND ELECTRIC ILLUMINATING COMPANY
PERAY NUCLEAR POWER PLANT UNITS 1 & 2

ELECTRICAL
CONDUIT LAYOUT

INT. MEDIANE BUILDING - SOUTH - EL. 654'-6" AND EL. 665'-0"

DRAWING NO.	04	4549	D-215-452	G
DRAWING NUMBER	04549-800			

PRC APERTURE CARD

DETAIL 'A'
SCALE: 3/4"=1'-0"

AUXILIARY PLAN 'A'

REVISION	DATE	BY	CHKD	APP'D
A				
B				
C				
D				
E				
F				
G				
H				
I				
J				
K				

..74

..74

..74

RIDS

8212100199

