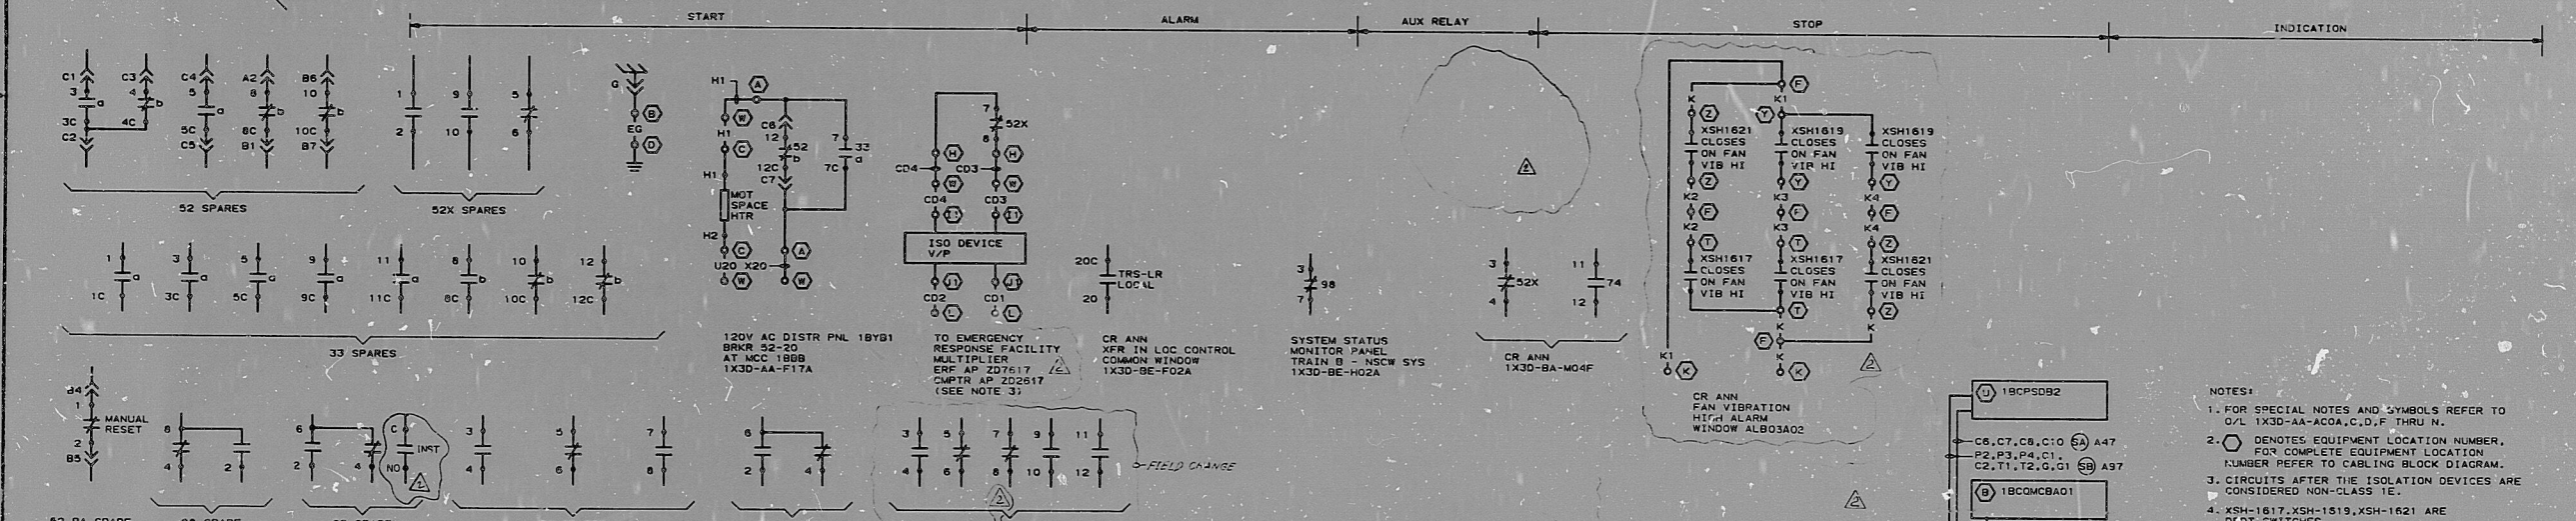
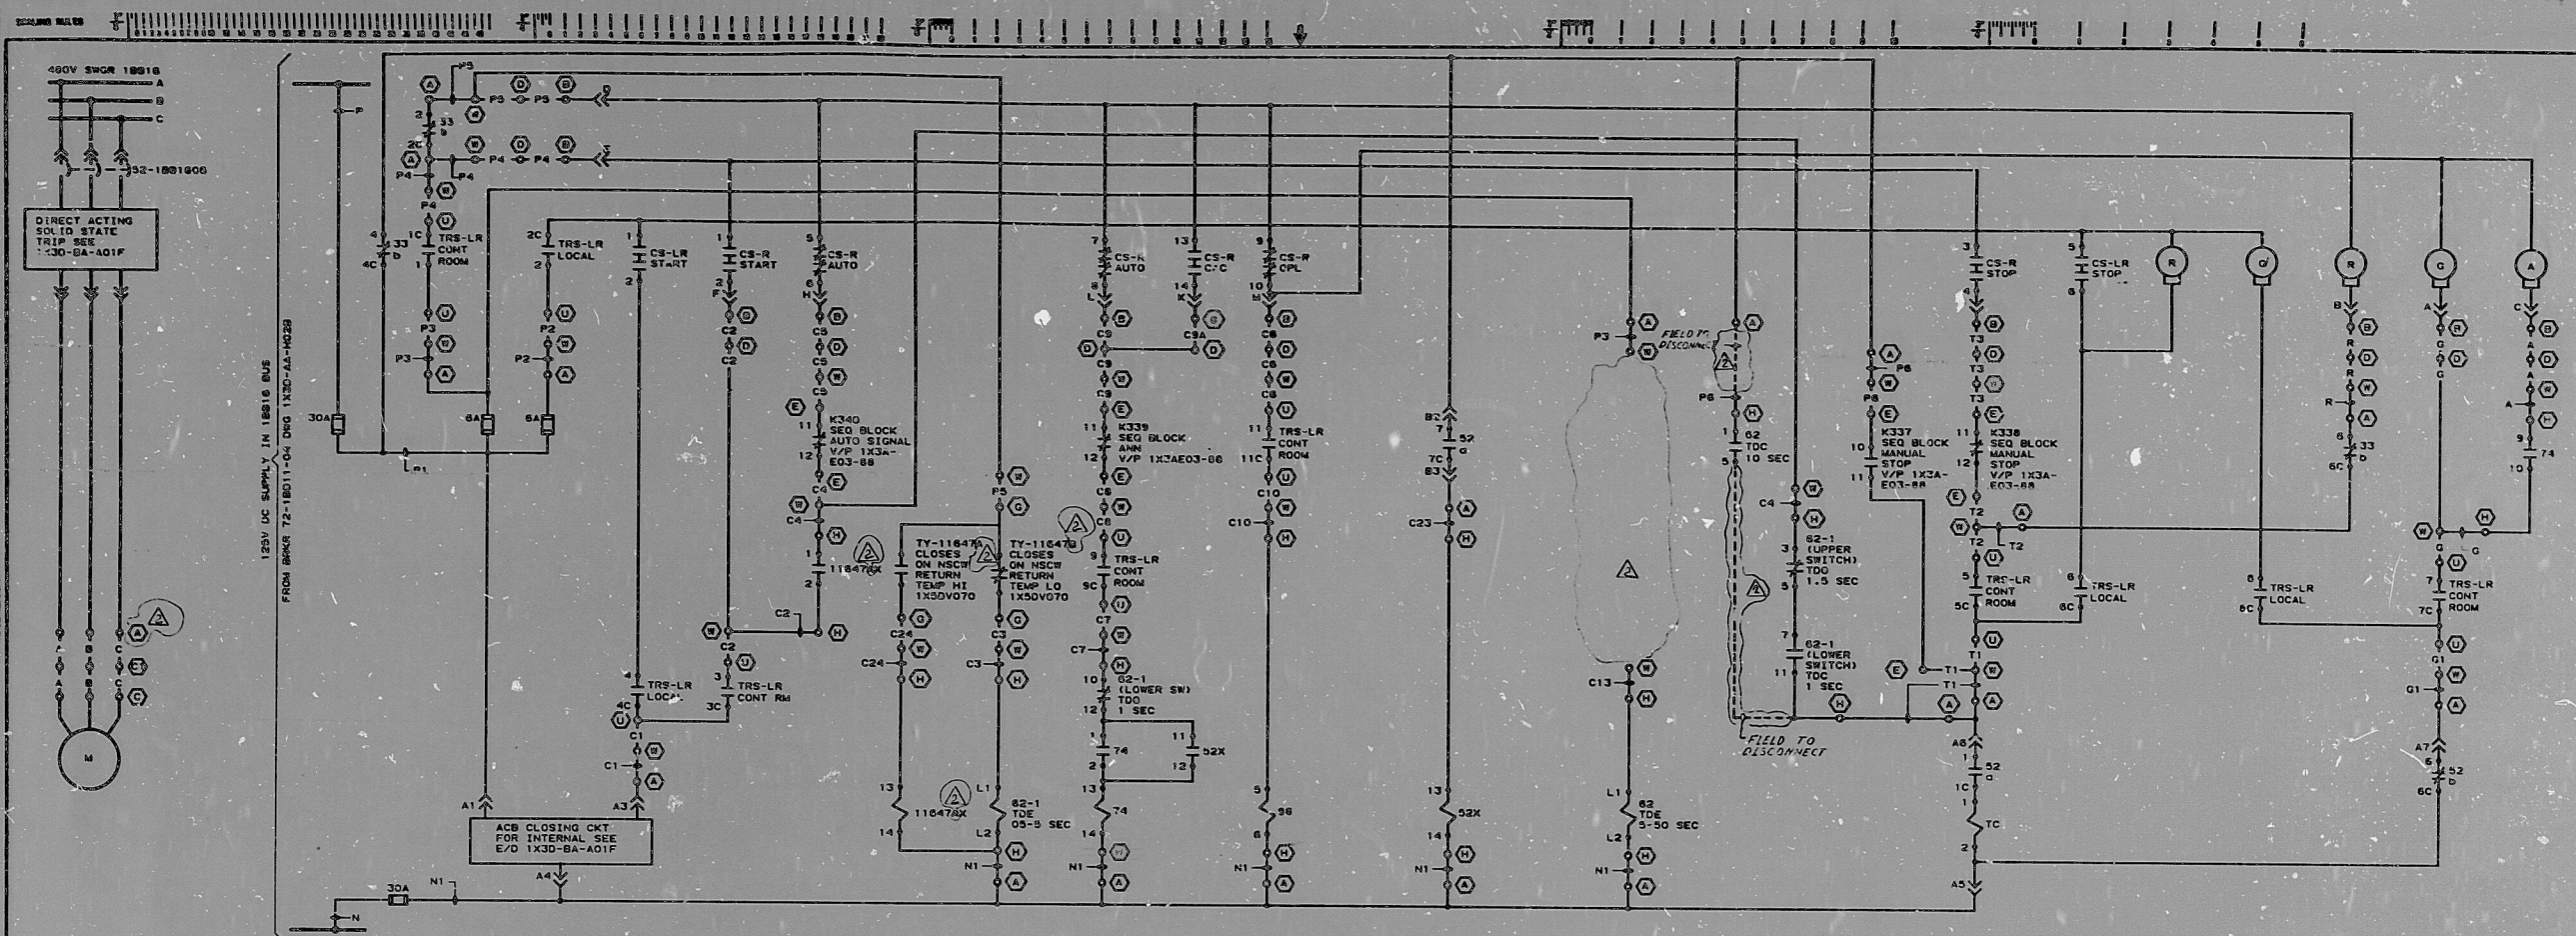


DEVICE	MFR	TYPE	MODEL NO	NUMBER	REFERENCE DWGS	REV
96	GE	MMA	12MA1185	1X40B133-1	P & I DIAGRAM	—
74	GE	HFA	12HFA144PH	1X3D-AA-17A	ONE LINE DIAGRAM	—
62	AGAST	ET000	E7012POL	1X3DNOB3-1-C	LOGIC DIAGRAM	—
52X	GE	HFA	12HFA1A42H	—	—	—
62-1	AGAST	ET000	E7014PB	—	—	—
1842AN	GE	HFA	12HFA1A42H	—	—	—

REV	NO	DATE	DR	CHK	SUPV	EGS	CHK	P.E.	DATE	NO
1	1	11/10/51	—	—	—	—	—	—	—	—
2	2	11/10/51	—	—	—	—	—	—	—	—
3	3	11/10/51	—	—	—	—	—	—	—	—
4	4	11/10/51	—	—	—	—	—	—	—	—
5	5	11/10/51	—	—	—	—	—	—	—	—
6	6	11/10/51	—	—	—	—	—	—	—	—

PRC
APERTURE
CARD

NUCLEAR SAFETY RELATED

NUCLEAR SERVICE COOLING TWR FAN MOTOR
BECHTEL
LOS ANGELES
GEORGIA POWER COMPANY
ALVIN W. VOGTLE NUCLEAR PLANT

ELEMENTARY DIAGRAM
NUCLEAR SERVICE COOLING WATER SYSTEM
1-1202-W4-002-M02

SCALE: NONE
DRAWING NO. 1X3D-BO-K03F
REV. 2

RIDS

8310030273

