


38

38

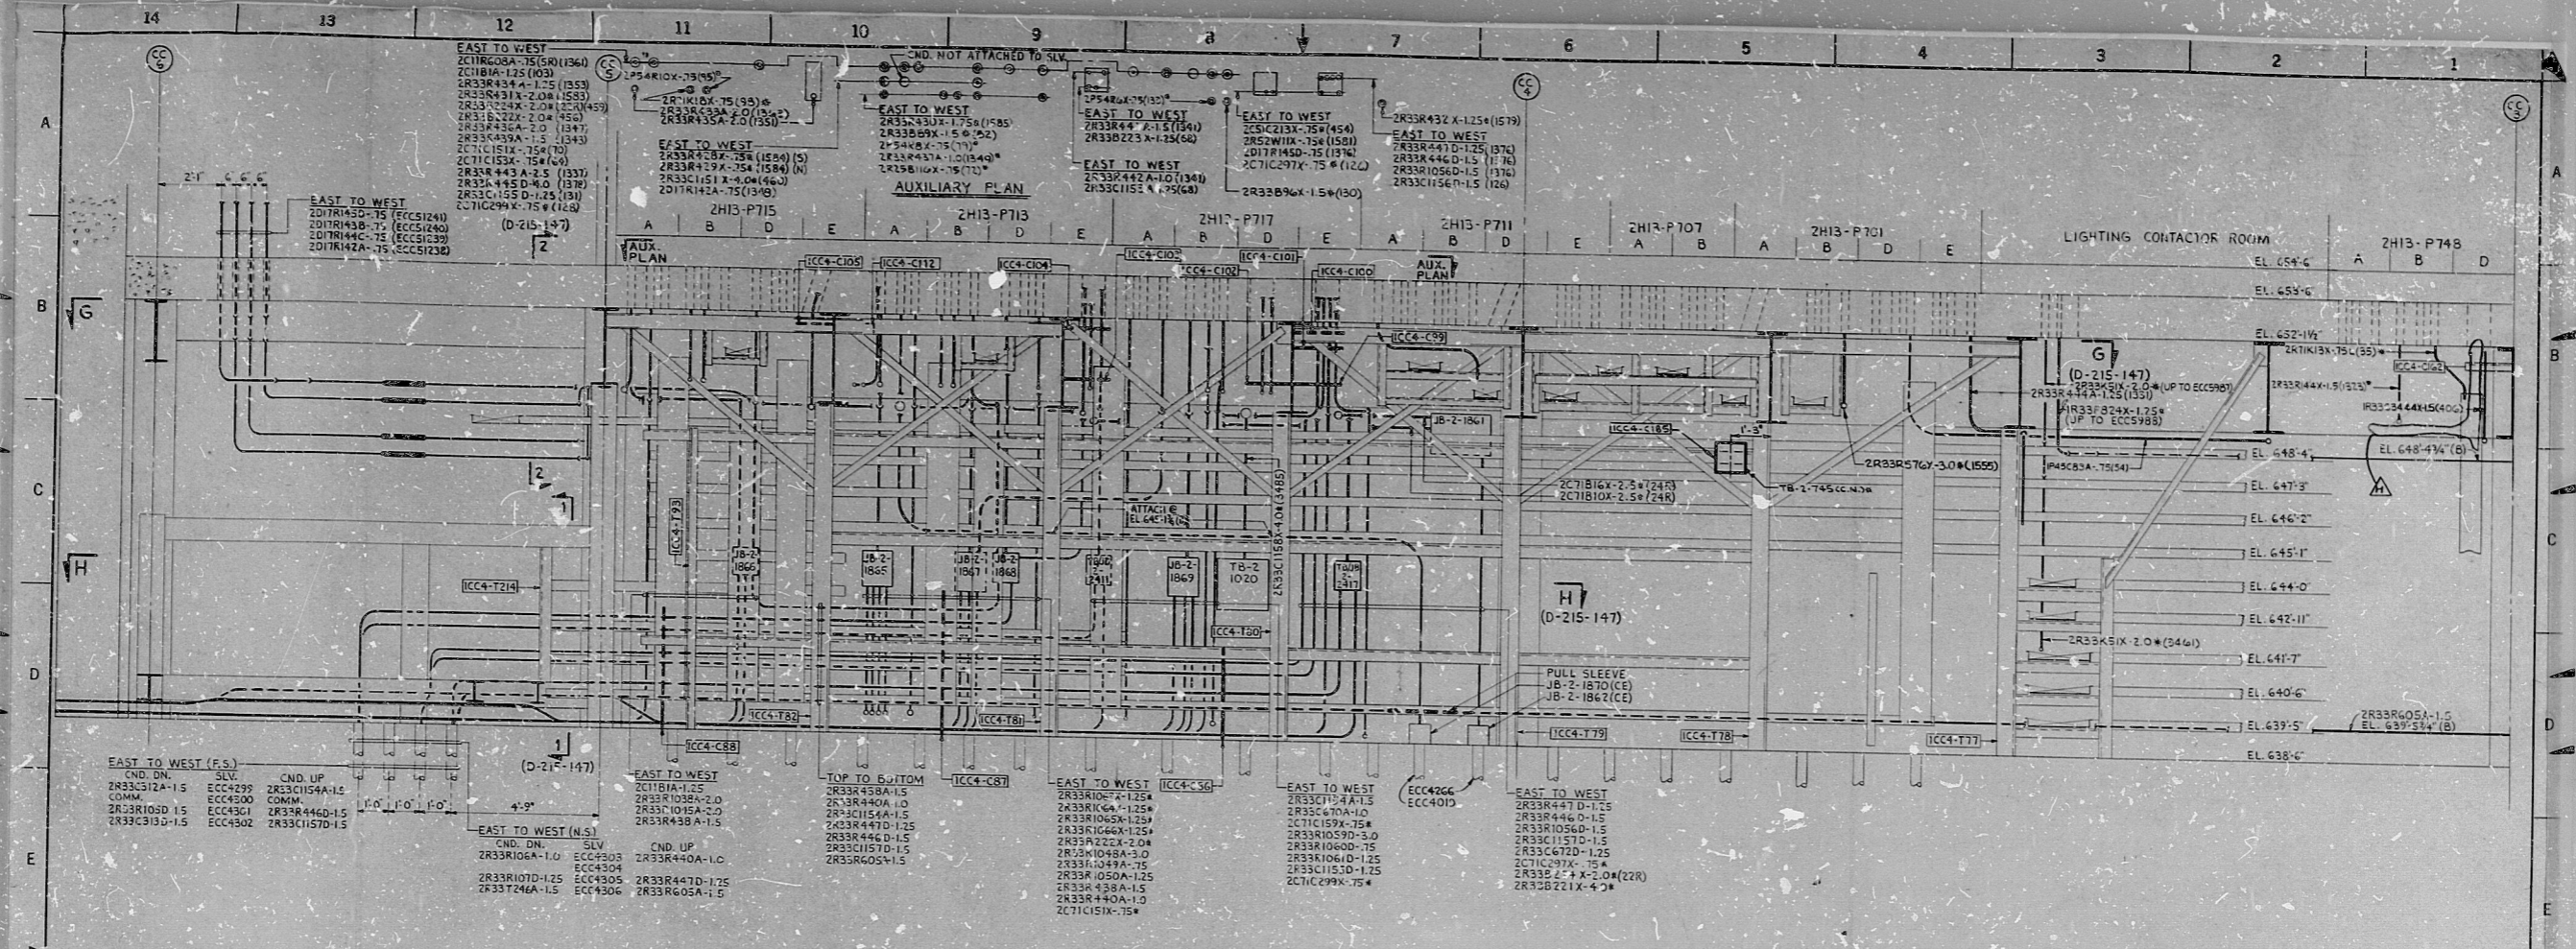

22

22

17

17

11

11

50

50

85"

85"

11"

11"

17"

17"

22"

22"

**SECTION 4-4**  
 DWG. D-215-177  
 SCALE: 1/2" = 1'-0"

**PRC  
 APERTURE  
 CARD**

NOTES:  
 1. FOR ADDITIONAL NOTES, REFERENCES, LEGEND, AND DETAILS, SEE DRAWING D-215-001.

REVISIONS	
NO.	DATE MADE

CONSTRUCTION	
LIMITED CONSTRUCTION: AS NOTED	
PRELIMINARY NOT FOR CONSTRUCTION	
BIDDING PURPOSES	
DATE RELEASED FOR ENGR.	
THE CLEVELAND ELECTRIC ILLUMINATING COMPANY	
PERRY NUCLEAR POWER PLANT UNITS 1 & 2	
ELECTRICAL	
CONDUIT LAYOUT	
CONTROL COMPLEX - SECTIONS AND DETAILS	
PREPARED BY	ENGINEER APPROVAL
DESIGNED BY	CHECKED BY
DRAWN BY	DATE
SCALE	
REVISED BY	
DATE	
PROJECT NO.	D-215-664 H
DRAWING NUMBER	REV

REVISION	DATE	BY	DESCRIPTION
A			REVISED AS INDICATED IN PLACE
B			REVISED AS INDICATED IN PLACE
C			REVISED AS INDICATED IN PLACE
D			REVISED AS INDICATED IN PLACE
E			REVISED AS INDICATED IN PLACE
F			REVISED AS INDICATED IN PLACE
G			REVISED AS INDICATED IN PLACE
H			REVISED AS INDICATED IN PLACE
I			REVISED AS INDICATED IN PLACE
J			REVISED AS INDICATED IN PLACE
K			REVISED AS INDICATED IN PLACE
L			REVISED AS INDICATED IN PLACE
M			REVISED AS INDICATED IN PLACE
N			REVISED AS INDICATED IN PLACE
O			REVISED AS INDICATED IN PLACE
P			REVISED AS INDICATED IN PLACE
Q			REVISED AS INDICATED IN PLACE
R			REVISED AS INDICATED IN PLACE
S			REVISED AS INDICATED IN PLACE
T			REVISED AS INDICATED IN PLACE
U			REVISED AS INDICATED IN PLACE
V			REVISED AS INDICATED IN PLACE
W			REVISED AS INDICATED IN PLACE
X			REVISED AS INDICATED IN PLACE
Y			REVISED AS INDICATED IN PLACE
Z			REVISED AS INDICATED IN PLACE

34

34



RIDS

82-2100344

