

34

34

22

22

17

17

11

11

8.5

8.5

8.5

8.5

11

11


17

17

22

22

34

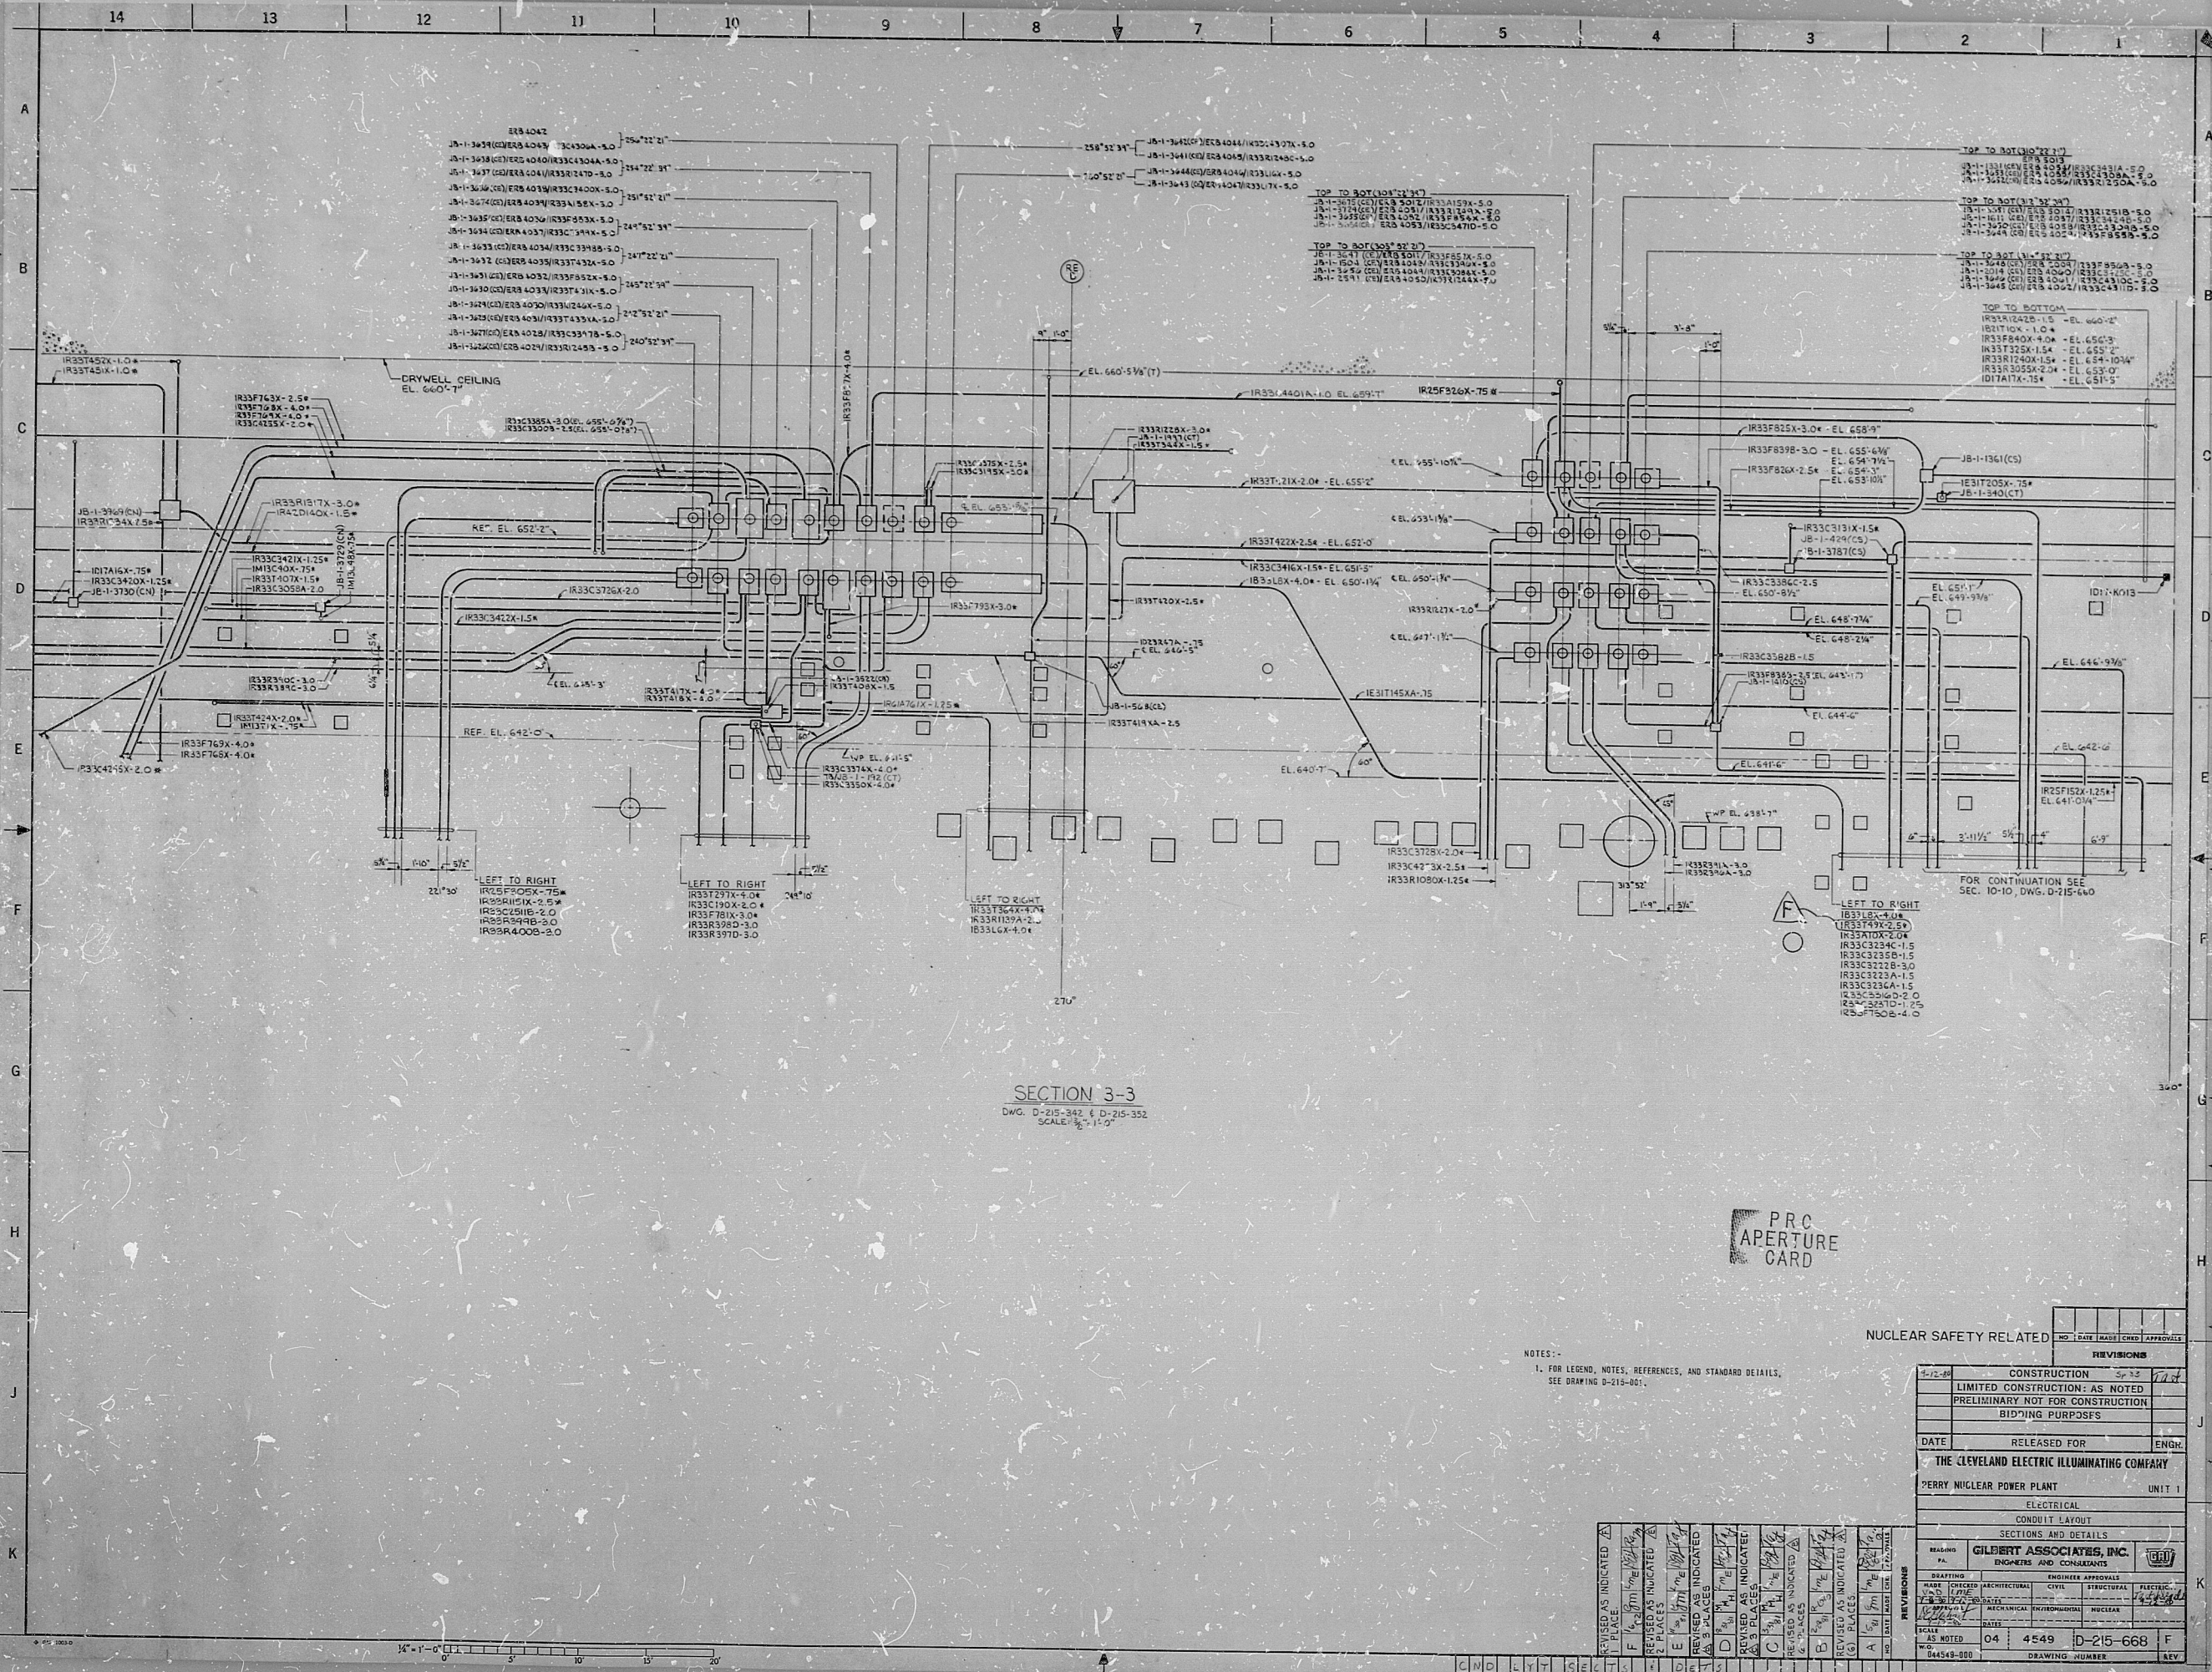

SECTION 3-3
 DWG. D-215-312 & D-215-352
 SCALE: 3/8\"/>

PRO
 APERTURE
 CARD

NOTES:
 1. FOR LEGEND, NOTES, REFERENCES, AND STANDARD DETAILS,
 SEE DRAWING D-215-001.

NUCLEAR SAFETY RELATED

REVISIONS	
NO.	DESCRIPTION
1	CONSTRUCTION
2	LIMITED CONSTRUCTION AS NOTED
3	PRELIMINARY NOT FOR CONSTRUCTION
4	BIDDING PURPOSES
DATE	RELEASED FOR
THE CLEVELAND ELECTRIC ILLUMINATING COMPANY	
PERRY NUCLEAR POWER PLANT UNIT 1	
ELECTRICAL	
CONDUIT LAYOUT	
SECTIONS AND DETAILS	
GILBERT ASSOCIATES, INC.	
ENGINEERS AND CONSULTANTS	
DESIGNED	ENGINEER APPROVALS
CHECKED	ARCHITECTURAL
DRAWN	CIVIL
DATE	STRUCTURAL
SCALE	ELECTRICAL
AS NOTED	MECHANICAL
04	MECHANICAL
4549	NUCLEAR
D-215-668	
F	
84548-000	DRAWING NUMBER
	REV

REVISIONS	DATE	BY	CHKD.	APP'D.
1	10/1/68	J. W. [Signature]	[Signature]	[Signature]
2	10/1/68	[Signature]	[Signature]	[Signature]
3	10/1/68	[Signature]	[Signature]	[Signature]
4	10/1/68	[Signature]	[Signature]	[Signature]
5	10/1/68	[Signature]	[Signature]	[Signature]
6	10/1/68	[Signature]	[Signature]	[Signature]
7	10/1/68	[Signature]	[Signature]	[Signature]
8	10/1/68	[Signature]	[Signature]	[Signature]
9	10/1/68	[Signature]	[Signature]	[Signature]
10	10/1/68	[Signature]	[Signature]	[Signature]
11	10/1/68	[Signature]	[Signature]	[Signature]
12	10/1/68	[Signature]	[Signature]	[Signature]
13	10/1/68	[Signature]	[Signature]	[Signature]
14	10/1/68	[Signature]	[Signature]	[Signature]
15	10/1/68	[Signature]	[Signature]	[Signature]
16	10/1/68	[Signature]	[Signature]	[Signature]
17	10/1/68	[Signature]	[Signature]	[Signature]
18	10/1/68	[Signature]	[Signature]	[Signature]
19	10/1/68	[Signature]	[Signature]	[Signature]
20	10/1/68	[Signature]	[Signature]	[Signature]

RIDS

8212100352

