

34"

34"

22"

22"

17"

17"

11"

11"

9.8"

9.8"

8.5"

8.5"

11"

11"

17"


17"

22"

22"

34"

34"

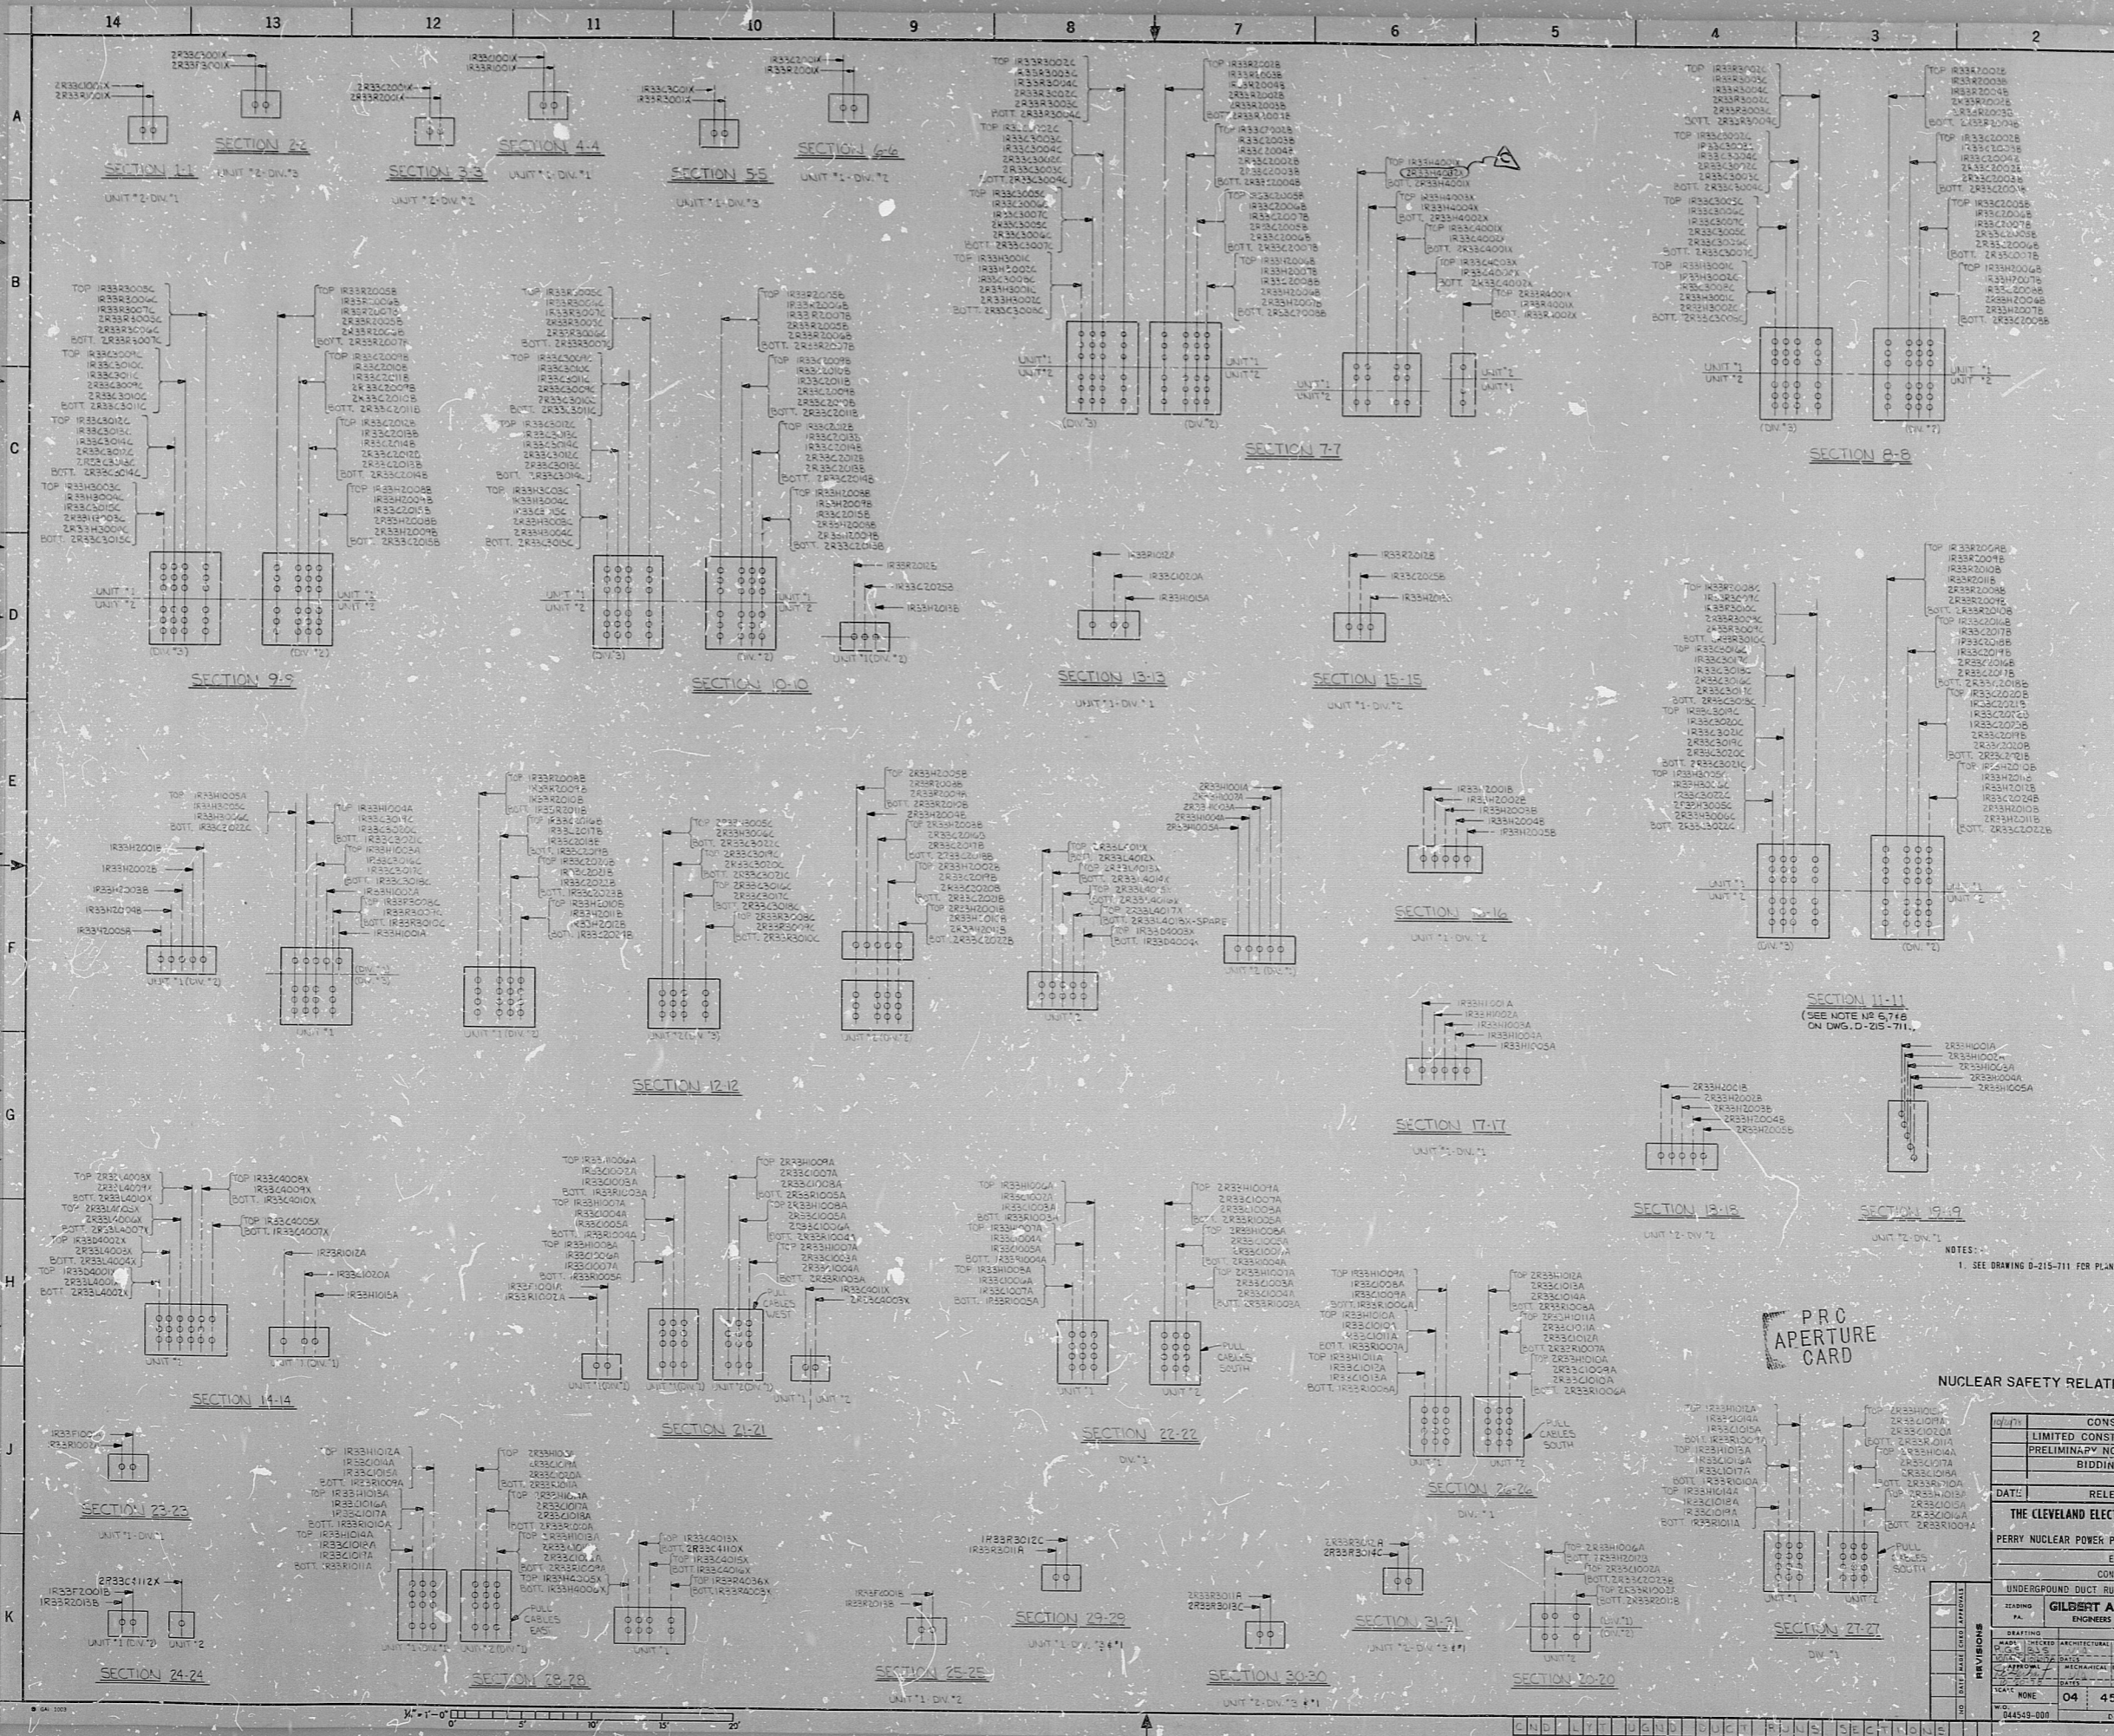

NOTES:
 1. SEE DRAWING D-215-711 FOR PLAN

PRC
 APERTURE
 CARD

NUCLEAR SAFETY RELATED

REVISIONS	
NO. 1	CONSTRUCTION SP 23 10
NO. 2	LIMITED CONSTRUCTION: AS NOTED
NO. 3	PRELIMINARY: NOT FOR CONSTRUCTION
NO. 4	BIDDING PURPOSES
DATE:	RELEASED FOR: ENGR.
THE CLEVELAND ELECTRIC ILLUMINATING COMPANY	
PERRY NUCLEAR POWER PLANT UNITS 1 & 2	
ELECTRICAL CONDUIT LAYOUT	
UNDERGROUND DUCT RUNS SECTION 1-1 THRU 31-31	
DRAWING NO. 04 4549 D-215-712 C	
DRAWING NUMBER REV	

RIDS

82-2100366

