


34
27
17
11
58
8.5
11
17
22
34

34
27
17
11
58
8.5
11
17
22
34

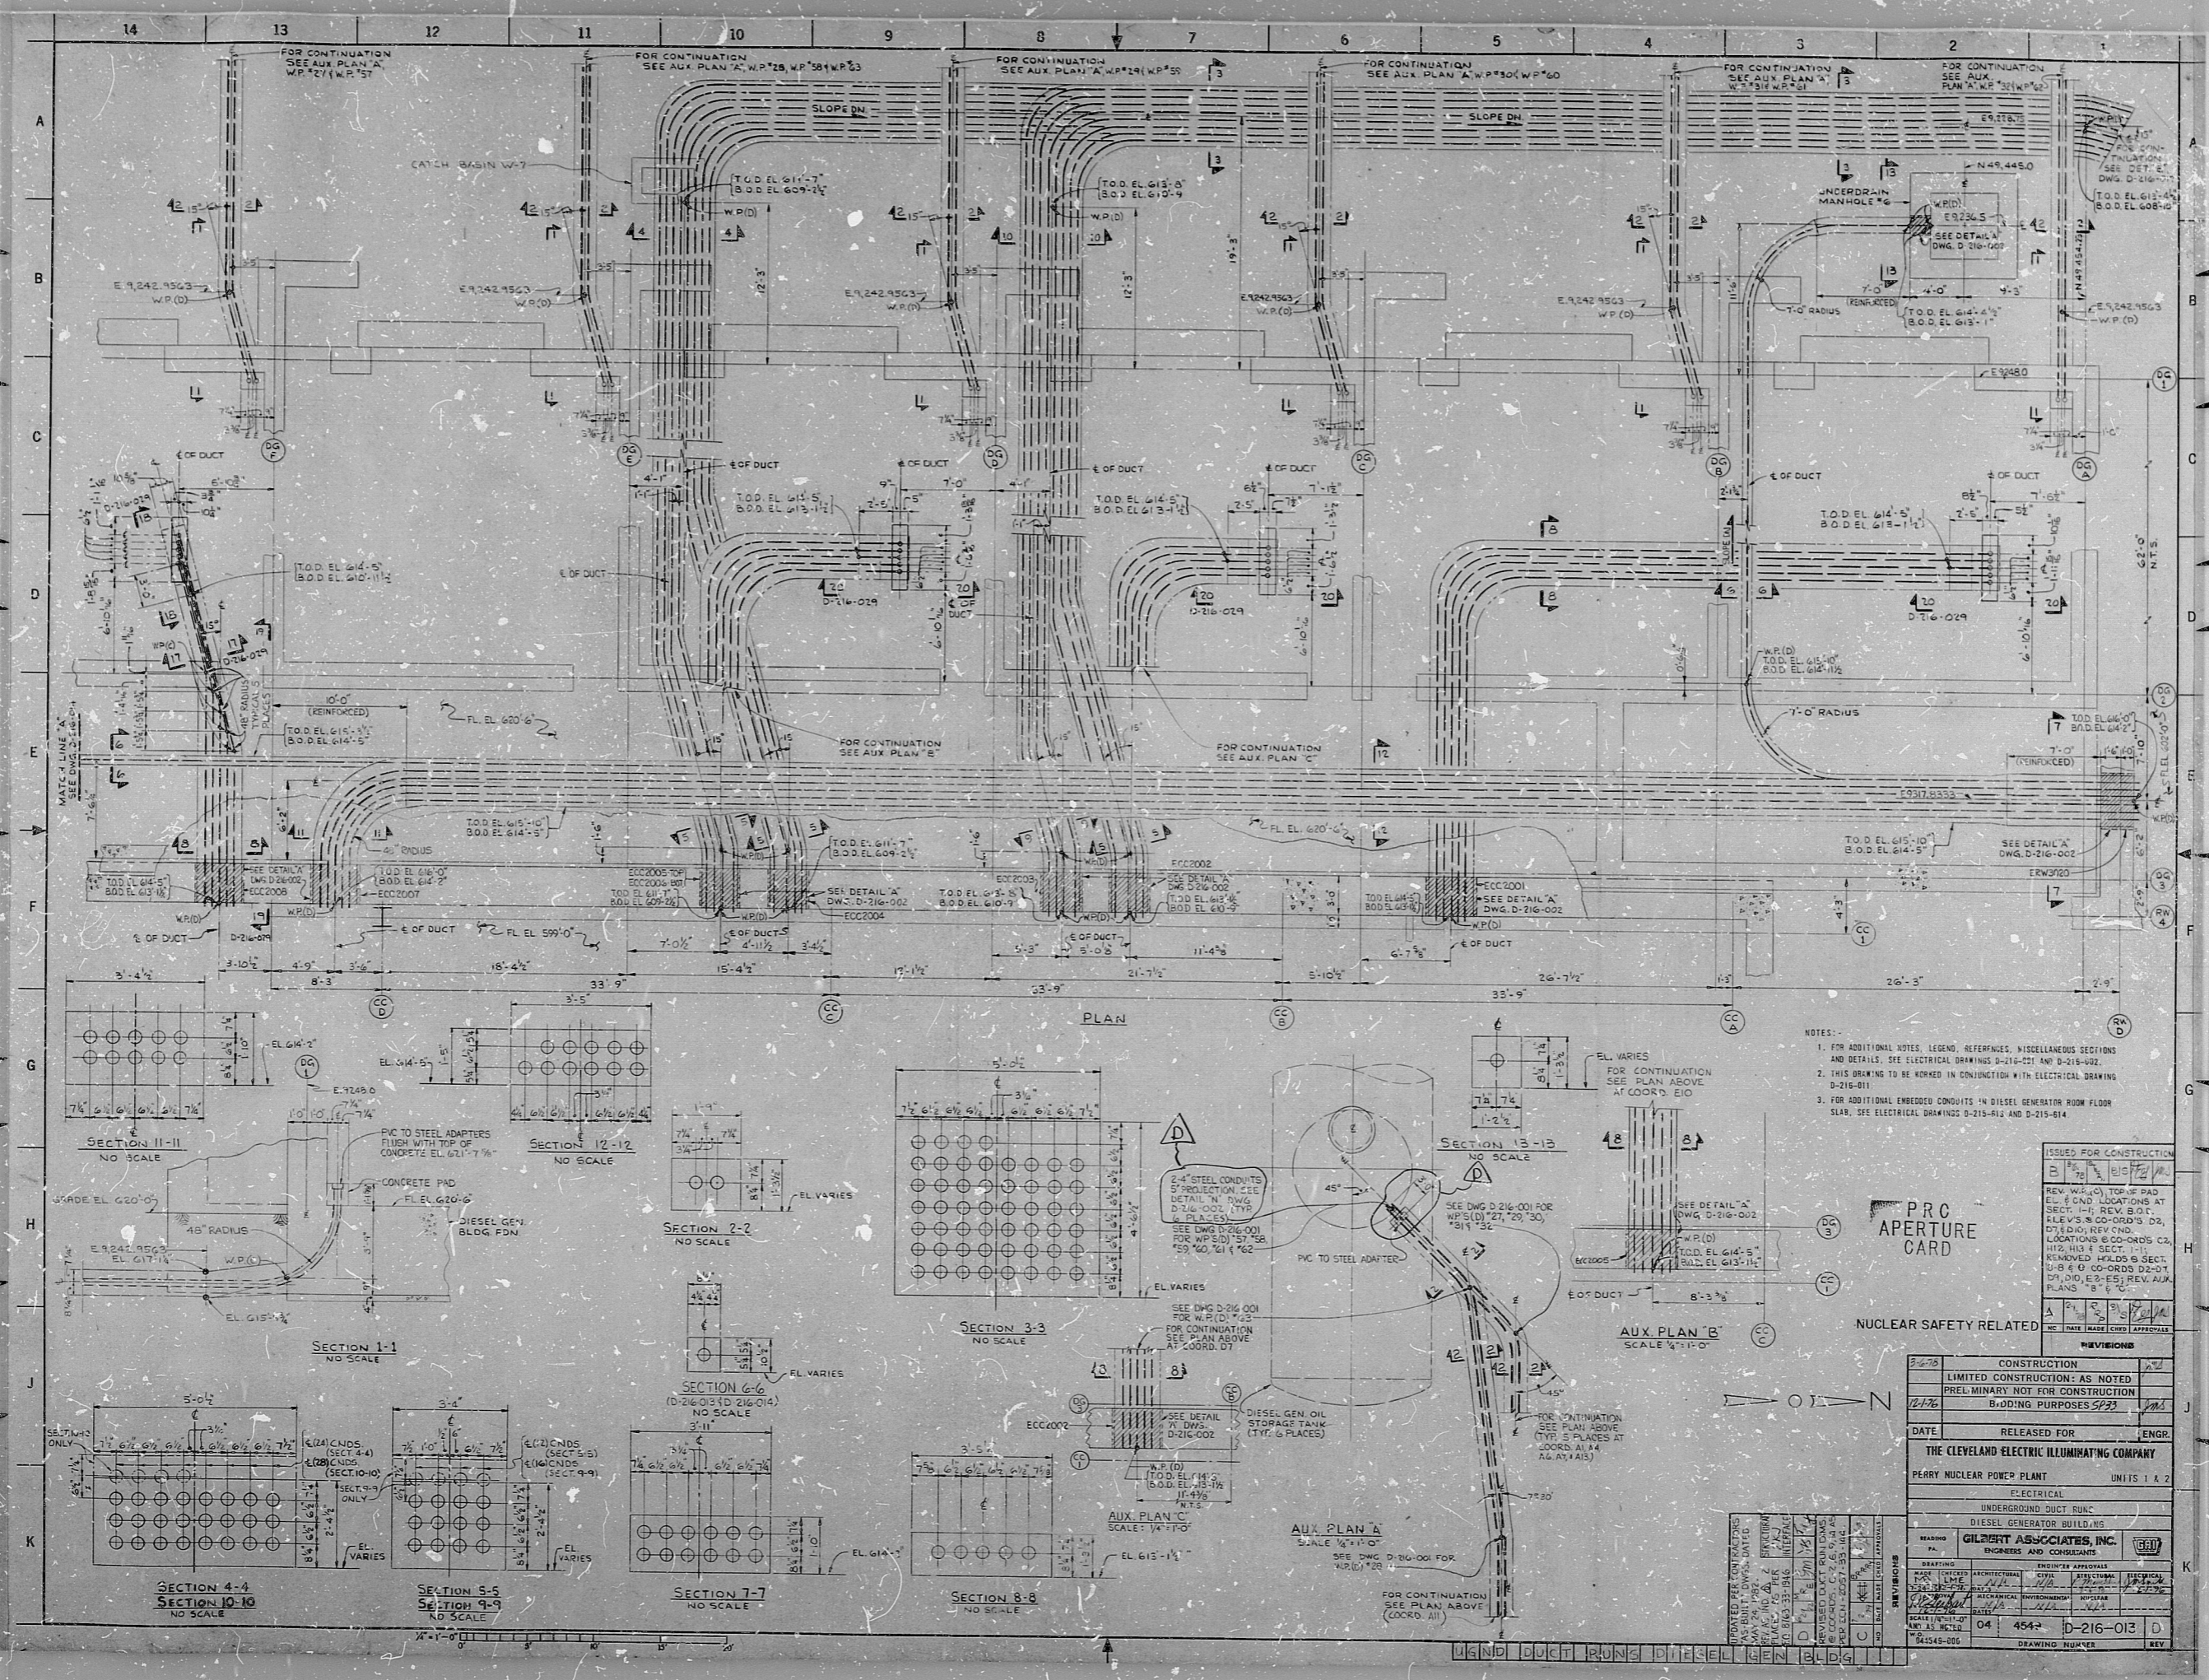

- NOTES:
- 1. FOR ADDITIONAL NOTES, LEGEND, REFERENCES, MISCELLANEOUS SECTIONS AND DETAILS, SEE ELECTRICAL DRAWINGS D-216-021 AND D-216-022.
 - 2. THIS DRAWING TO BE WORKED IN CONJUNCTION WITH ELECTRICAL DRAWING D-216-011.
 - 3. FOR ADDITIONAL EMBEDDED CONDUITS IN DIESEL GENERATOR ROOM FLOOR SLAB, SEE ELECTRICAL DRAWINGS D-216-012 AND D-216-014.

PRC APERTURE CARD

NUCLEAR SAFETY RELATED

ISSUED FOR CONSTRUCTION	REV. DATE	BY	APP. DATE
12-16-55	12-16-55	JPM	
12-16-55	12-16-55	JPM	

CONSTRUCTION	AS NOTED
LIMITED CONSTRUCTION:	AS NOTED
PRELIMINARY NOT FOR CONSTRUCTION	
BIDDING PURPOSES	5/23/55

DATE	RELEASED FOR	ENGR.
		JPM

THE CLEVELAND ELECTRIC ILLUMINATING COMPANY

PERRY NUCLEAR POWER PLANT UNITS 1 & 2

ELECTRICAL

UNDERGROUND DUCT RUNS

DIESEL GENERATOR BUILDING

MARKED	PAID	DATE	BY	APPROVED
PAID	12-16-55	JPM		

GILBERT ASSOCIATES, INC. ENGINEERS AND CONSULTANTS

REVISIONS	NO.	DATE	DESCRIPTION
1	12-16-55	JPM	ISSUED FOR CONSTRUCTION
2	12-16-55	JPM	REVISIONS TO DRAWING

DWG. NO. D-216-013

LEGEND DUCT RUNS DIESEL GEN BLDG

RIDS

82 2100382

