

37

38

22

22

17

17

11

11

8.5

8.5

8.5

8.5

11


11

17

17

22

22

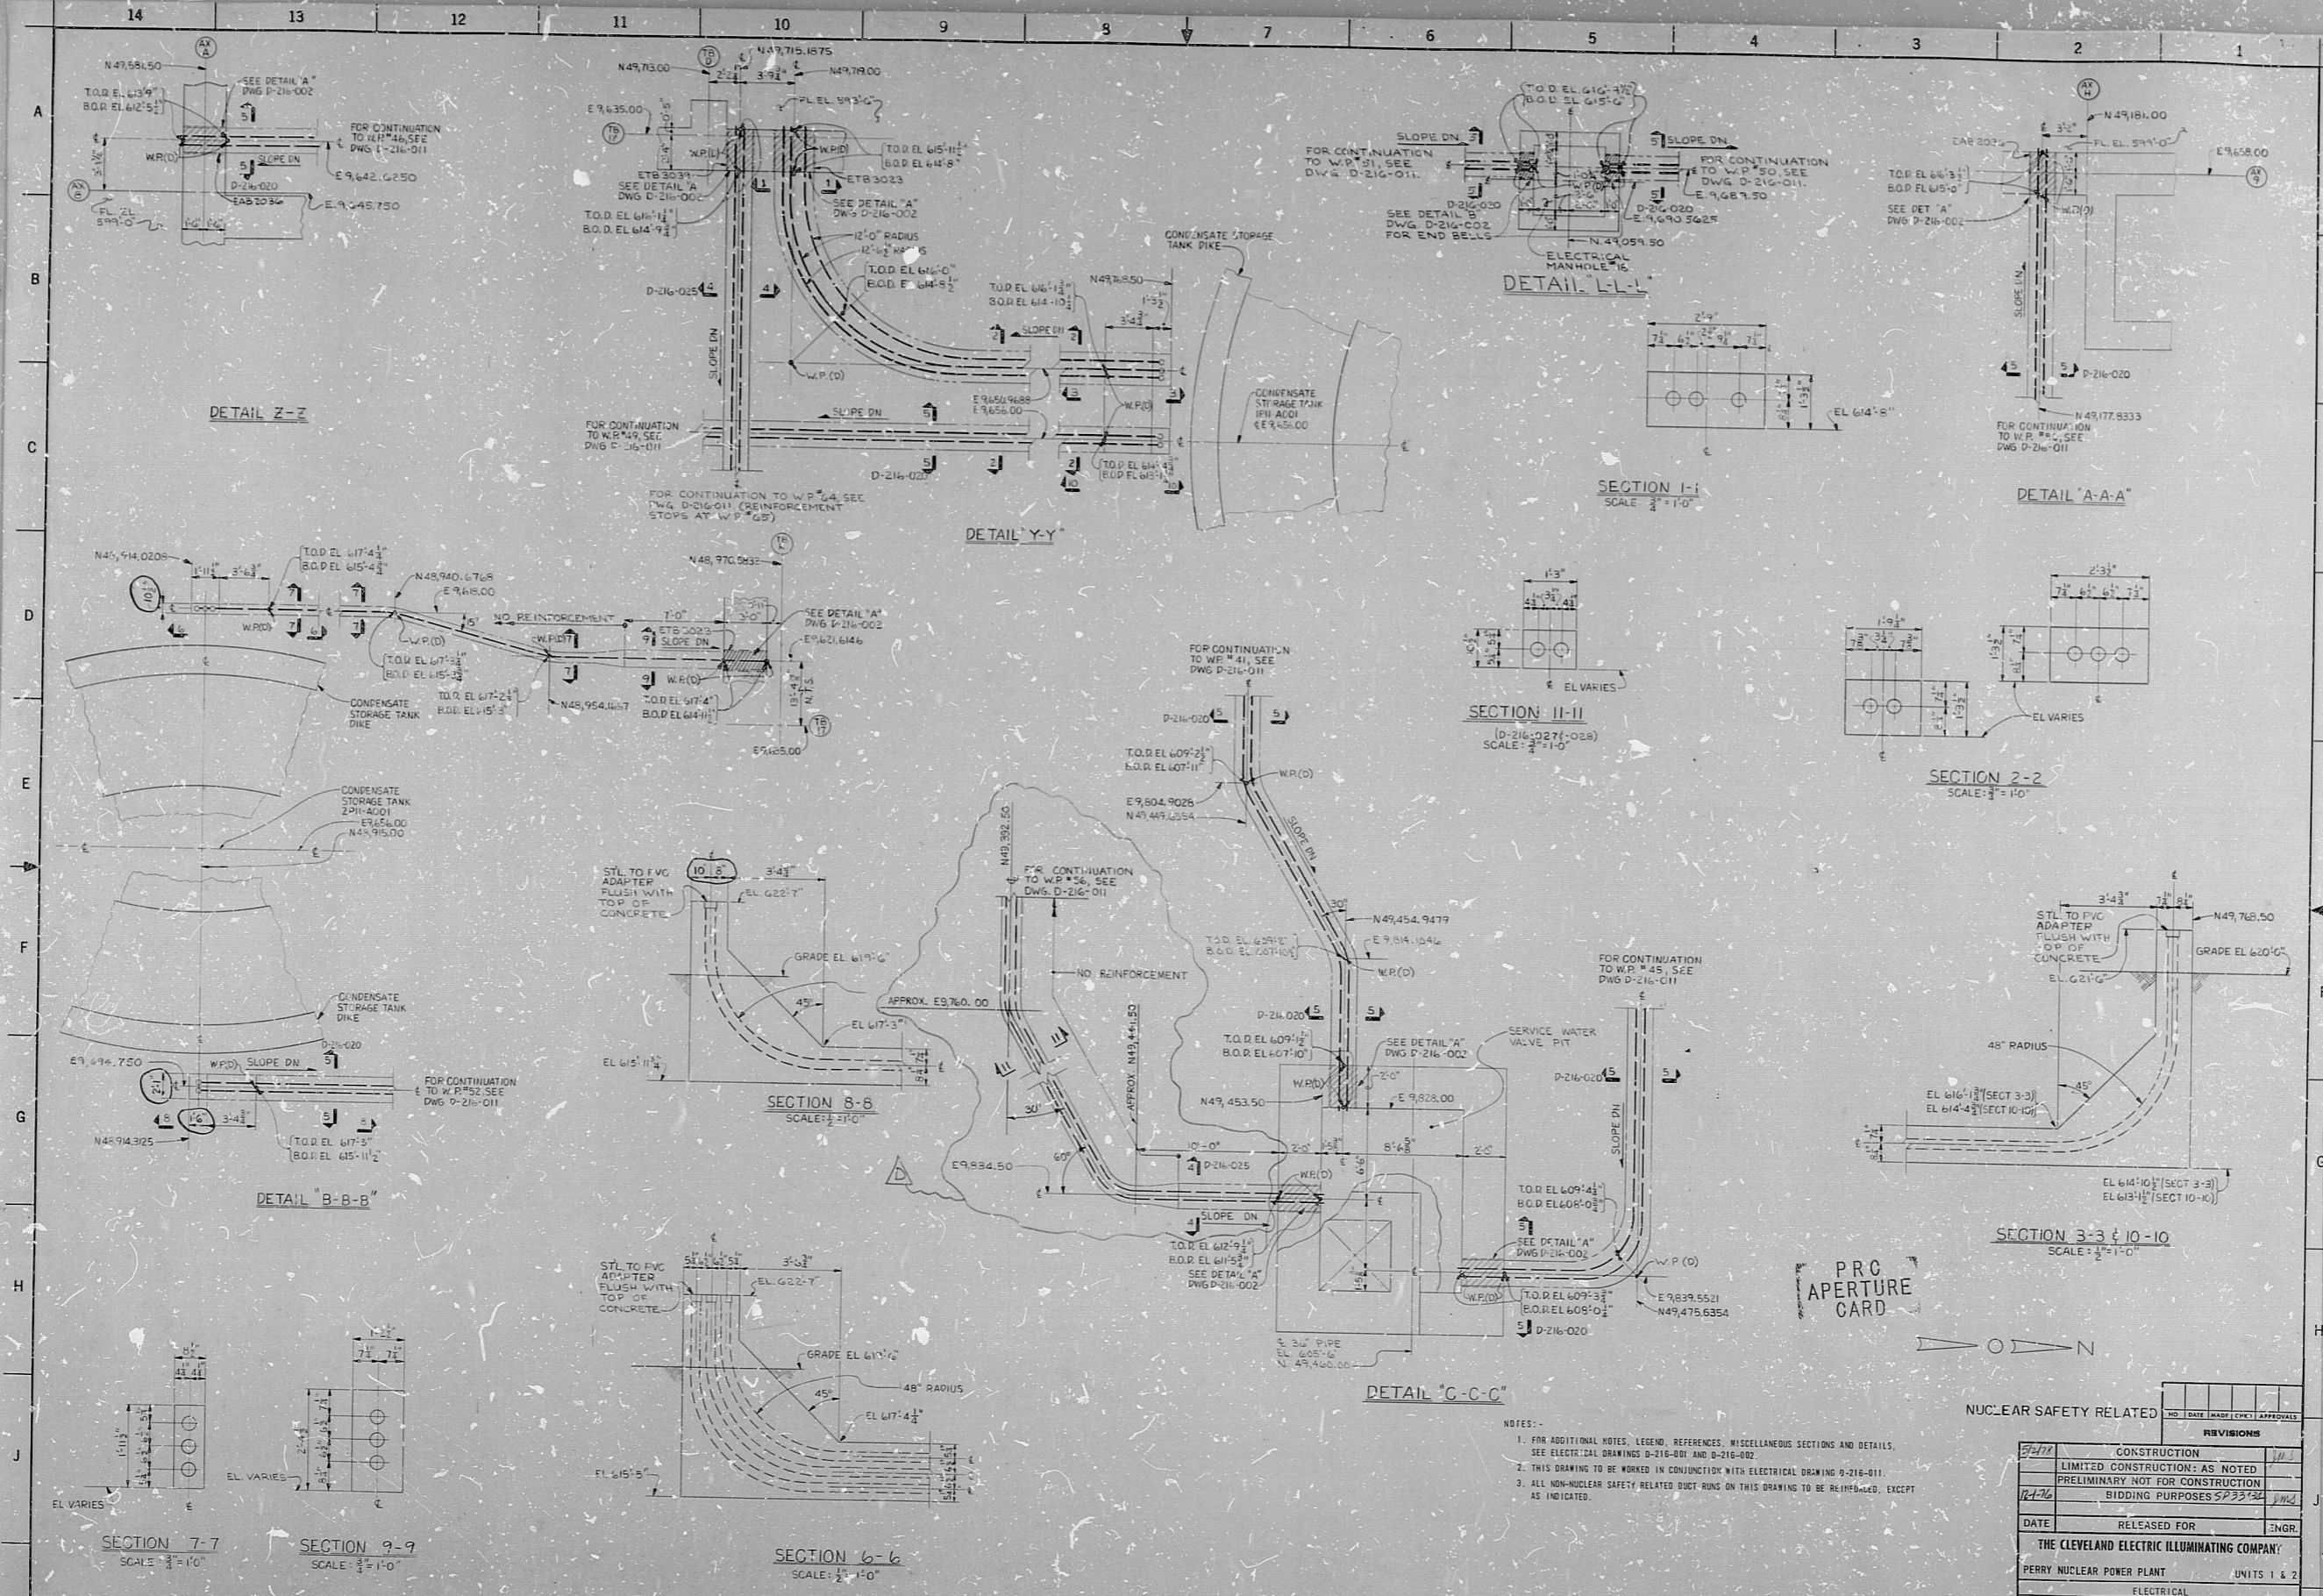

DETAIL Z-Z

DETAIL Y-Y

DETAIL B-B-B

DETAIL C-C-C

SECTION 7-7
SCALE: 1/2" = 1'-0"

SECTION 9-9
SCALE: 1/2" = 1'-0"

SECTION 6-6
SCALE: 1/2" = 1'-0"

SECTION 1-1
SCALE: 1/2" = 1'-0"

DETAIL A-A-A

SECTION 2-2
SCALE: 1/2" = 1'-0"

SECTION 3-3
SCALE: 1/2" = 1'-0"

SECTION 10-10
SCALE: 1/2" = 1'-0"

PRC APERTURE CARD

- NOTES:
- FOR ADDITIONAL NOTES, LEGEND, REFERENCES, MISCELLANEOUS SECTIONS AND DETAILS, SEE ELECTRICAL DRAWINGS D-216-001 AND D-216-002.
 - THIS DRAWING TO BE WORKED IN CONJUNCTION WITH ELECTRICAL DRAWING D-216-011.
 - ALL NON-NUCLEAR SAFETY RELATED DUCT RUNS ON THIS DRAWING TO BE REINFORCED, EXCEPT AS INDICATED.

NUCLEAR SAFETY RELATED

NO.	DATE	BY	CHKD.	APP'D.
5/2/77				
REVISIONS				
5/2/77				
CONSTRUCTION				
LIMITED CONSTRUCTION AS NOTED				
PRELIMINARY NOT FOR CONSTRUCTION				
BIDDING PURPOSES 5/2/77				
DATE RELEASED FOR INGR				
THE CLEVELAND ELECTRIC ILLUMINATING COMPANY				
PERRY NUCLEAR POWER PLANT UNITS 1 & 2				
ELECTRICAL				
UNDERGROUND DUCT RUNS				
MISCELLANEOUS DUCT RUNS EAST SIDE OF PLANT				
DRAWING NO.	GILBERT ASSOCIATES, INC.			
ENGINEER	ENGINEERS AND CONSULTANTS			
DATE	CREATED	ARCHITECTURAL	CIVIL	ELECTRICAL
10/2/76	10/2/76	10/2/76	10/2/76	10/2/76
SCALE	1/2" = 1'-0"	1/2" = 1'-0"	1/2" = 1'-0"	1/2" = 1'-0"
DWG. NO.	04 4549 D-216-028 D			
DRAWING NUMBER				

DATE	10/2/76	10/2/76	10/2/76	10/2/76	10/2/76	10/2/76	10/2/76
BY	W.P.	W.P.	W.P.	W.P.	W.P.	W.P.	W.P.
CHKD.							
APP'D.							
REVISIONS							
1	AS SHOWN						
2	REVISION						
3	REVISION						
4	REVISION						
5	REVISION						
6	REVISION						
7	REVISION						
8	REVISION						
9	REVISION						
10	REVISION						
11	REVISION						
12	REVISION						
13	REVISION						
14	REVISION						
15	REVISION						
16	REVISION						
17	REVISION						
18	REVISION						
19	REVISION						
20	REVISION						
21	REVISION						
22	REVISION						
23	REVISION						
24	REVISION						
25	REVISION						

UNDUCT R UN S DUCT S EAST OF PLANT

RIDS

8212100389

