


SECTION A-A  
(D-226-511)

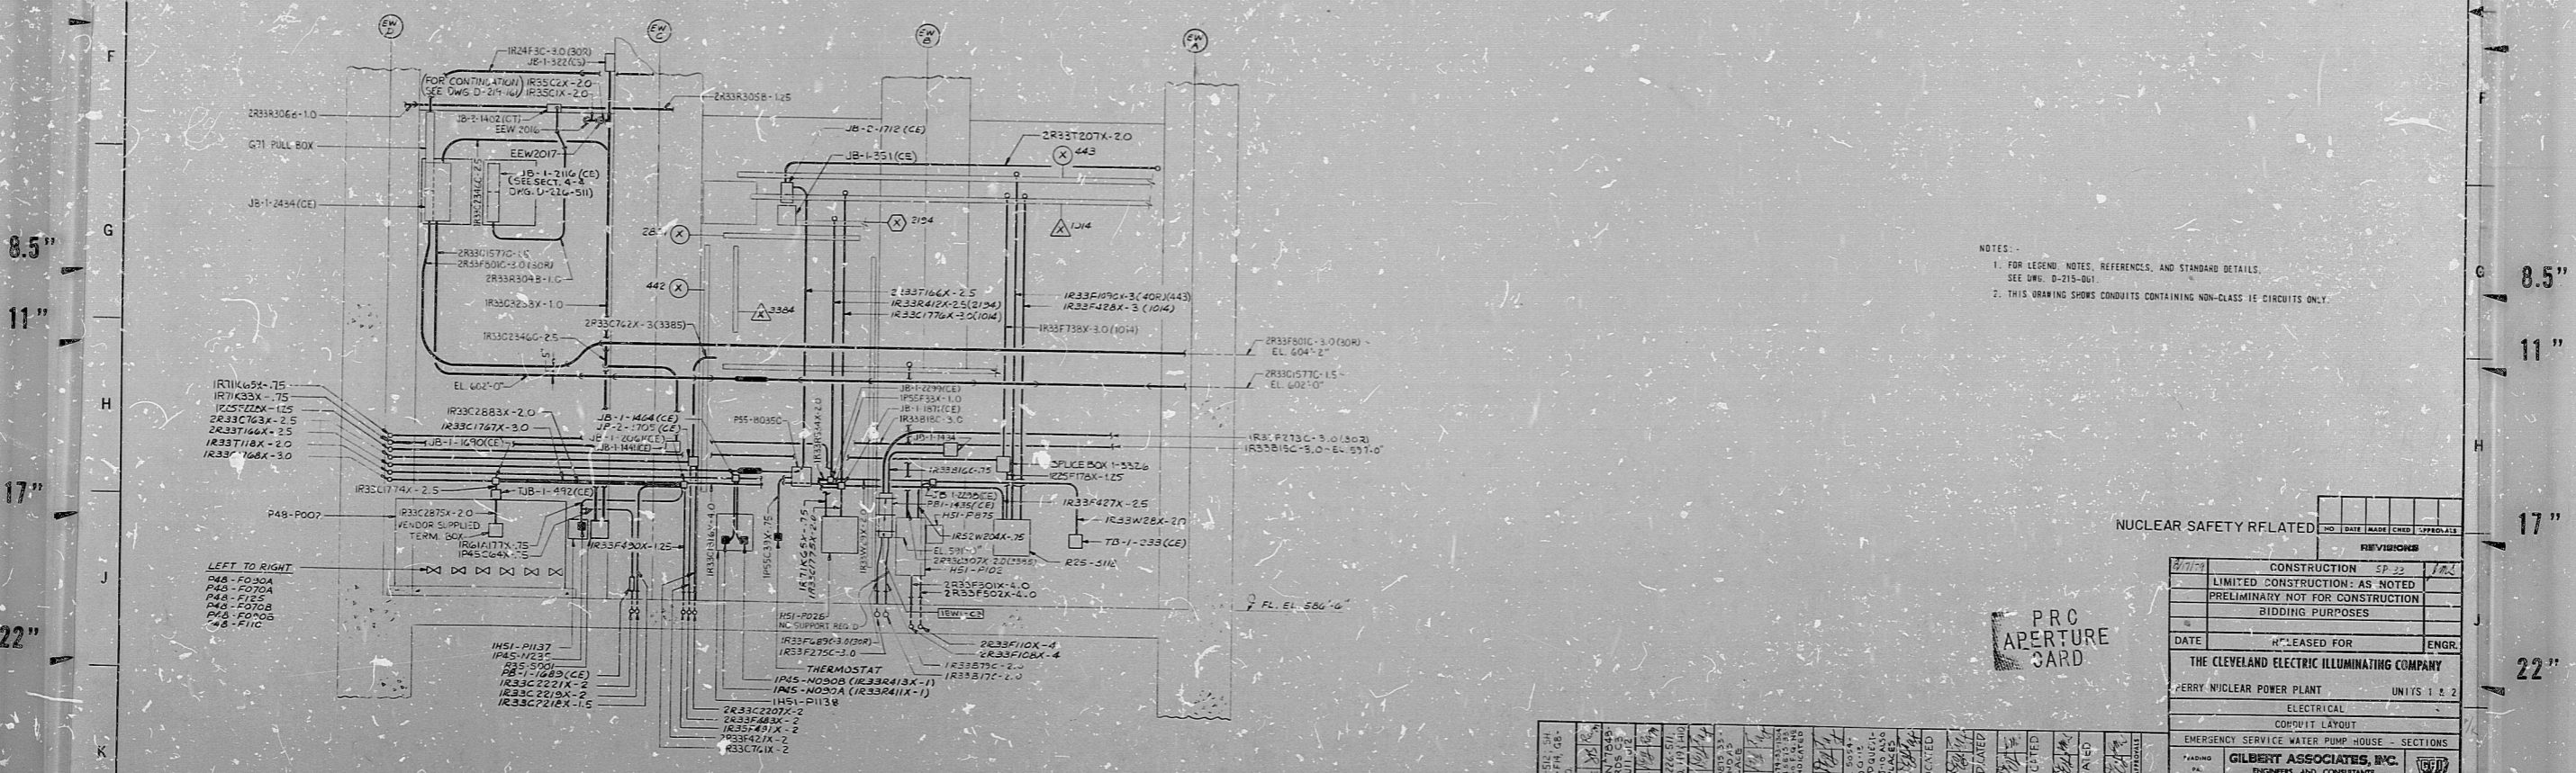

SECTION B-B  
(D-226-511)

NOTES:  
1. FOR LEGEND, NOTES, REFERENCES, AND STANDARD DETAILS, SEE DWG. D-215-001.  
2. THIS DRAWING SHOWS CONDUITS CONTAINING NON-CLASS II CIRCUITS ONLY.

PRC  
APERTURE  
CARD

REVISIONS	
NO.	DESCRIPTION
1	CONSTRUCTION
2	LIMITED CONSTRUCTION: AS NOTED
3	PRELIMINARY NOT FOR CONSTRUCTION BIDDING PURPOSES
4	BIDDING PURPOSES
5	DATE
6	RELEASED FOR
7	ENGR.
THE CLEVELAND ELECTRIC ILLUMINATING COMPANY	
FERRY NUCLEAR POWER PLANT UNITS 1 & 2	
ELECTRICAL LAYOUT	
CONDUIT LAYOUT	
EMERGENCY SERVICE WATER PUMP HOUSE SECTIONS	
DRAWING NO. 04: 4549 D-226-512 K	
DATE 04/27/70	
DRAWING NUMBER	
REV	

NO.	DESCRIPTION	DATE	BY	CHKD	APPROVAL
1	CONSTRUCTION				
2	LIMITED CONSTRUCTION: AS NOTED				
3	PRELIMINARY NOT FOR CONSTRUCTION BIDDING PURPOSES				
4	BIDDING PURPOSES				
5	DATE				
6	RELEASED FOR				
7	ENGR.				
THE CLEVELAND ELECTRIC ILLUMINATING COMPANY					
FERRY NUCLEAR POWER PLANT UNITS 1 & 2					
ELECTRICAL LAYOUT					
CONDUIT LAYOUT					
EMERGENCY SERVICE WATER PUMP HOUSE SECTIONS					
DRAWING NO. 04: 4549 D-226-512 K					
DATE 04/27/70					
DRAWING NUMBER					
REV					

RIDS

8212100416

