


PLAN  
CONDENSATE STORAGE TANK  
UNIT 1

SECTION 1-1

SECTION 2-2

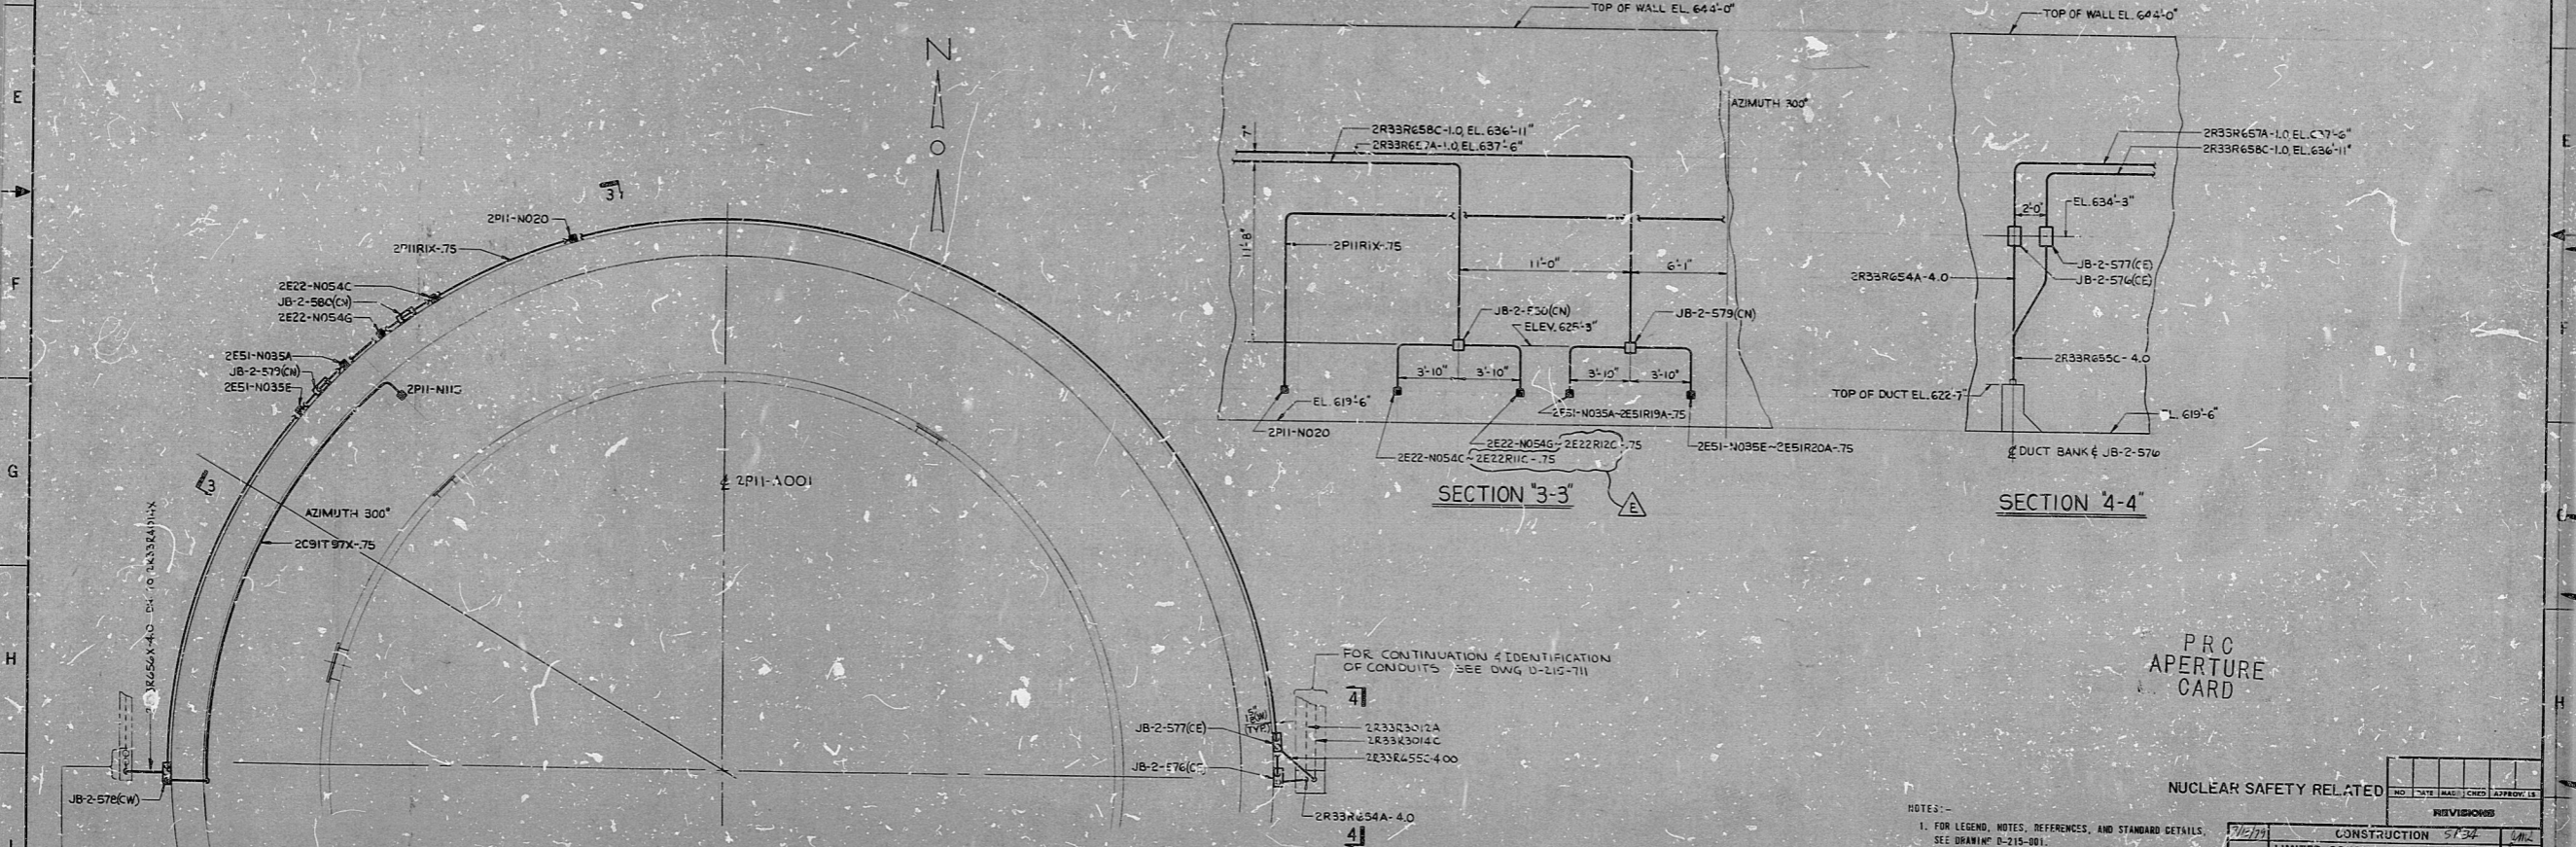

PLAN  
CONDENSATE STORAGE TANK  
UNIT 2

SECTION 3-3

SECTION 4-4

PRC  
APERTURE  
CARD

NUCLEAR SAFETY RELATED

NOTES:  
1. FOR LEGEND, NOTES, REFERENCES, AND STANDARD DETAILS,  
SEE DRAWING D-215-001.

REVISIONS			
NO.	DATE	BY	APPROVED BY
1	5/15/71	[Signature]	[Signature]

DATE	RELEASED FOR	ENGR.
	THE CLEVELAND ELECTRIC ILLUMINATING COMPANY	
	PERRY NUCLEAR POWER PLANT	UNITS 1 & 2
	ELECTRICAL	
	CONDUIT LAYOUT	
	YARD AREA	
DRAWING NO.	D-270-002	REV. E
DRAWING NUMBER		

REVISIONS	DATE	BY	APPROVED BY
REVISED AS IND.			
REVISED AS PER			
REVISED AS INDICATED			
REVISED AS INDICATED			
REVISED AS INDICATED			
REVISED AS INDICATED			
REVISED AS INDICATED			
REVISED AS INDICATED			
REVISED AS INDICATED			

CND L Y T YARD AREA

RIDS

82.2100419

