

32"

34"

22"

22"

17"

17"

11"

11"

8.5"

8.5"

8.5"

8.5"

11"

11"


17"

17"

22"

22"

34"

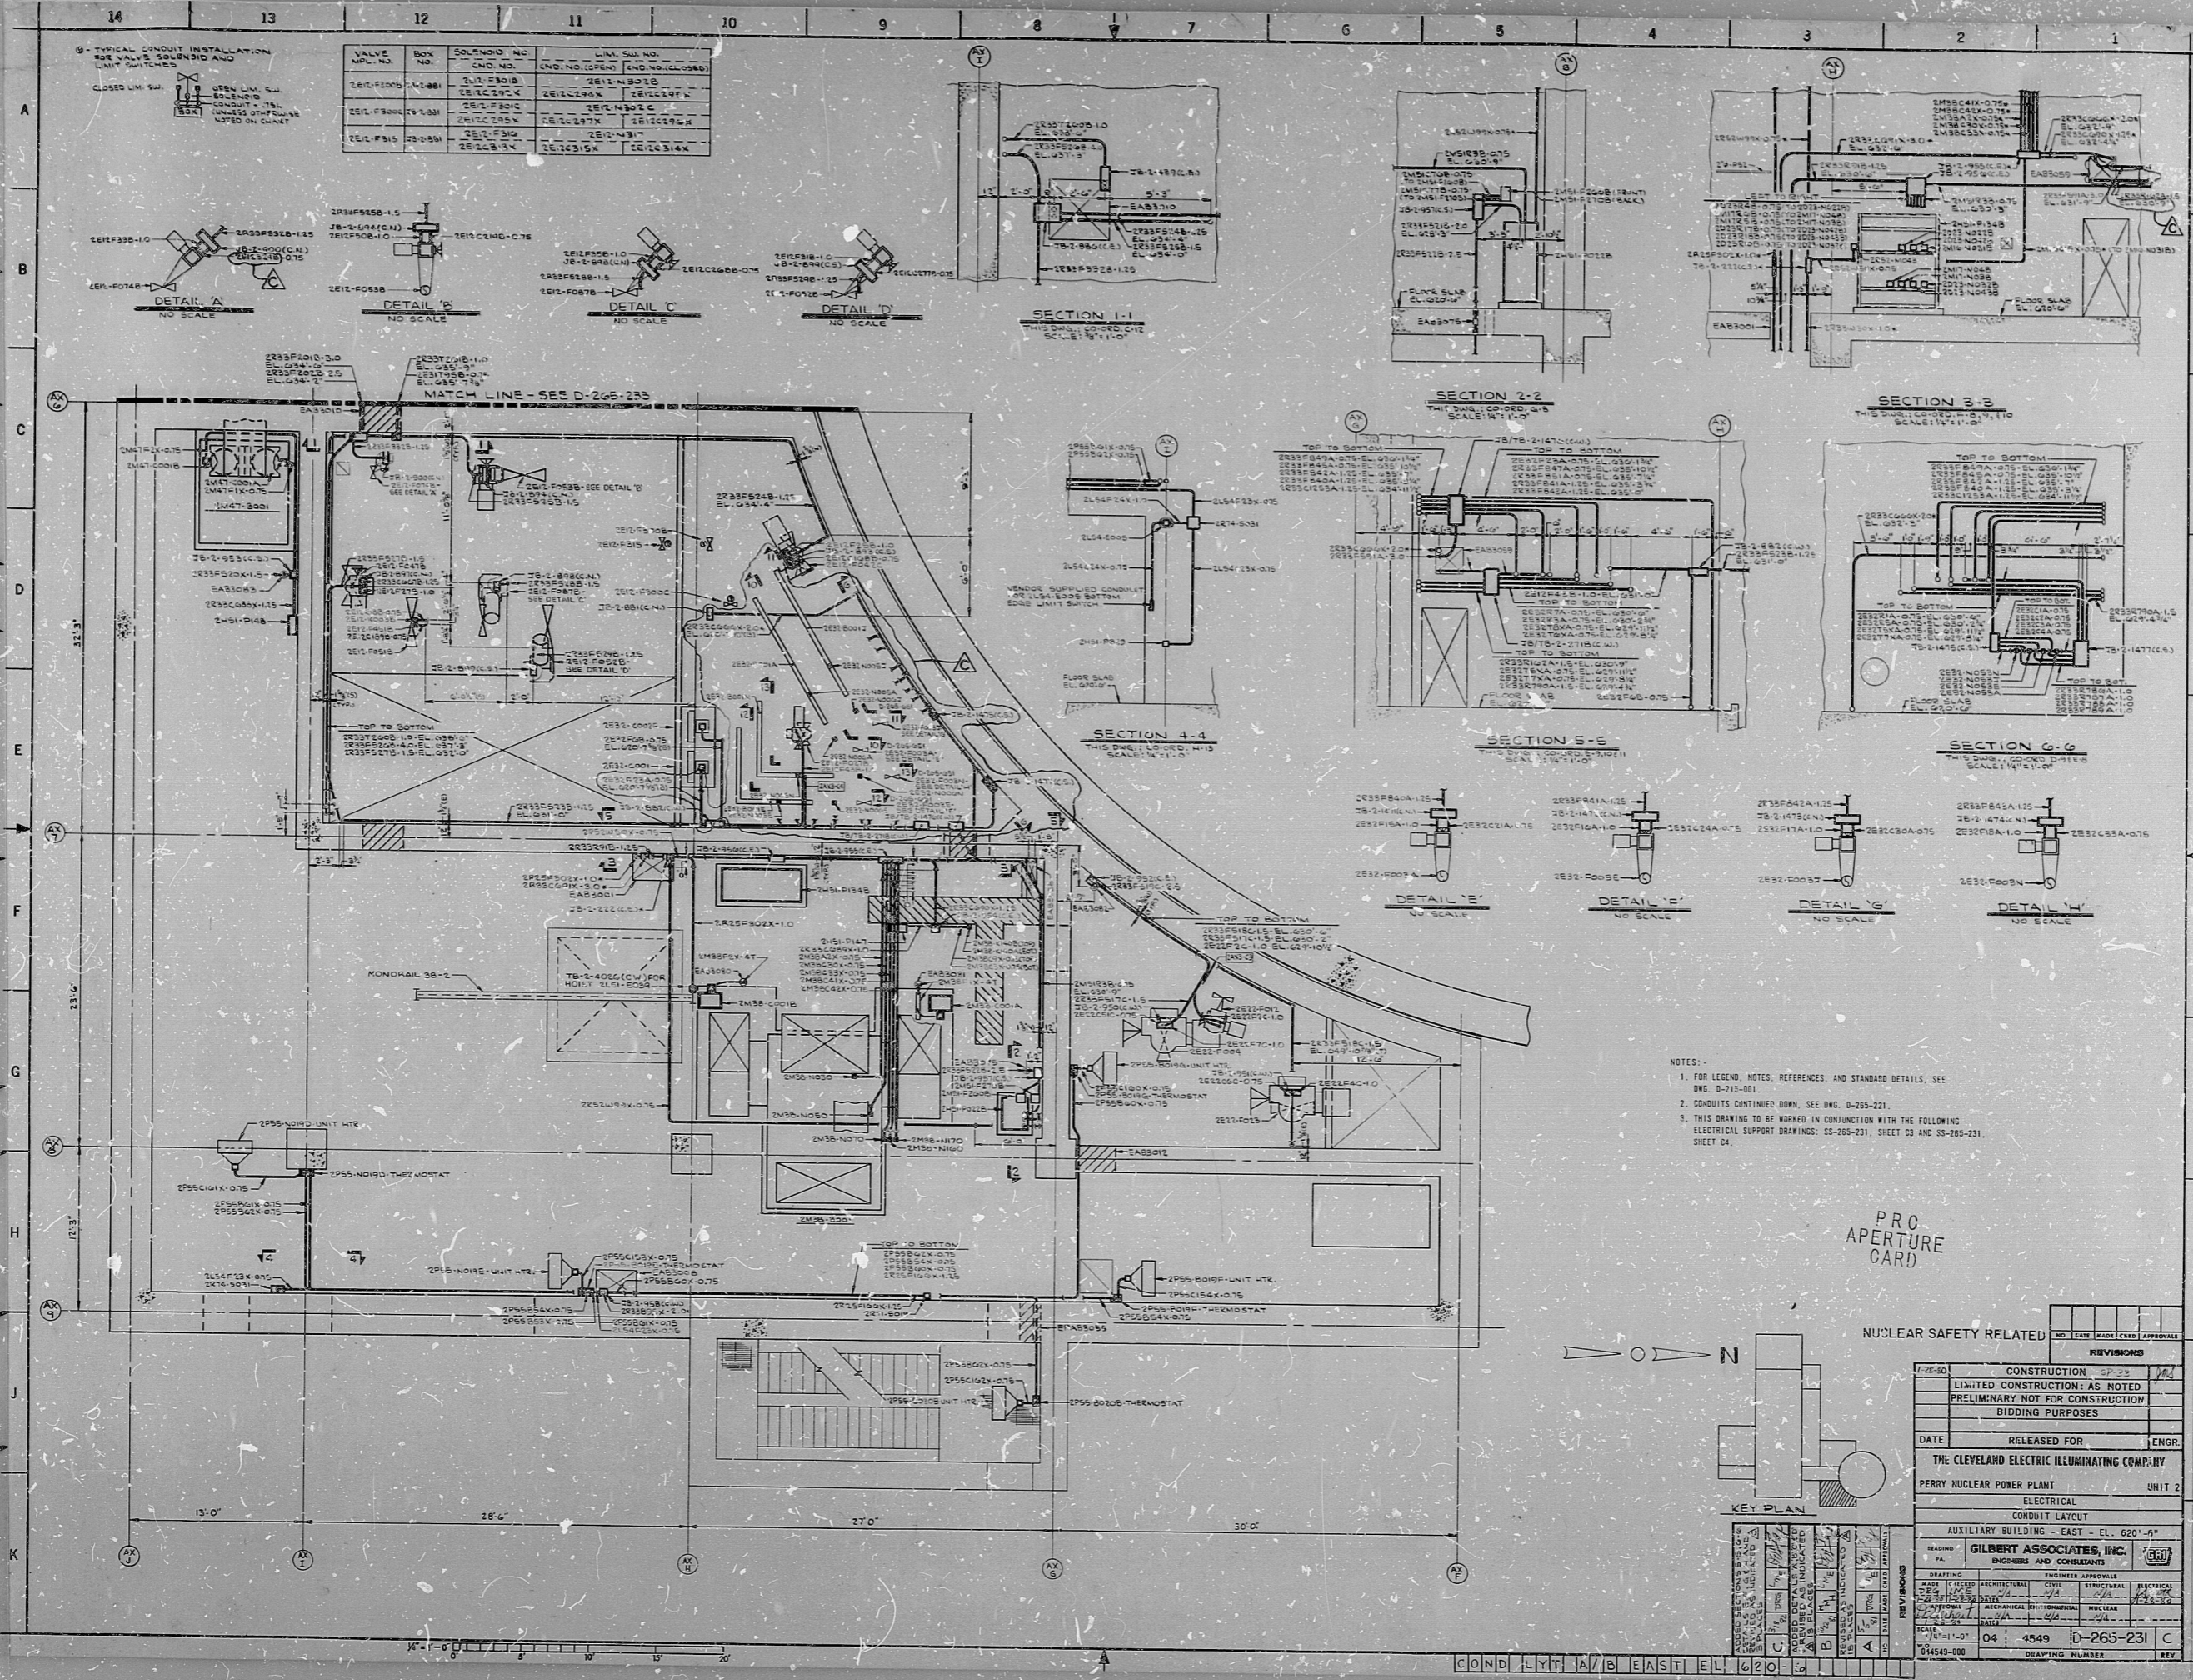

- NOTES:
- FOR LEGEND, NOTES, REFERENCES, AND STANDARD DETAILS, SEE DWG. D-215-001
 - CONDUITS CONTINUED DOWN. SEE DWG. D-265-231
 - THIS DRAWING TO BE WORKED IN CONJUNCTION WITH THE FOLLOWING ELECTRICAL SUPPORT DRAWINGS: SS-395-231, SHEET C3 AND SS-265-231, SHEET D4.

PRC
APERTURE
CARD

REVISIONS	
1	CONSTRUCTION OF P-23
2	LIMITED CONSTRUCTION AS NOTED
3	PRELIMINARY NOT FOR CONSTRUCTION
4	BIDDING PURPOSES
DATE	RELEASED FOR ENGR.
THE CLEVELAND ELECTRIC ILLUMINATING COMPANY	
PERRY NUCLEAR POWER PLANT UNIT 2	
ELECTRICAL	
CONDUIT LAYOUT	
AUXILIARY BUILDING - EAST - EL. 620'-0"	
GILBERT ASSOCIATES, INC.	
ENGINEERS AND CONSULTANTS	
MADE BY	ARCHITECTURAL
CHECKED BY	CIVIL
DESIGNED BY	ELECTRICAL
APPROVED BY	MECHANICAL
SCALE	AS SHOWN
DATE	04 4549 D-265-231 C
SCALE	1/8" = 1'-0"
DATE	04-10-60

82.2100498

RIDS

