


DIVISIONAL DC POWER DISTRIBUTION
PANEL P669

ALL WIRING UNLESS OTHERWISE INDICATED ON THIS SHEET.

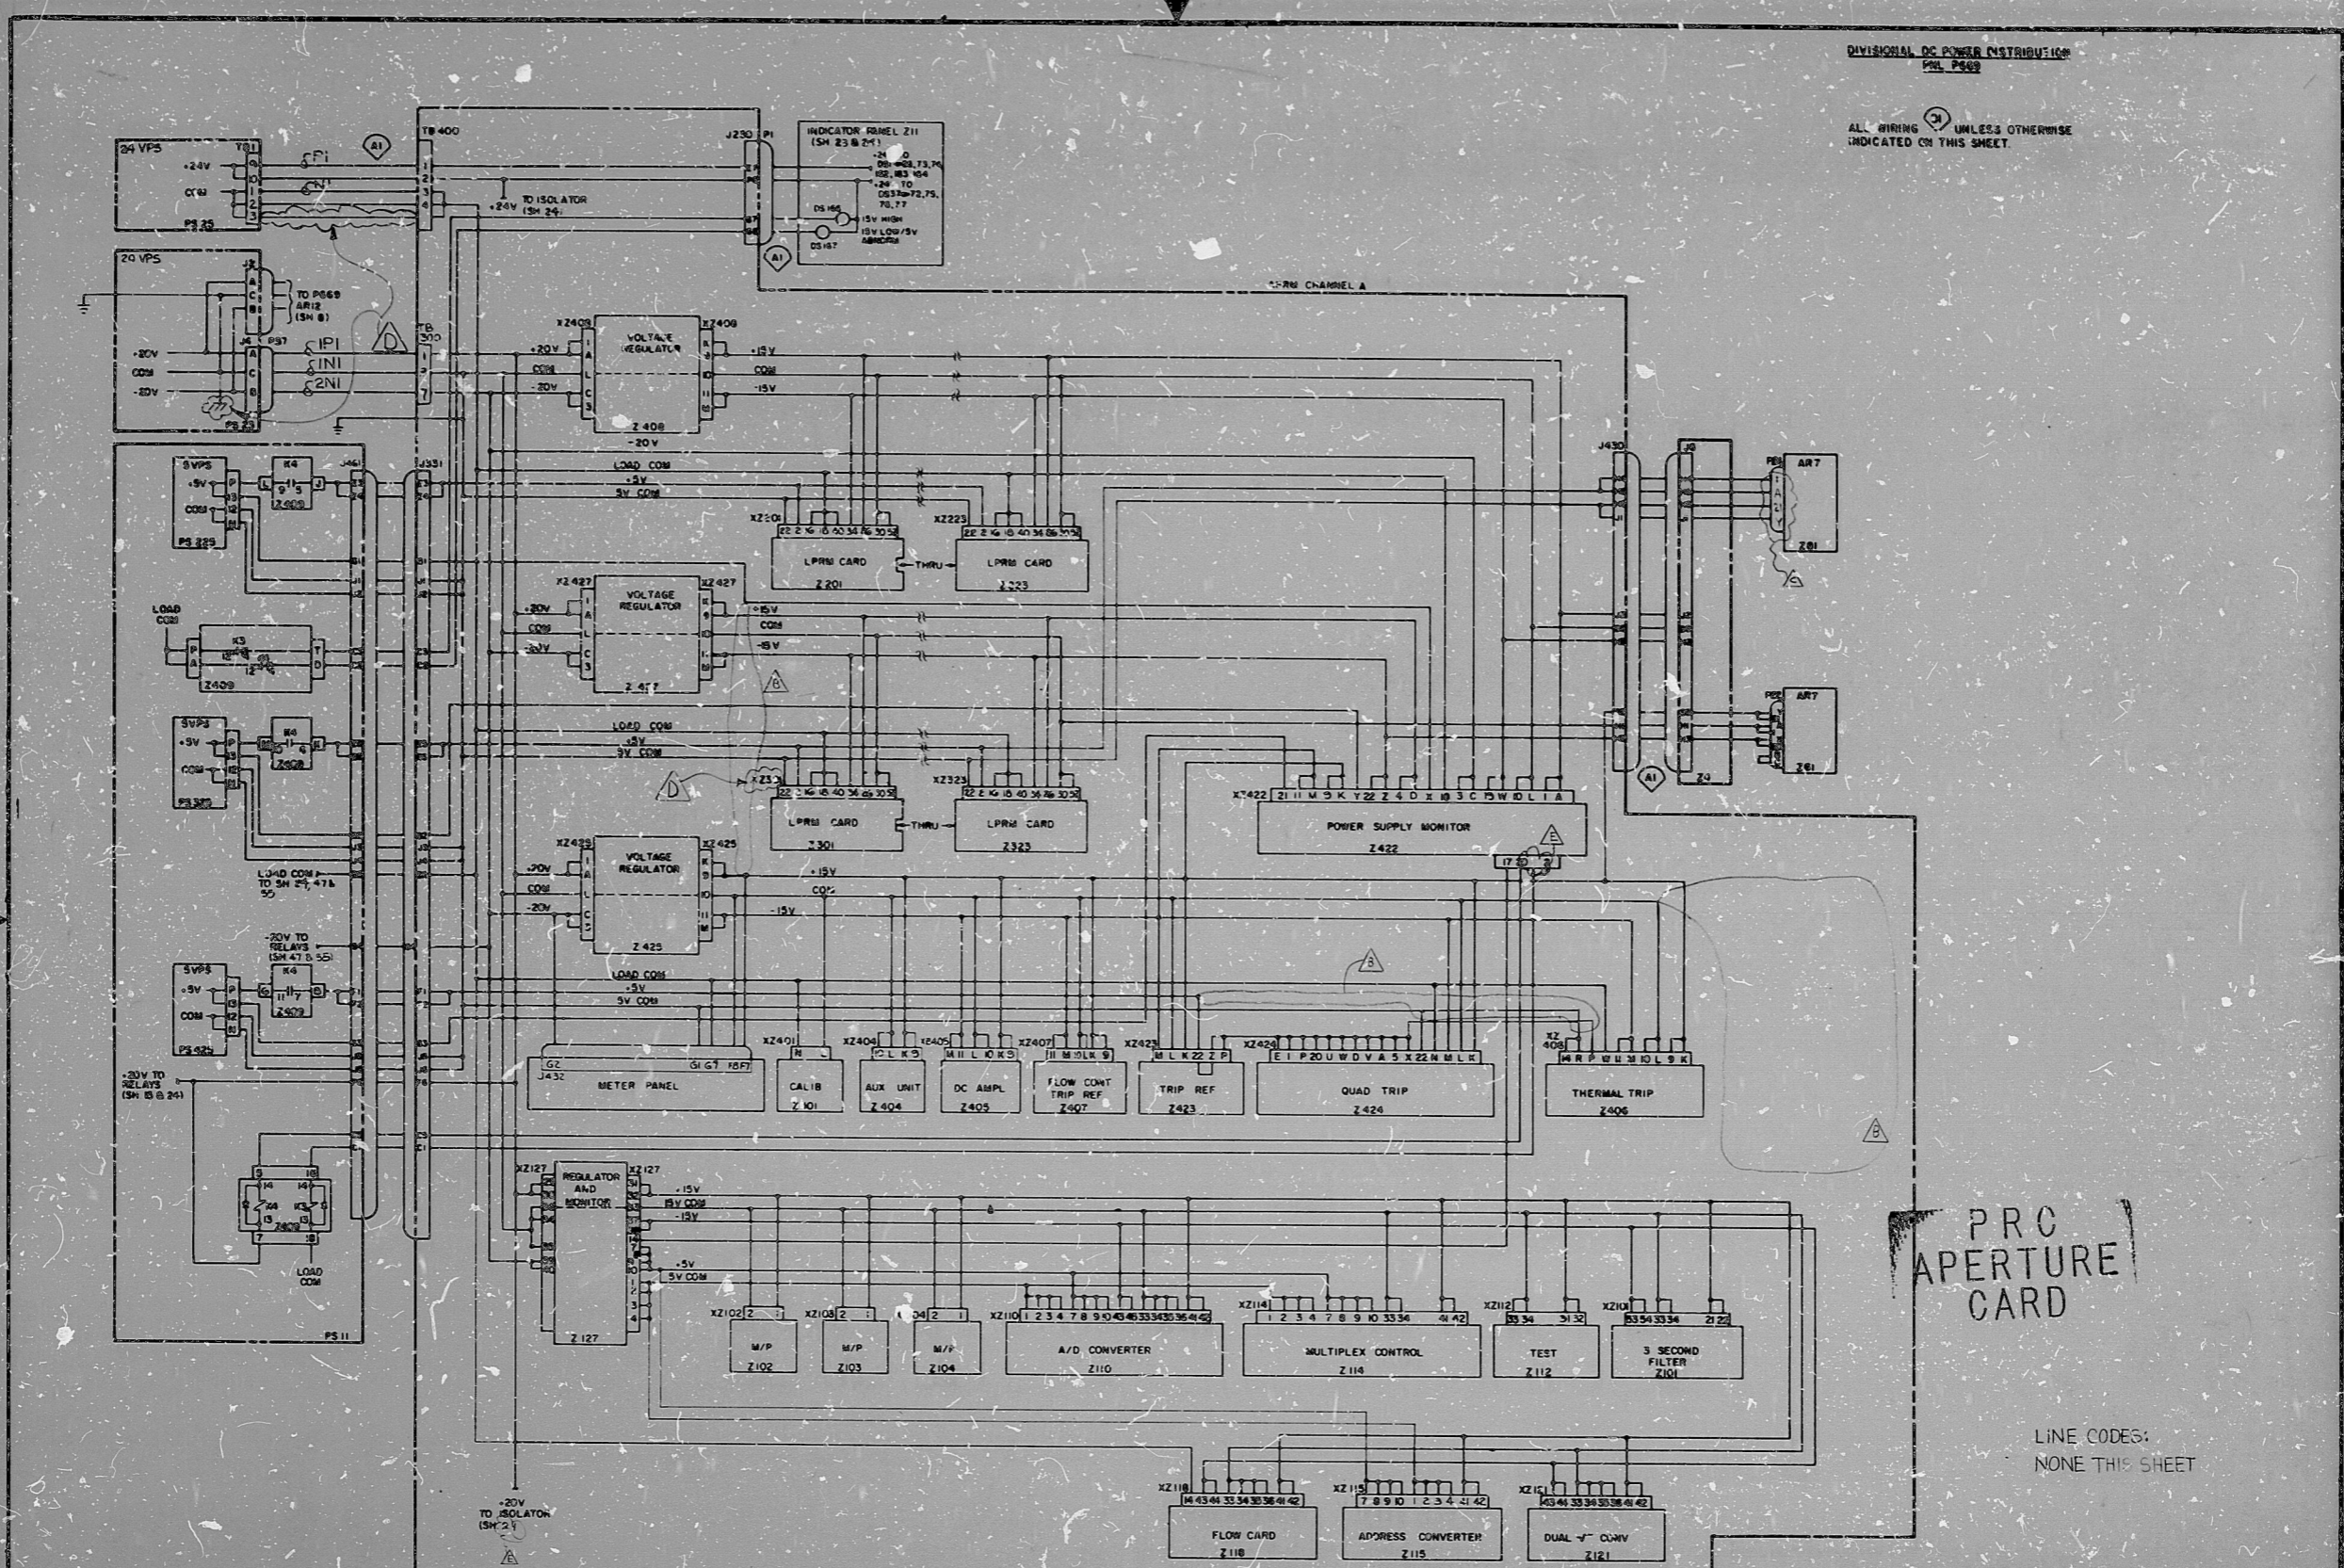

PRC APERTURE CARD

LINE CODES:
NONE THIS SHEET

NUCLEAR SAFETY RELATED

THE CLEVELAND ELECTRIC ILLUMINATING CO.

PERRY NUCLEAR POWER PLANT UNIT 1

ELECTRICAL-ELEMENTARY DIAGRAM

POWER RANGE NEUTRON MONITORING SYSTEM

DC-POWER DISTRIBUTION PANEL 1H13-669

GENERAL ELECTRIC
POWER RANGE NEUTRON MON. SYS.
REV. 1

9-1-77
CONSTRUCTION
PRELIMINARY
DATE RELEASED FOR ENGR.

GILBERT ASSOCIATES, INC.
ENGINEERS AND CONSULTANTS

REVISE PERGE DRAWING REV 9	REVISED PER GE REV 8	CHANGED PLUG DESIGNAT	DELETED LPRM AVG CARD Z402 & 403 A WIRE BETWEEN Z427 & 425 CHANGED CONNECT BETWEEN Z424 & 406 & 423	REDRAWN PER GE REVISION 6	READING PA.
E SLM TAM DEG RAM 7/19/82	D PV TAM DEG RAM 12/21/81	C YZ TAM DEG RAM 4-11-81	B YZ TAM DEG RAM 11/7/80	A CAM TAM DEG RAM 1-30-80	04549-000
REV MADE CHKD APPROVALS DATE	REV MADE CHKD APPROVALS DATE	REV MADE CHKD APPROVALS DATE	REV MADE CHKD APPROVALS DATE	REV MADE CHKD APPROVALS DATE	WORK ORDER MADE CHKD DR APP ENG APP DATE

04	4549	B-208-038	C51	B07	E
DRAWING NUMBER			SYSTEM SH. NG. REV.		

ELEM DIAG 1C51B DC PWR 1H13-P669

Rids

8212140102

