


DIVISIONAL DC POWER DISTRIBUTION
PANEL P669

ALL WIRING UNLESS OTHERWISE
INDICATED ON THIS SHEET.

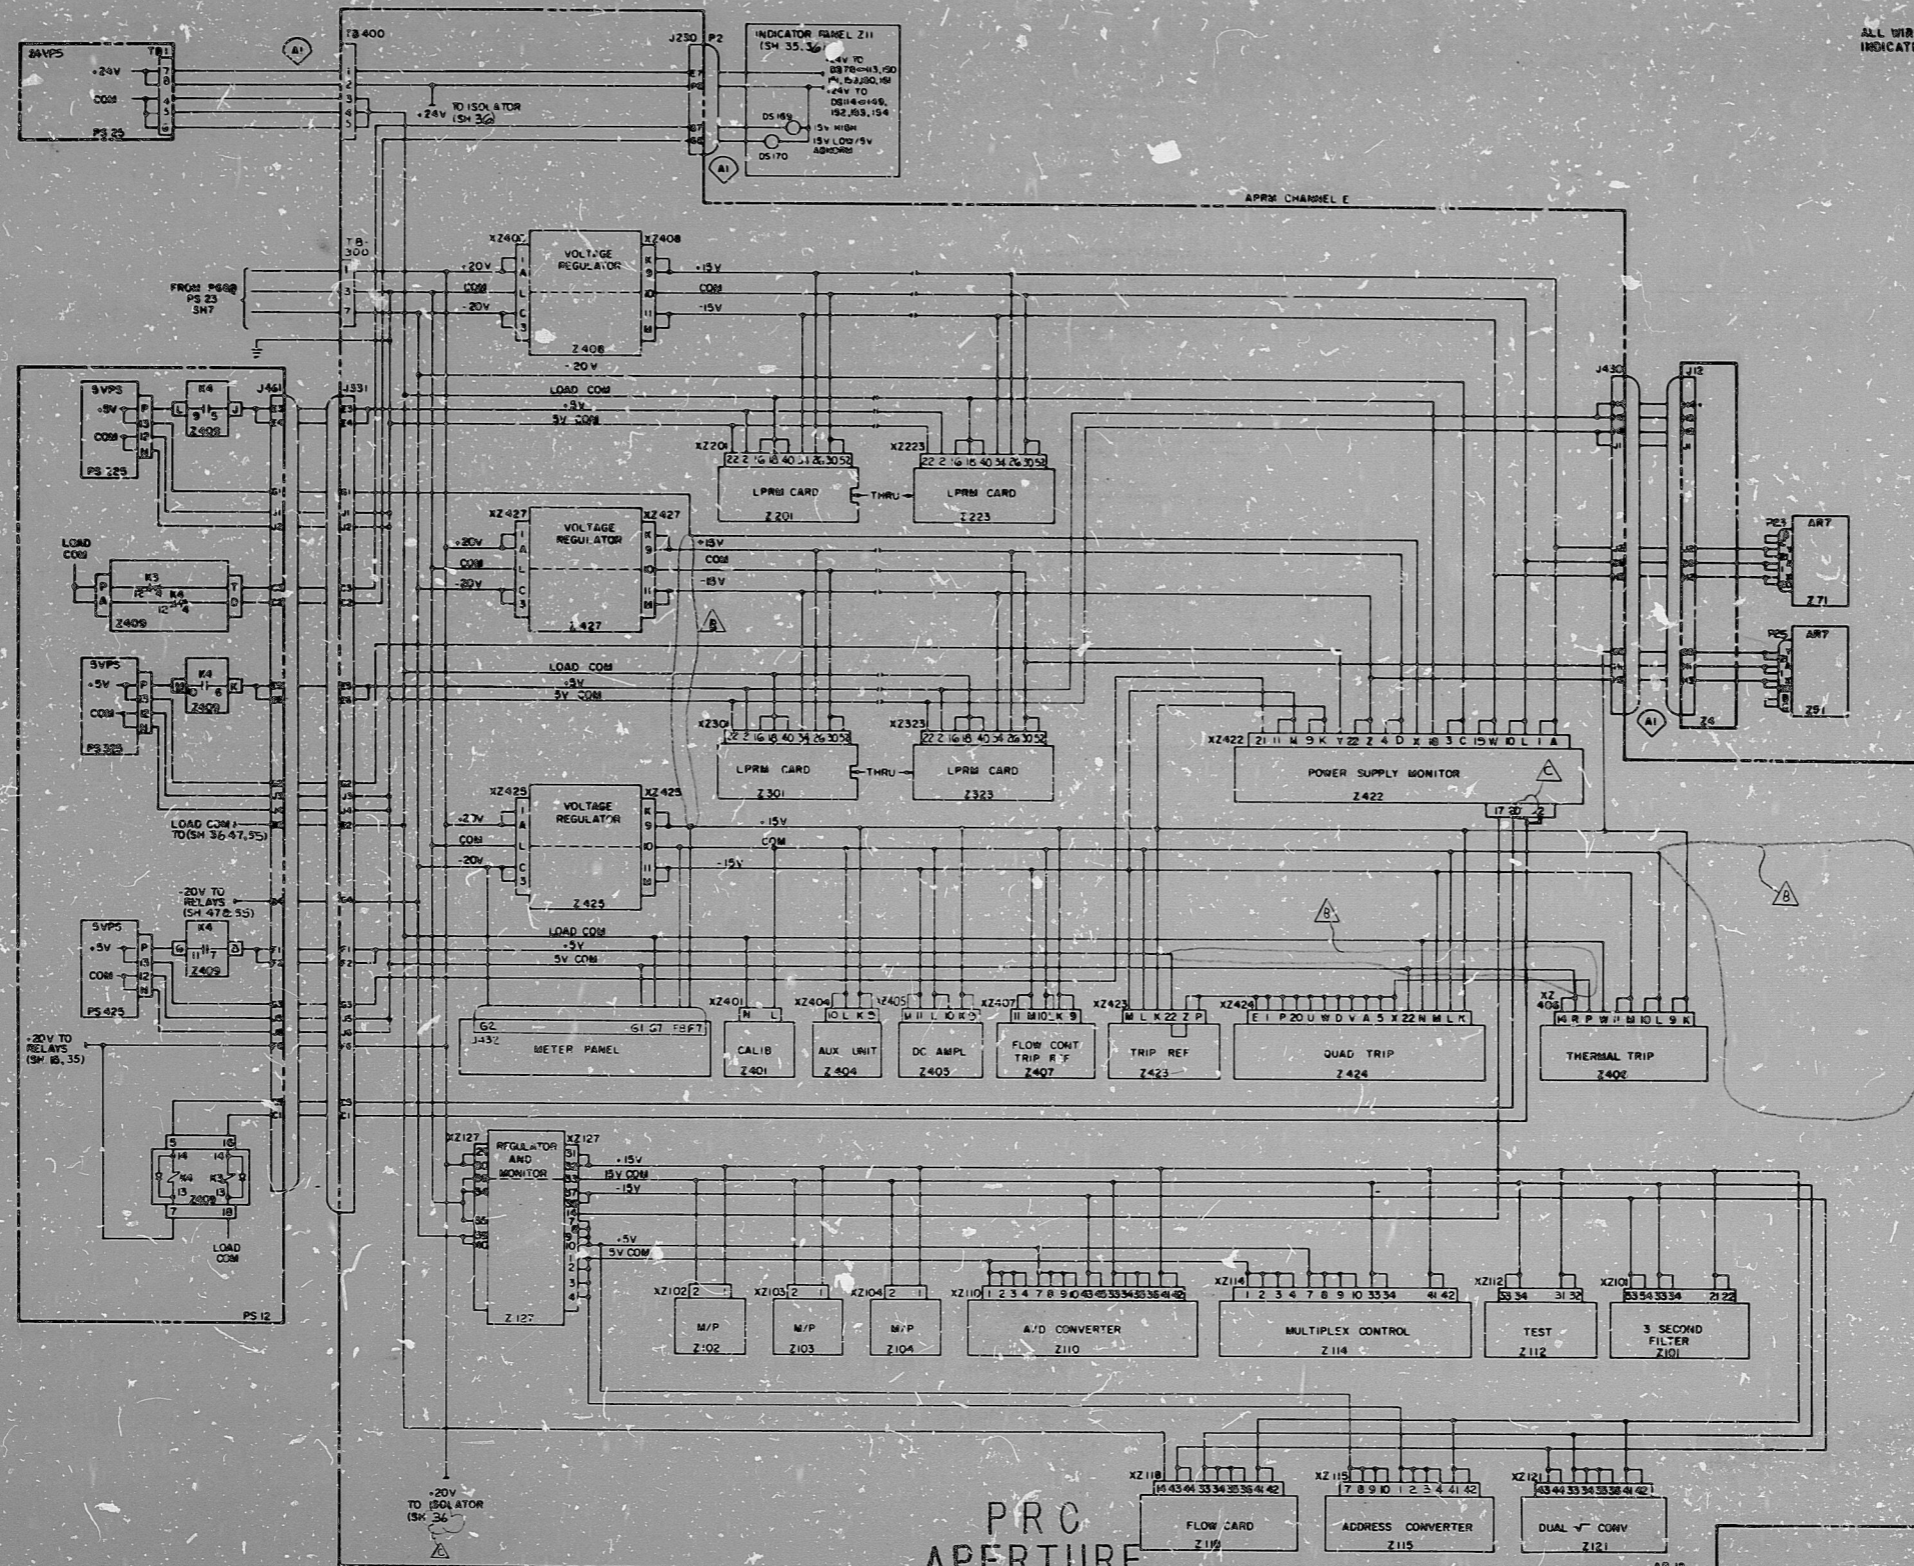

PRC
APERTURE
CARD

NUCLEAR SAFETY RELATED
THE CLEVELAND ELECTRIC ILLUMINATING CO.

PERRY NUCLEAR POWER PLANT UNIT 1
ELECTRICAL-ELEMENTARY DIAGRAM

POWER RANGE NEUTRON MONITORING SYSTEM
DC POWER DISTRIBUTION - PANEL 1H13-P669

GENERAL ELECTRIC
ELEM DIAG
POWER RANGE NEUTRON MON SYS
REV 9

9-7-77	CONSTRUCTION	2/70
	PRELIMINARY	
	RELEASED FOR ENGR.	

REVISED PER GE DRAWING REV 9
 CHANGED CONNECTION BETWEEN WIRE
 Z426 DELETED Z402 & Z403 WIRE
 BETWEEN Z427 & Z425
 REDRAWN PER GE REVISION 6

READING PA
 GILBERT ASSOCIATES, INC.
 ENGINEERS AND CONSULTANTS

REV	MADE	CHKD	APPROVALS	DATE	REV	MADE	CHKD	APPROVALS	DATE	REV	MADE	CHKD	APPROVALS	DATE	REV	MADE	CHKD	APPROVALS	DATE	WORK ORDER	MADE	CHKD	DR. APP.	ENG. APP.	DATE	DRAWING NUMBER	SYSTEM	SH. NO.	REV.						
	C	SLM	FAM	DEG	RAM	11/1/82		B	Y	Z	R	DEG	RAM	11/1/80		A	CAM	TRAM	DEG	RAM	1-30-80	044549-000		C	IC	RAM	DEG	TFE	8-24-77	04	4549	B-205-038	C51	B08	C

ELEM DIAG 1C51B DC PWR 1H13-P669

17
11
8.5
8.5
11
17

Rids

82.1214 0104

