


DIVISIONAL DC POWER DISTRIBUTION
PANEL P670

ALL WIRING UNLESS OTHERWISE INDICATED ON THIS SHEET.

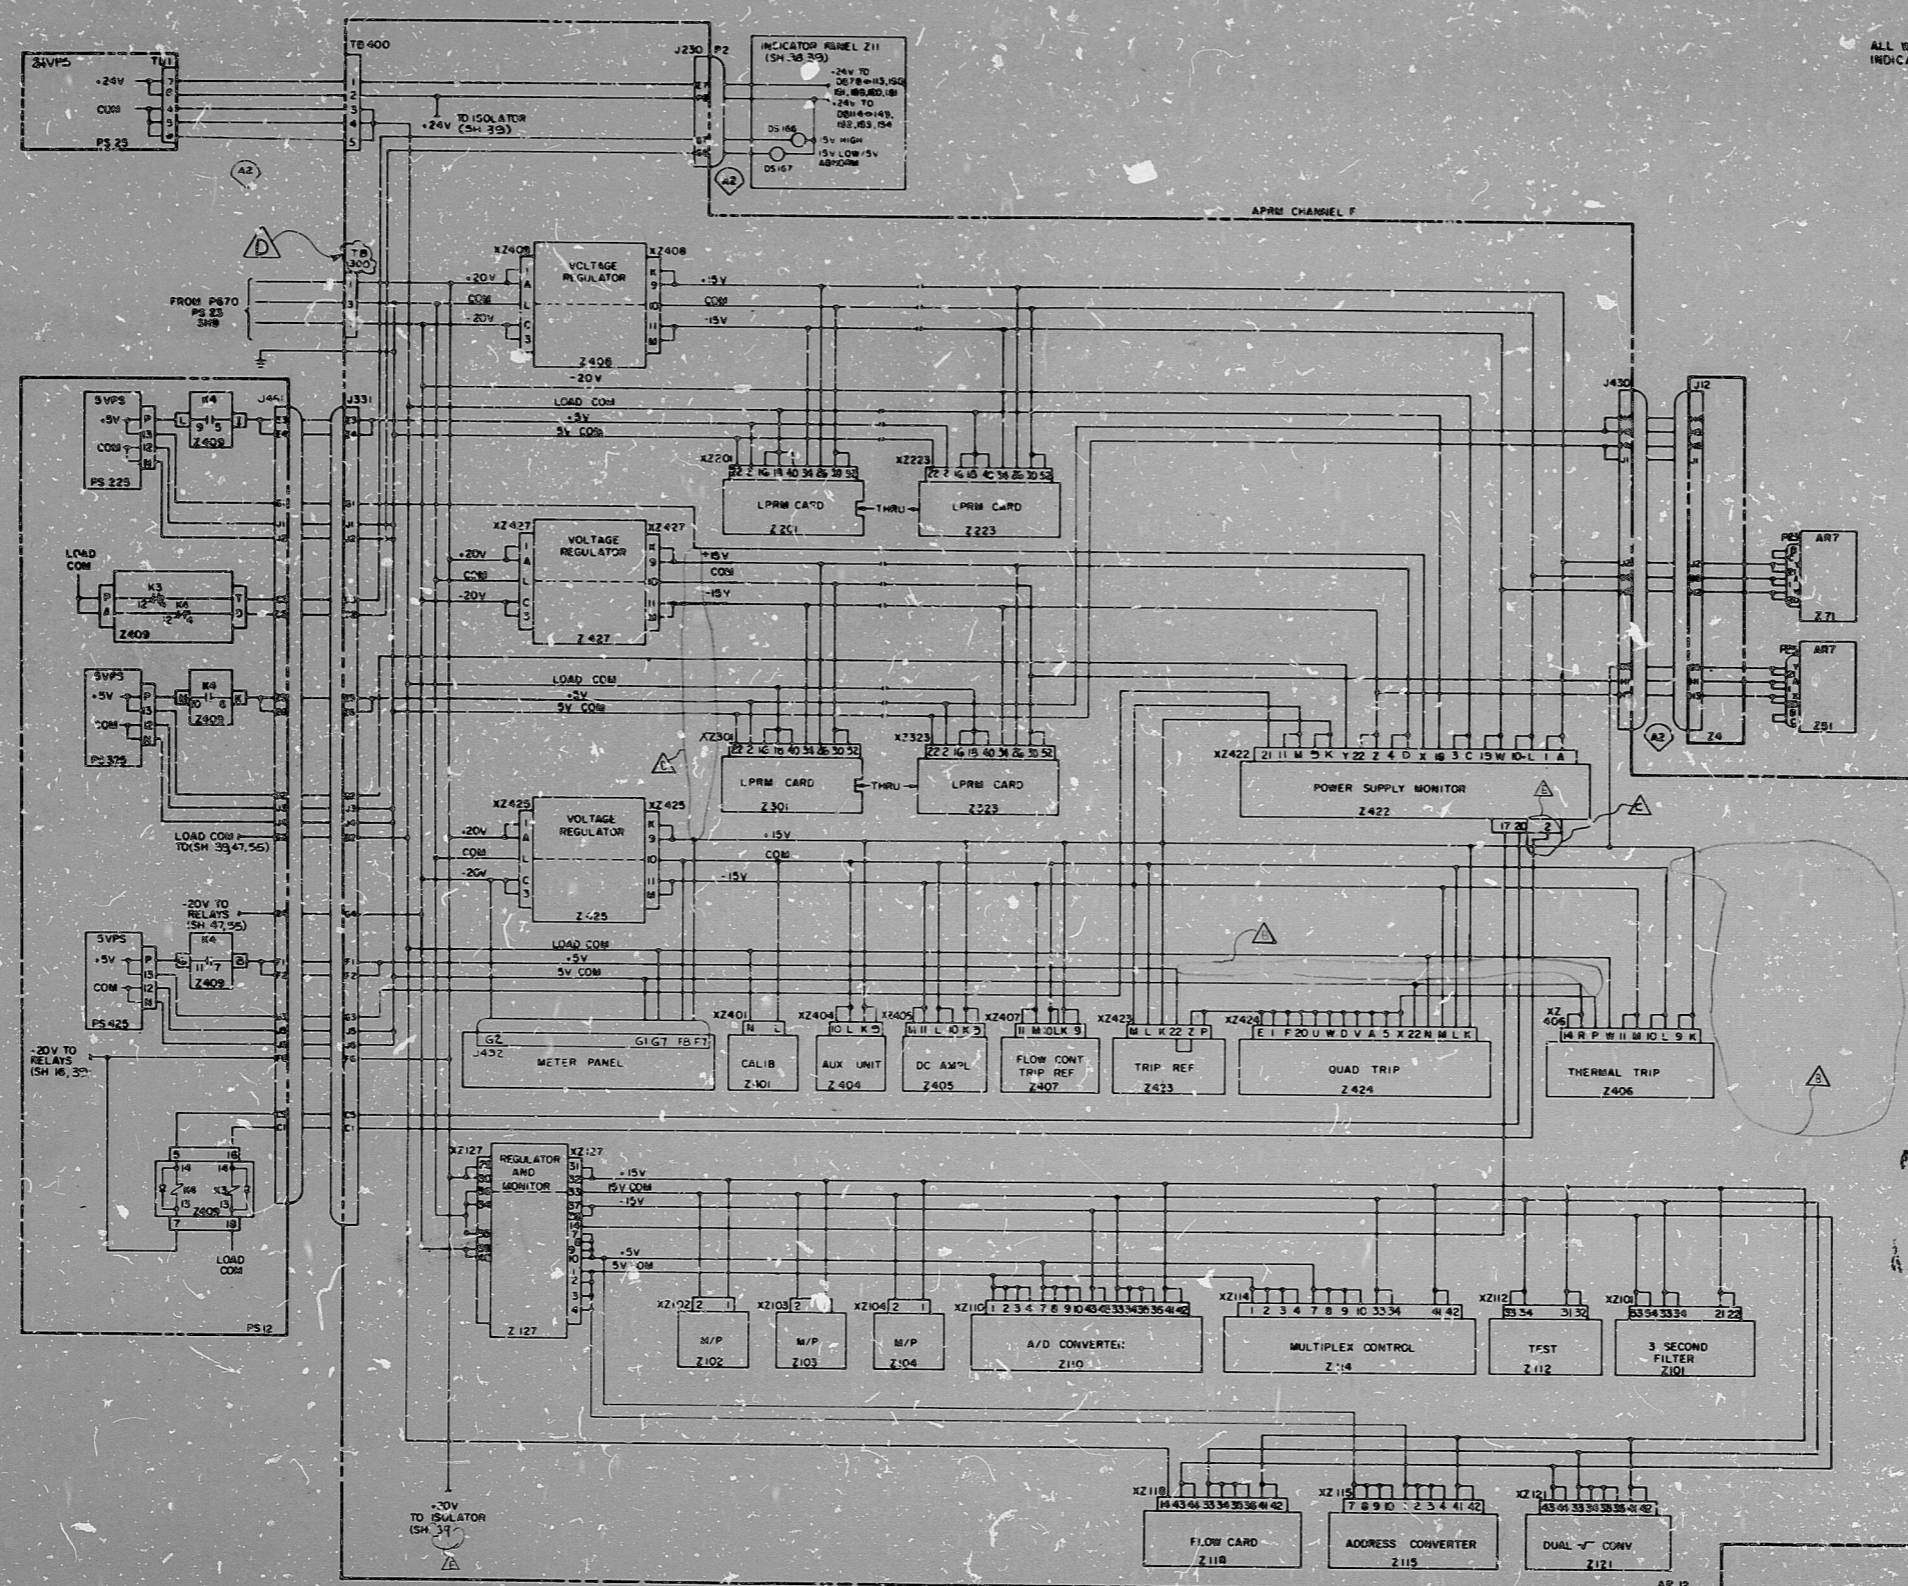

PRC APERTURE CARD

LINE CODES:
NONE THIS SHEET

NUCLEAR SAFETY RELATED

THE CLEVELAND ELECTRIC ILLUMINATING CO.

PERRY NUCLEAR POWER PLANT UNIT 1

ELECTRICAL-ELEMENTARY DIAGRAM

POWER RANGE NEUTRON MONITORING SYSTEM

DC-POWER DISTRIBUTION-PANEL P670

REVISE PERGE DRAWING REV 4		REVISED TB DESIGN PER GE REV 8		DELETED WIRE BETWEEN B & 2 (Z422)		DELETED LPRM AVG CARD Z1025 Z403 & WIRE BETWEEN Z425 & Z427 CHANGE CONNECT BETWEEN Z424 & Z406		REDRAWN PER GE REVISION G		READING PA.		GILBERT ASSOCIATES, INC. ENGINEERS AND CONSULTANTS		DATE RELEASED FOR ENGR.		DRAWING NUMBER		SYSTEM SH. NO. REV.																										
E	SLM	TAM	DEC	RAM	7/17/82	D	P	TAM	DEC	RAM	12/21/81	C	Y	Z	RAM	4-11-81	B	Y	Z	RAM	11/1/80	A	CAM	RAM	DEC	RAM	1-30-80	044549-000	B	Z	RAM	DEC	TFF	3-24-77	04	4549	B-203-038	C51	B10	E				
REV	MADE	CHKD	APPROVALS	DATE	REV	MADE	CHKD	APPROVALS	DATE	REV	MADE	CHKD	APPROVALS	DATE	REV	MADE	CHKD	APPROVALS	DATE	REV	MADE	CHKD	APPROVALS	DATE	REV	MADE	CHKD	APPROVALS	DATE	REV	MADE	CHKD	APPROVALS	DATE	REV	MADE	CHKD	APPROVALS	DATE	REV	MADE	CHKD	APPROVALS	DATE
ELEM DIAG DC PWR DIST PNL 1H13P670																																												

Rids

82.12140110

