


DIVISIONAL DC POWER DISTRIBUTION  
PANEL P672

ALL WIRING UNLESS OTHERWISE INDICATED ON THIS SHEET

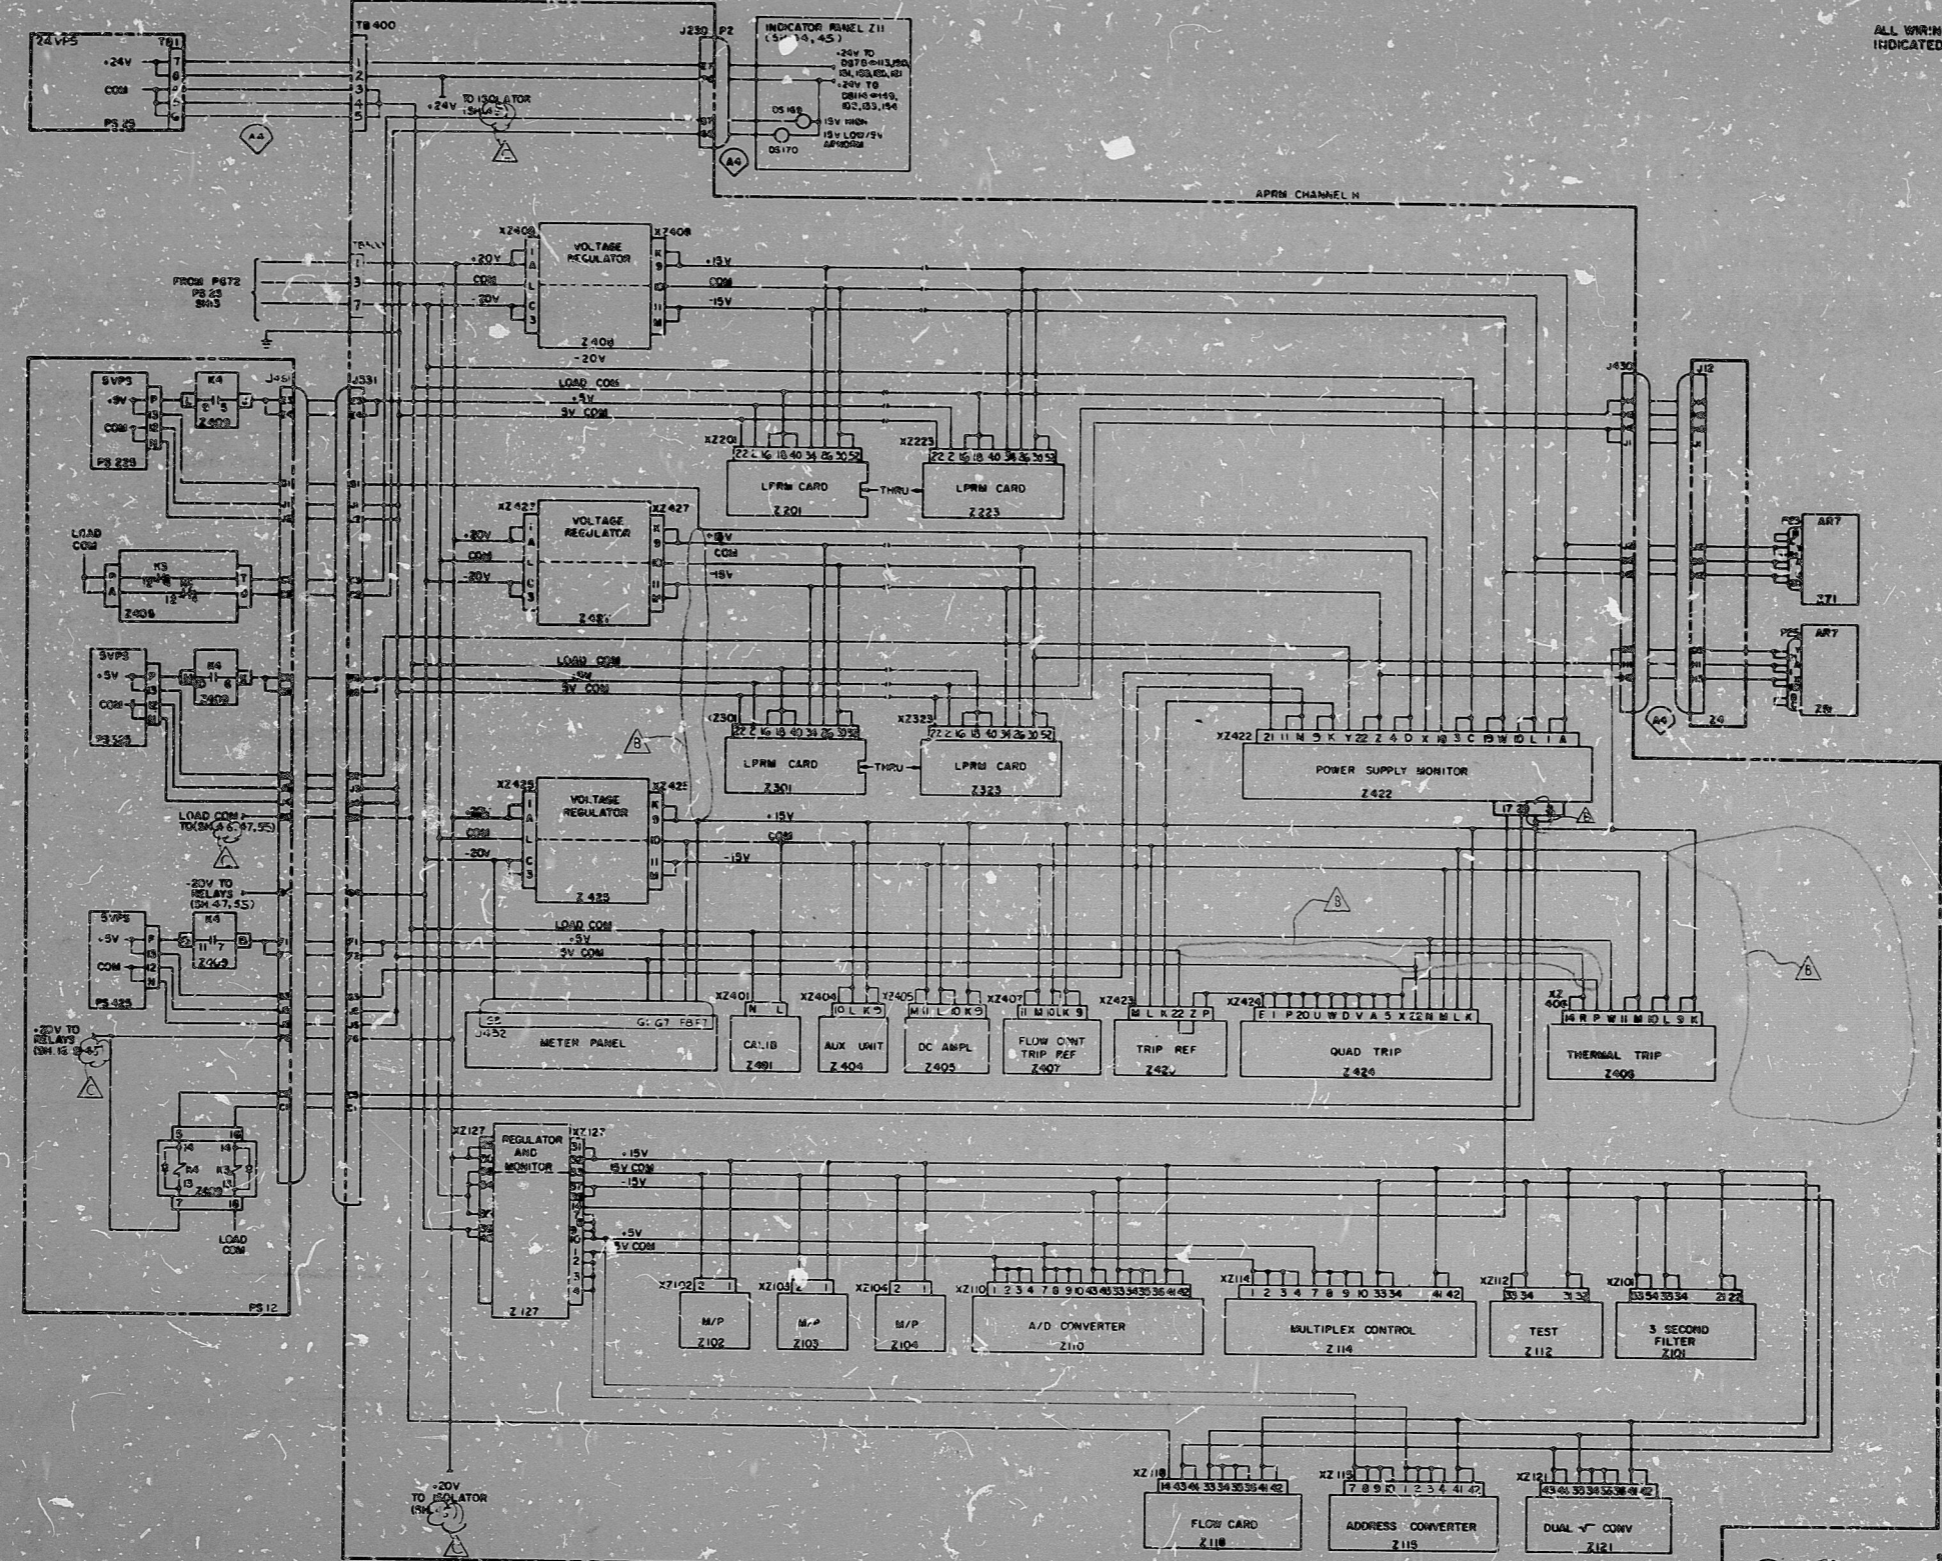

PRC APERTURE CARD

LINE CODES:  
NONE THIS SHEET

NUCLEAR SAFETY RELATED

THE CLEVELAND ELECTRIC ILLUMINATING CO.  
PERRY NUCLEAR POWER PLANT UNIT 1

ELECTRICAL-ELEMENTARY DIAGRAM  
POWER RANGE NEUTRON MONITORING SYSTEM  
DC POWER DISTRIBUTION-PANEL 1H13-P672

DESIGNED BY: ELECTRIC	DATE: 3/14/77	CONSTRUCTION	DATE: 3/14/77
CHECKED BY: SH 14	REV: 9	PRELIMINARY	DATE: 3/14/77
POWER RANGE NEUTRON MON. SYS.	DATE: 3/14/77	RELEASED FOR	ENGR.

REVISED PER GE DRAWING REV 9 DELETED LPRM AVG CARD Z427, Z405 WIRE BETWEEN Z425 & Z427 CHANGED CONNECT BETWEEN Z424 & Z406

REDRAWN PER GE REVISION G

REV	MADE	CHKD	APPROVALS	DATE	REV	MADE	CHKD	APPROVALS	DATE	REV	MADE	CHKD	APPROVALS	DATE	REV	MADE	CHKD	APPROVALS	DATE	WORK ORDER	MADE	CHKD	DR. APP.	ENG. APP.	DATE	DRAWING NUMBER	SYSTEM	SH. NO.	REV.
C	SM	TAM	DEG RAM	7/17/82	B	Y	PAJ	DEG RAM	11/7/89	A	CAM	RAM	DEG RAM	1-30-80	044549-000	3	Z	C	RAM	DEG	YFF	8-24-77	04	4549-B-208-038	C51	B14	C		

ELEM DIAG 1C51B DC PWR 1H13-P672

Rids

82.12140118

