


17"
11"
8.5"
8.5"
11"
17"

17"
11"
8.5"
8.5"
11"
17"

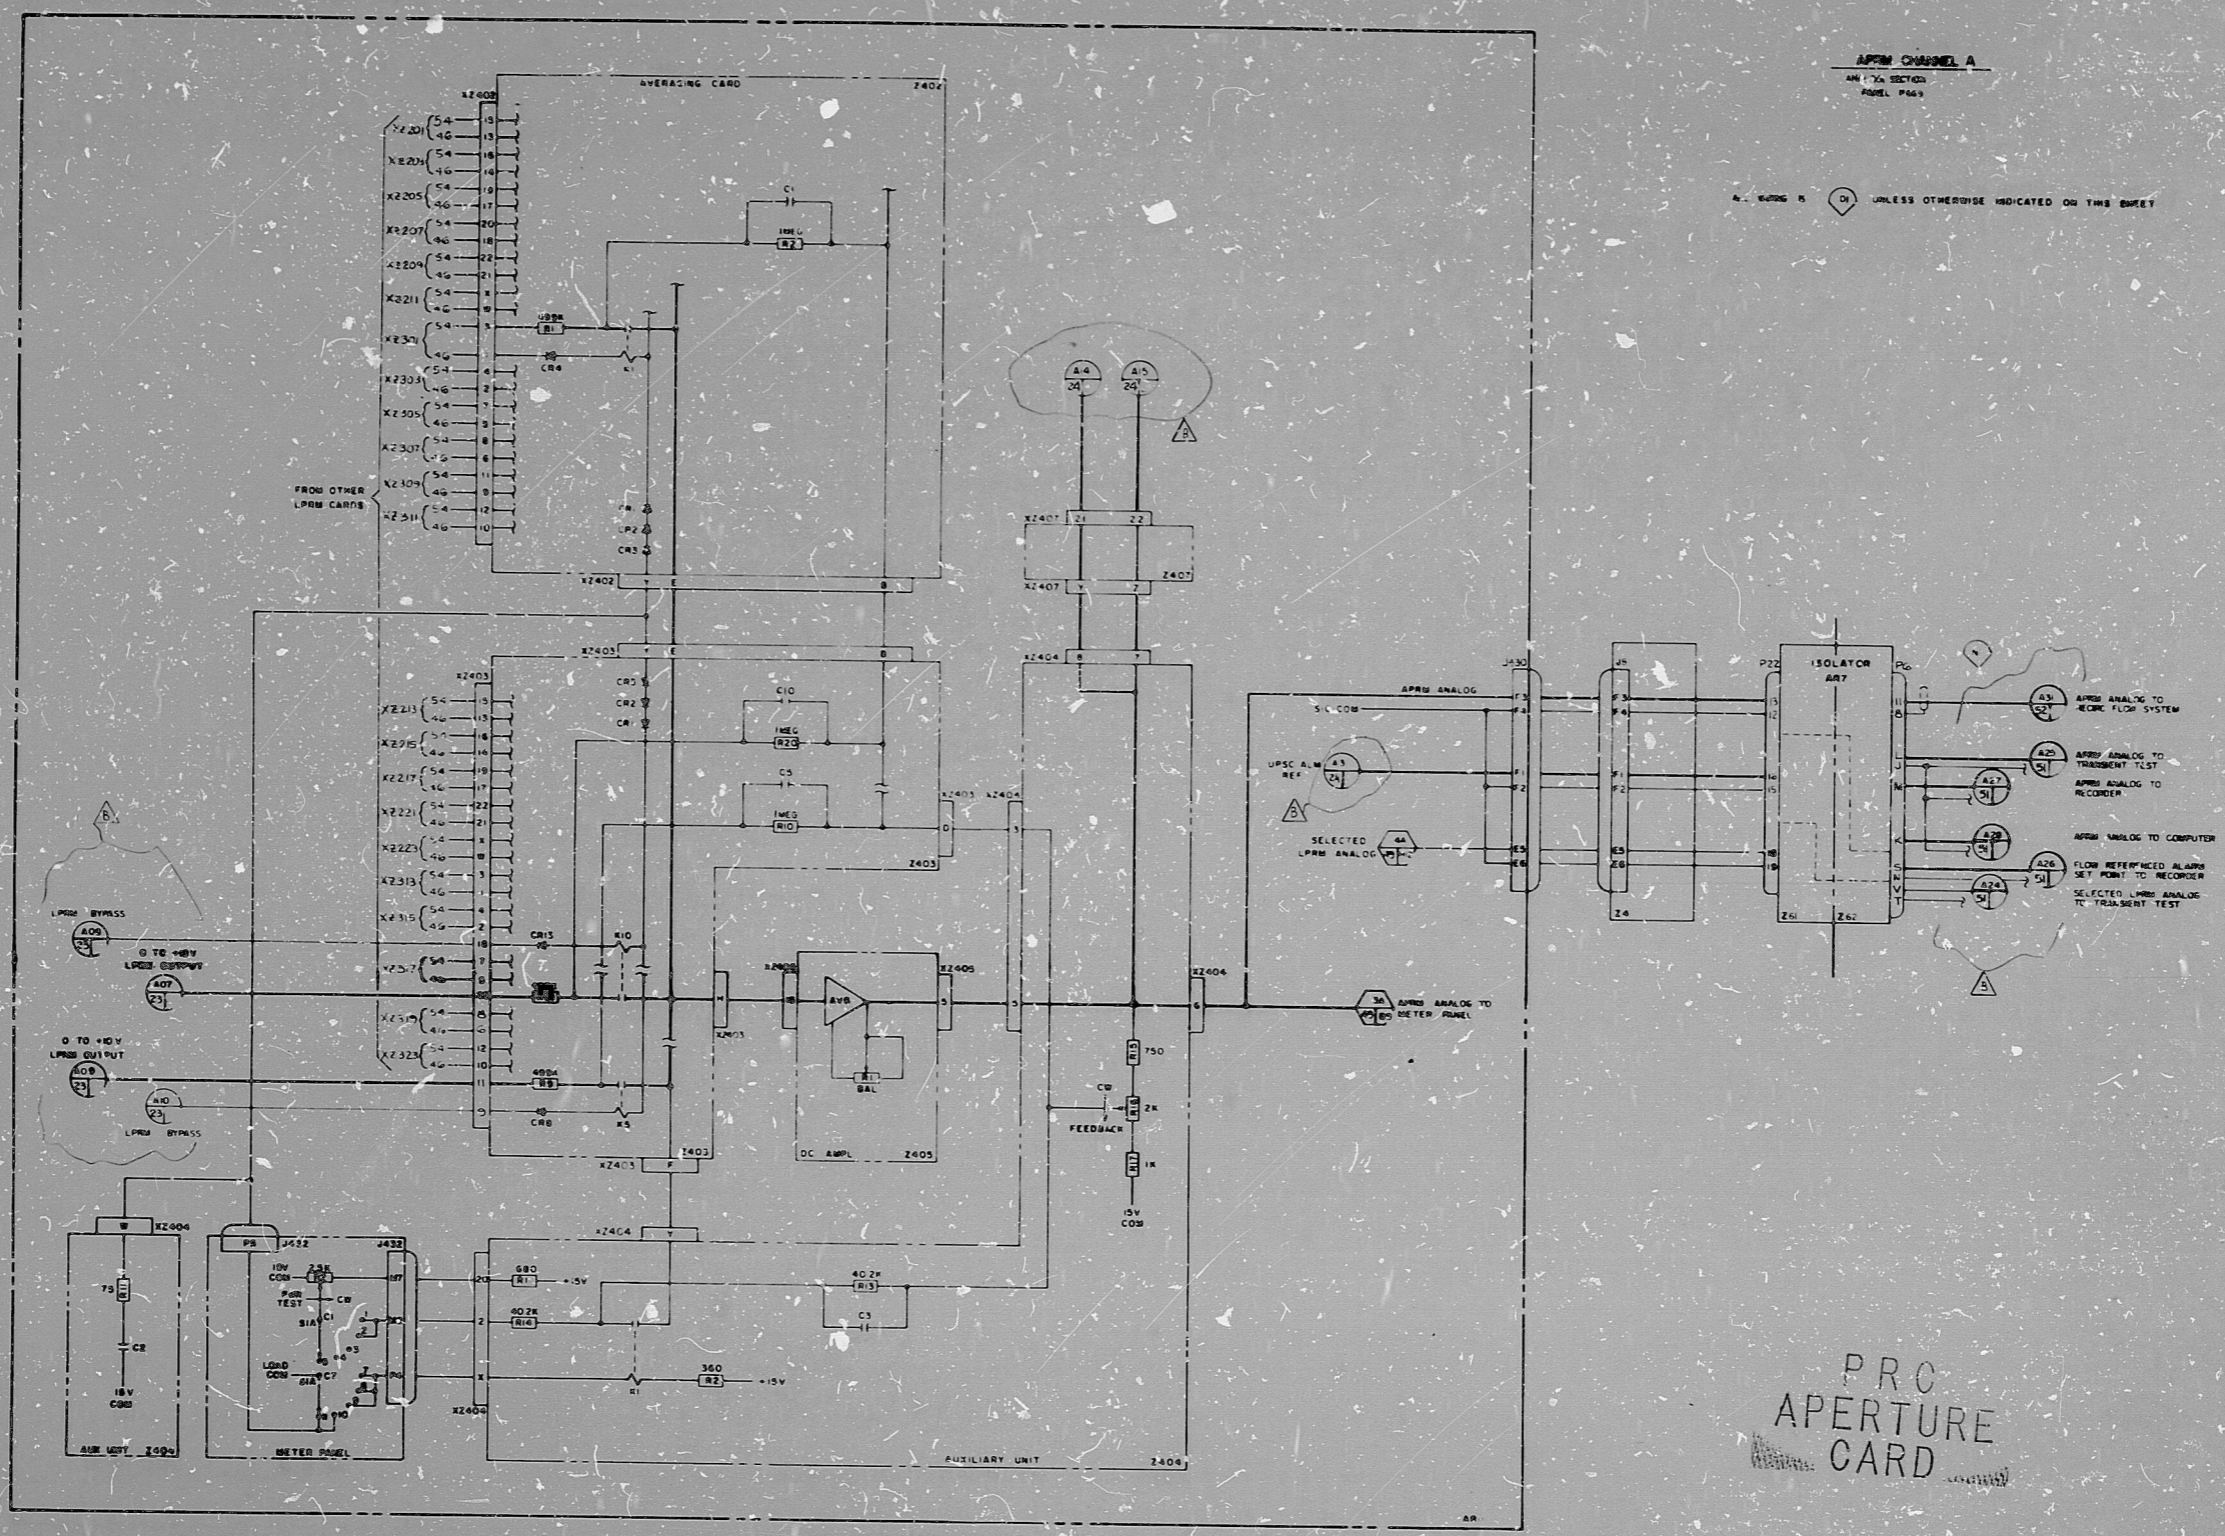

PRO APERTURE CARD

NUCLEAR SAFETY RELATED
THE CLEVELAND ELECTRIC ILLUMINATING CO.
PERRY NUCLEAR POWER PLANT UNIT 1
ELECTRICAL-ELEMENTARY DIAGRAM
POWER RANGE NEUTRON MONITORING SYSTEM
APRM CHANNEL A - ANALOG SECTION

REVISIONS
2205 238C1 SH 24 REV 7
POWER RANGE NEUTRON MON SYS

9-77	CONSTRUCTION	gmk
	PRELIMINARY	
DATE	RELEASED FOR	ENGR.

REVISED-MATCH CIRCLES REDRAWN PER GE REVISION G

READING PA GILBERT ASSOCIATES, INC. ENGINEERS AND CONSULTANTS

REV.	MADE	CHKD	APPROVALS	DATE	REV.	MADE	CHKD	APPROVALS	DATE	REV.	MADE	CHKD	APPROVALS	DATE	REV.	MADE	CHKD	APPROVALS	DATE	WORK ORDER	MADE	CHKD	DR. APP.	ENG. APP.	DATE	DRAWING NUMBER	SYSTEM	SH. NO.	REV.		
																					044549-000	BICRAM	DEG	TFE	8-24-77	04	4549	B-208-038	C51	B25	B

ELEM DIAG ICSIB APRM CH "A" ANALOG

RIDS

8212140166

