

11

11

8.5"

8.5"

11"

17"

11


11

8.5"

8.5"

11"

17"

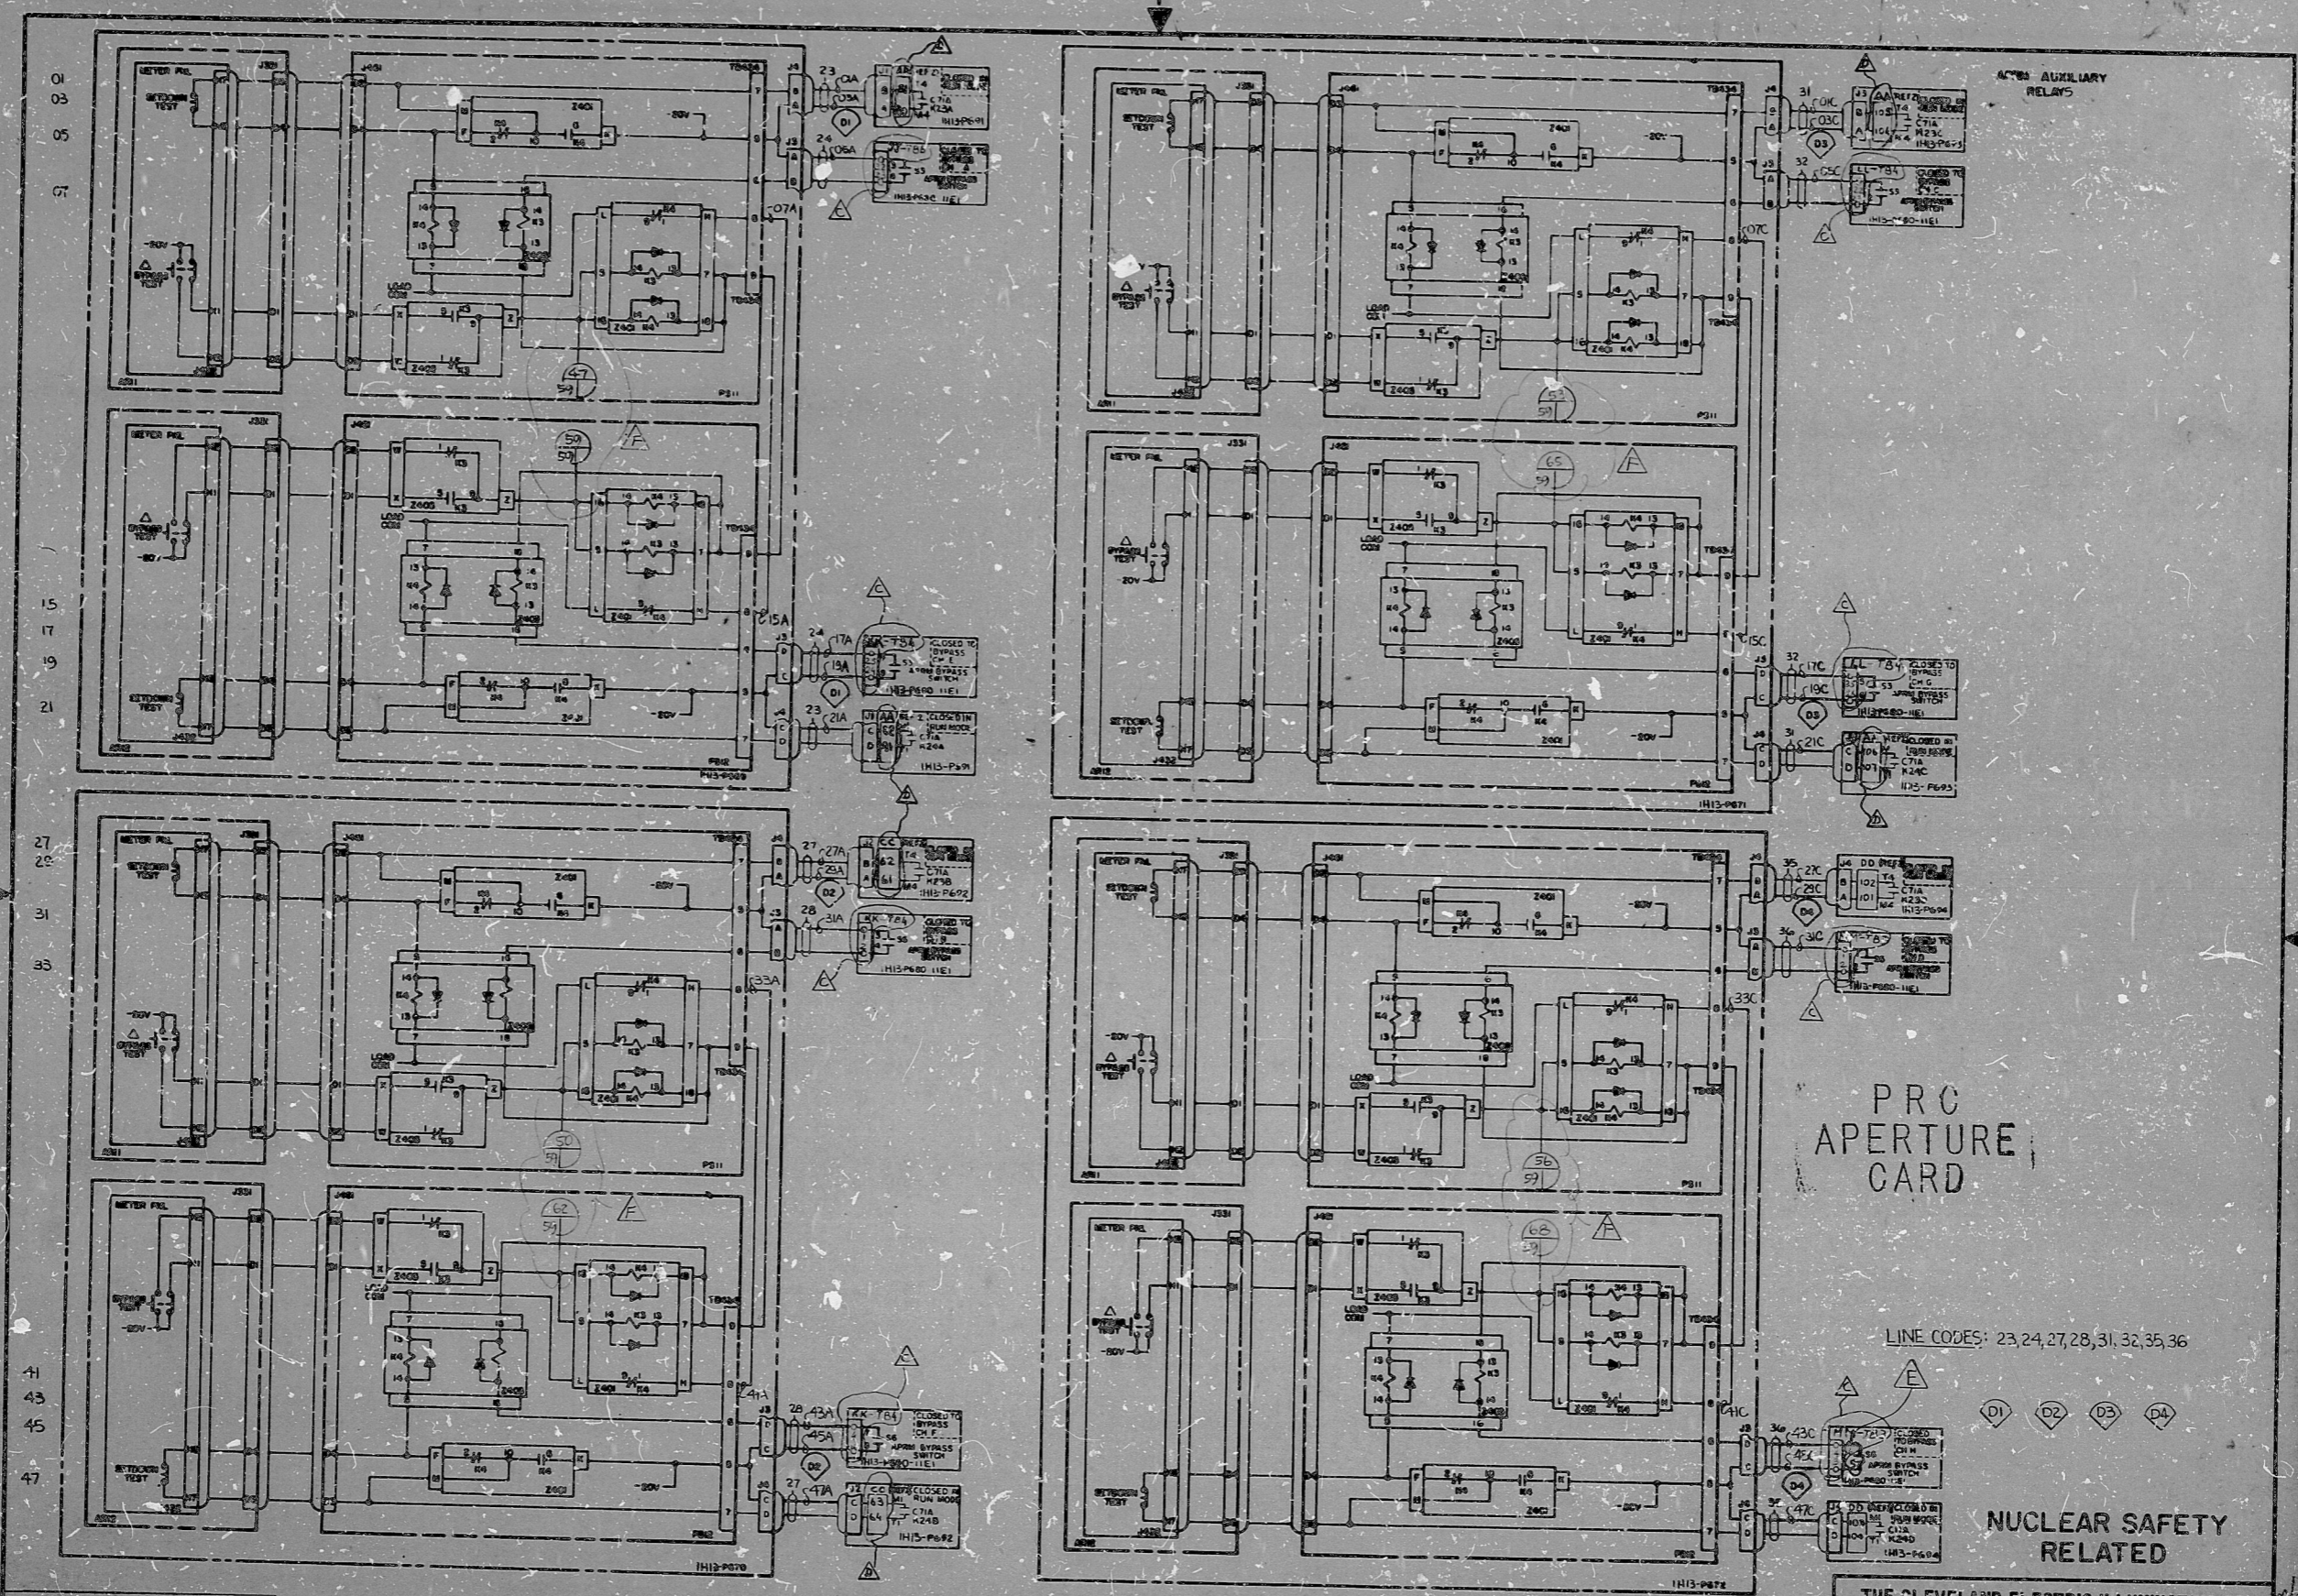

PRC  
APERTURE  
CARD

LINE CODES: 23, 24, 27, 28, 31, 32, 35, 36



NUCLEAR SAFETY  
RELATED

ADDED ATMS CIRCUITRY  
PER GE DWG REV. 10

REVISED CONTACT TERM  
DESIG. PER GE REV. B

CHANGED PLUG DESIGNATION  
ADDED TERMIN. INFORM.

REDRAWN PER GE REVISION 2

ADDED PLUG DESIGNATIONS  
PER GE REV. 5

REV MADE CHKD APPROVALS DATE

REV MADE CHKD APPROVALS DATE

REV MADE CHKD APPROVALS DATE

REV MADE CHKD APPROVALS DATE

REV MADE CHKD APPROVALS DATE

READING PA. GILBERT ASSOCIATES, INC. ENGINEERS AND CONSULTANTS

THE CLEVELAND ELECTRIC ILLUMINATING CO.				UNIT 1	
PERRY NUCLEAR POWER PLANT				ELECTRICAL-ELEMENTARY DIAGRAM	
POWER RANGE NEUTRON MONITORING SYSTEM				APRM AUXILIARY RELAYS	
04	4549	B-203-038	CS1	B47	F
DRAWING NUMBER			SYSTEM SH. NO. REV.		

ELEM DTAG 1 CS1B APRM AUX RELAYS

RIDS

82/2140233

