


17"
8.5"
11"
8.5"
11"
17"

17"
8.5"
11"
8.5"
11"
17"

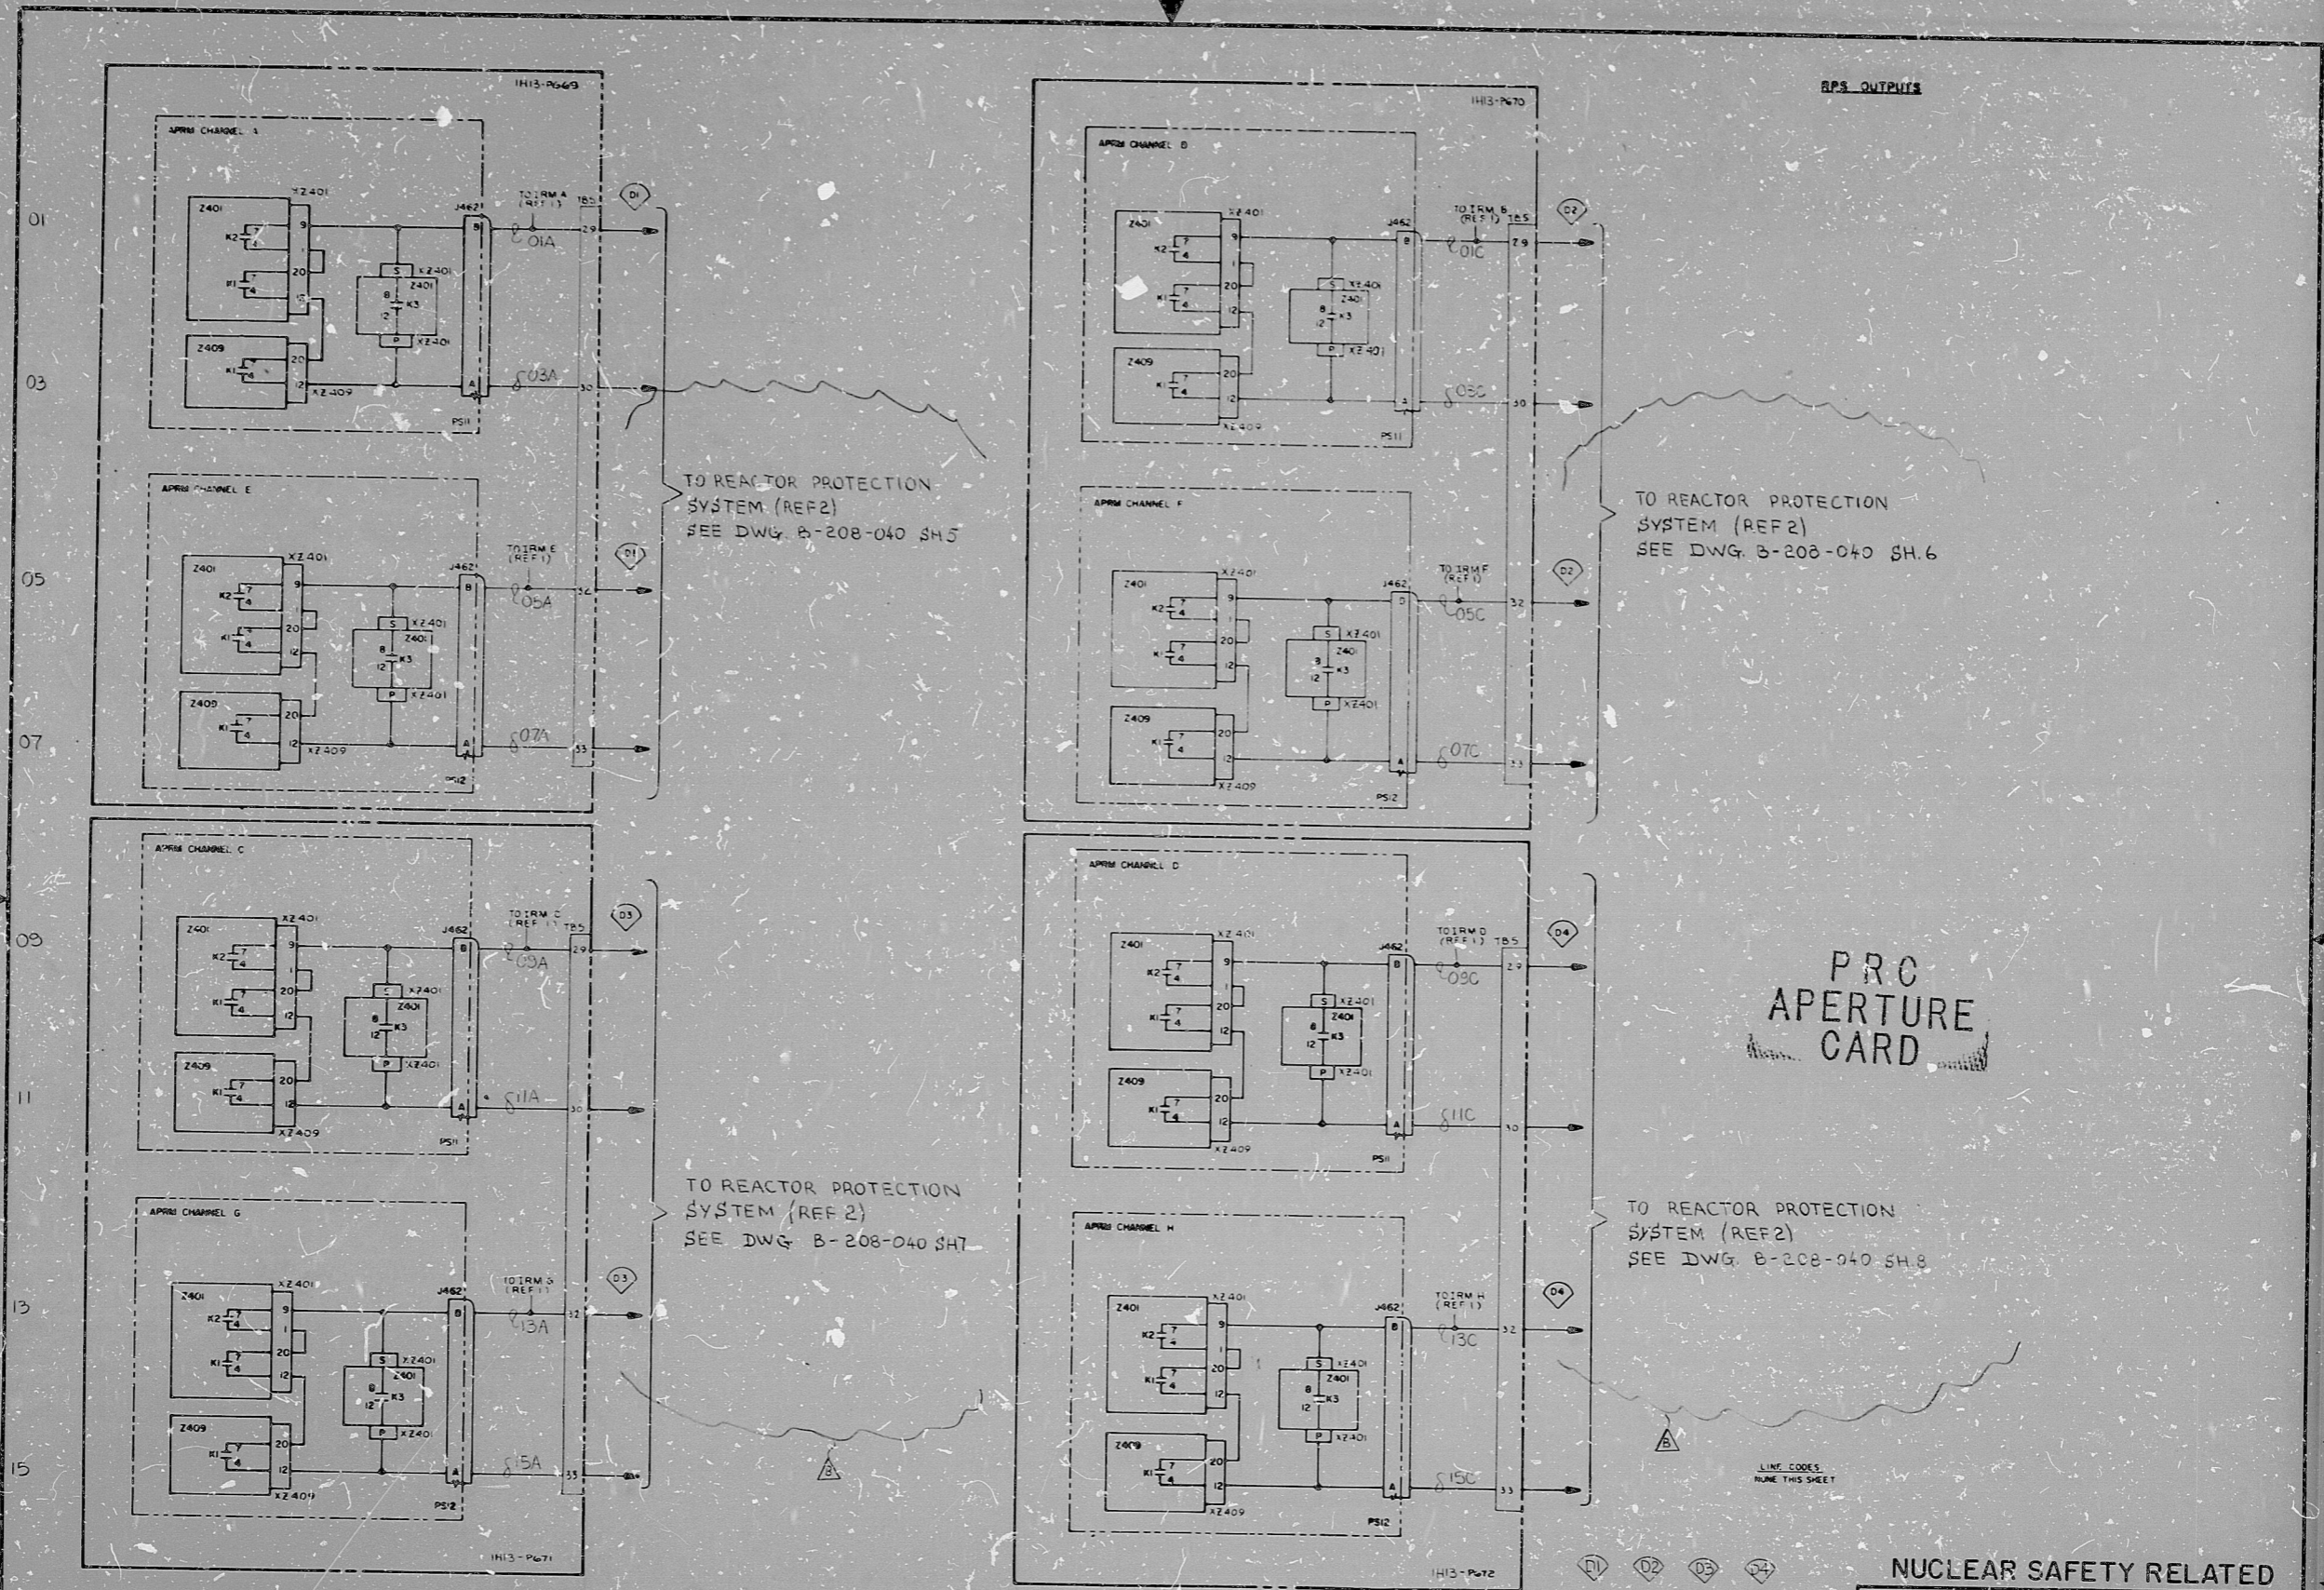

<p>GENERAL ELECTRIC 8285238CJ ELEM DIAG POWER RANGE NEUTRON MON. SYS. REV. 6</p>												<p>9-1-77 CONSTRUCTION PRELIMINARY DATE RELEASED FOR ENGR.</p>		<p>PERRY NUCLEAR POWER PLANT UNIT 1 ELECTRICAL-ELEMENTARY DIAGRAM POWER RANGE NEUTRON MONITORING SYSTEM RPS OUTLETS</p>	
<p>ADDED REF. REDRAWN PER GE REVISION 6</p>												<p>GILBERT ASSOCIATES, INC. ENGINEERS AND CONSULTANTS</p>		<p>04 4549 B-208-038 C51 B54 B</p>	
<p>ELEM DIAG ICSIB RPS OUTPUTS</p>												<p>04 4549 B-208-038 C51 B54 B</p>		<p>DRAWING NUMBER SYSTEM SH. NO. REV.</p>	

8212140284

RIDS

