

11

11

8.5

8.5

11

17

11


11

8.5

8.5

11

17

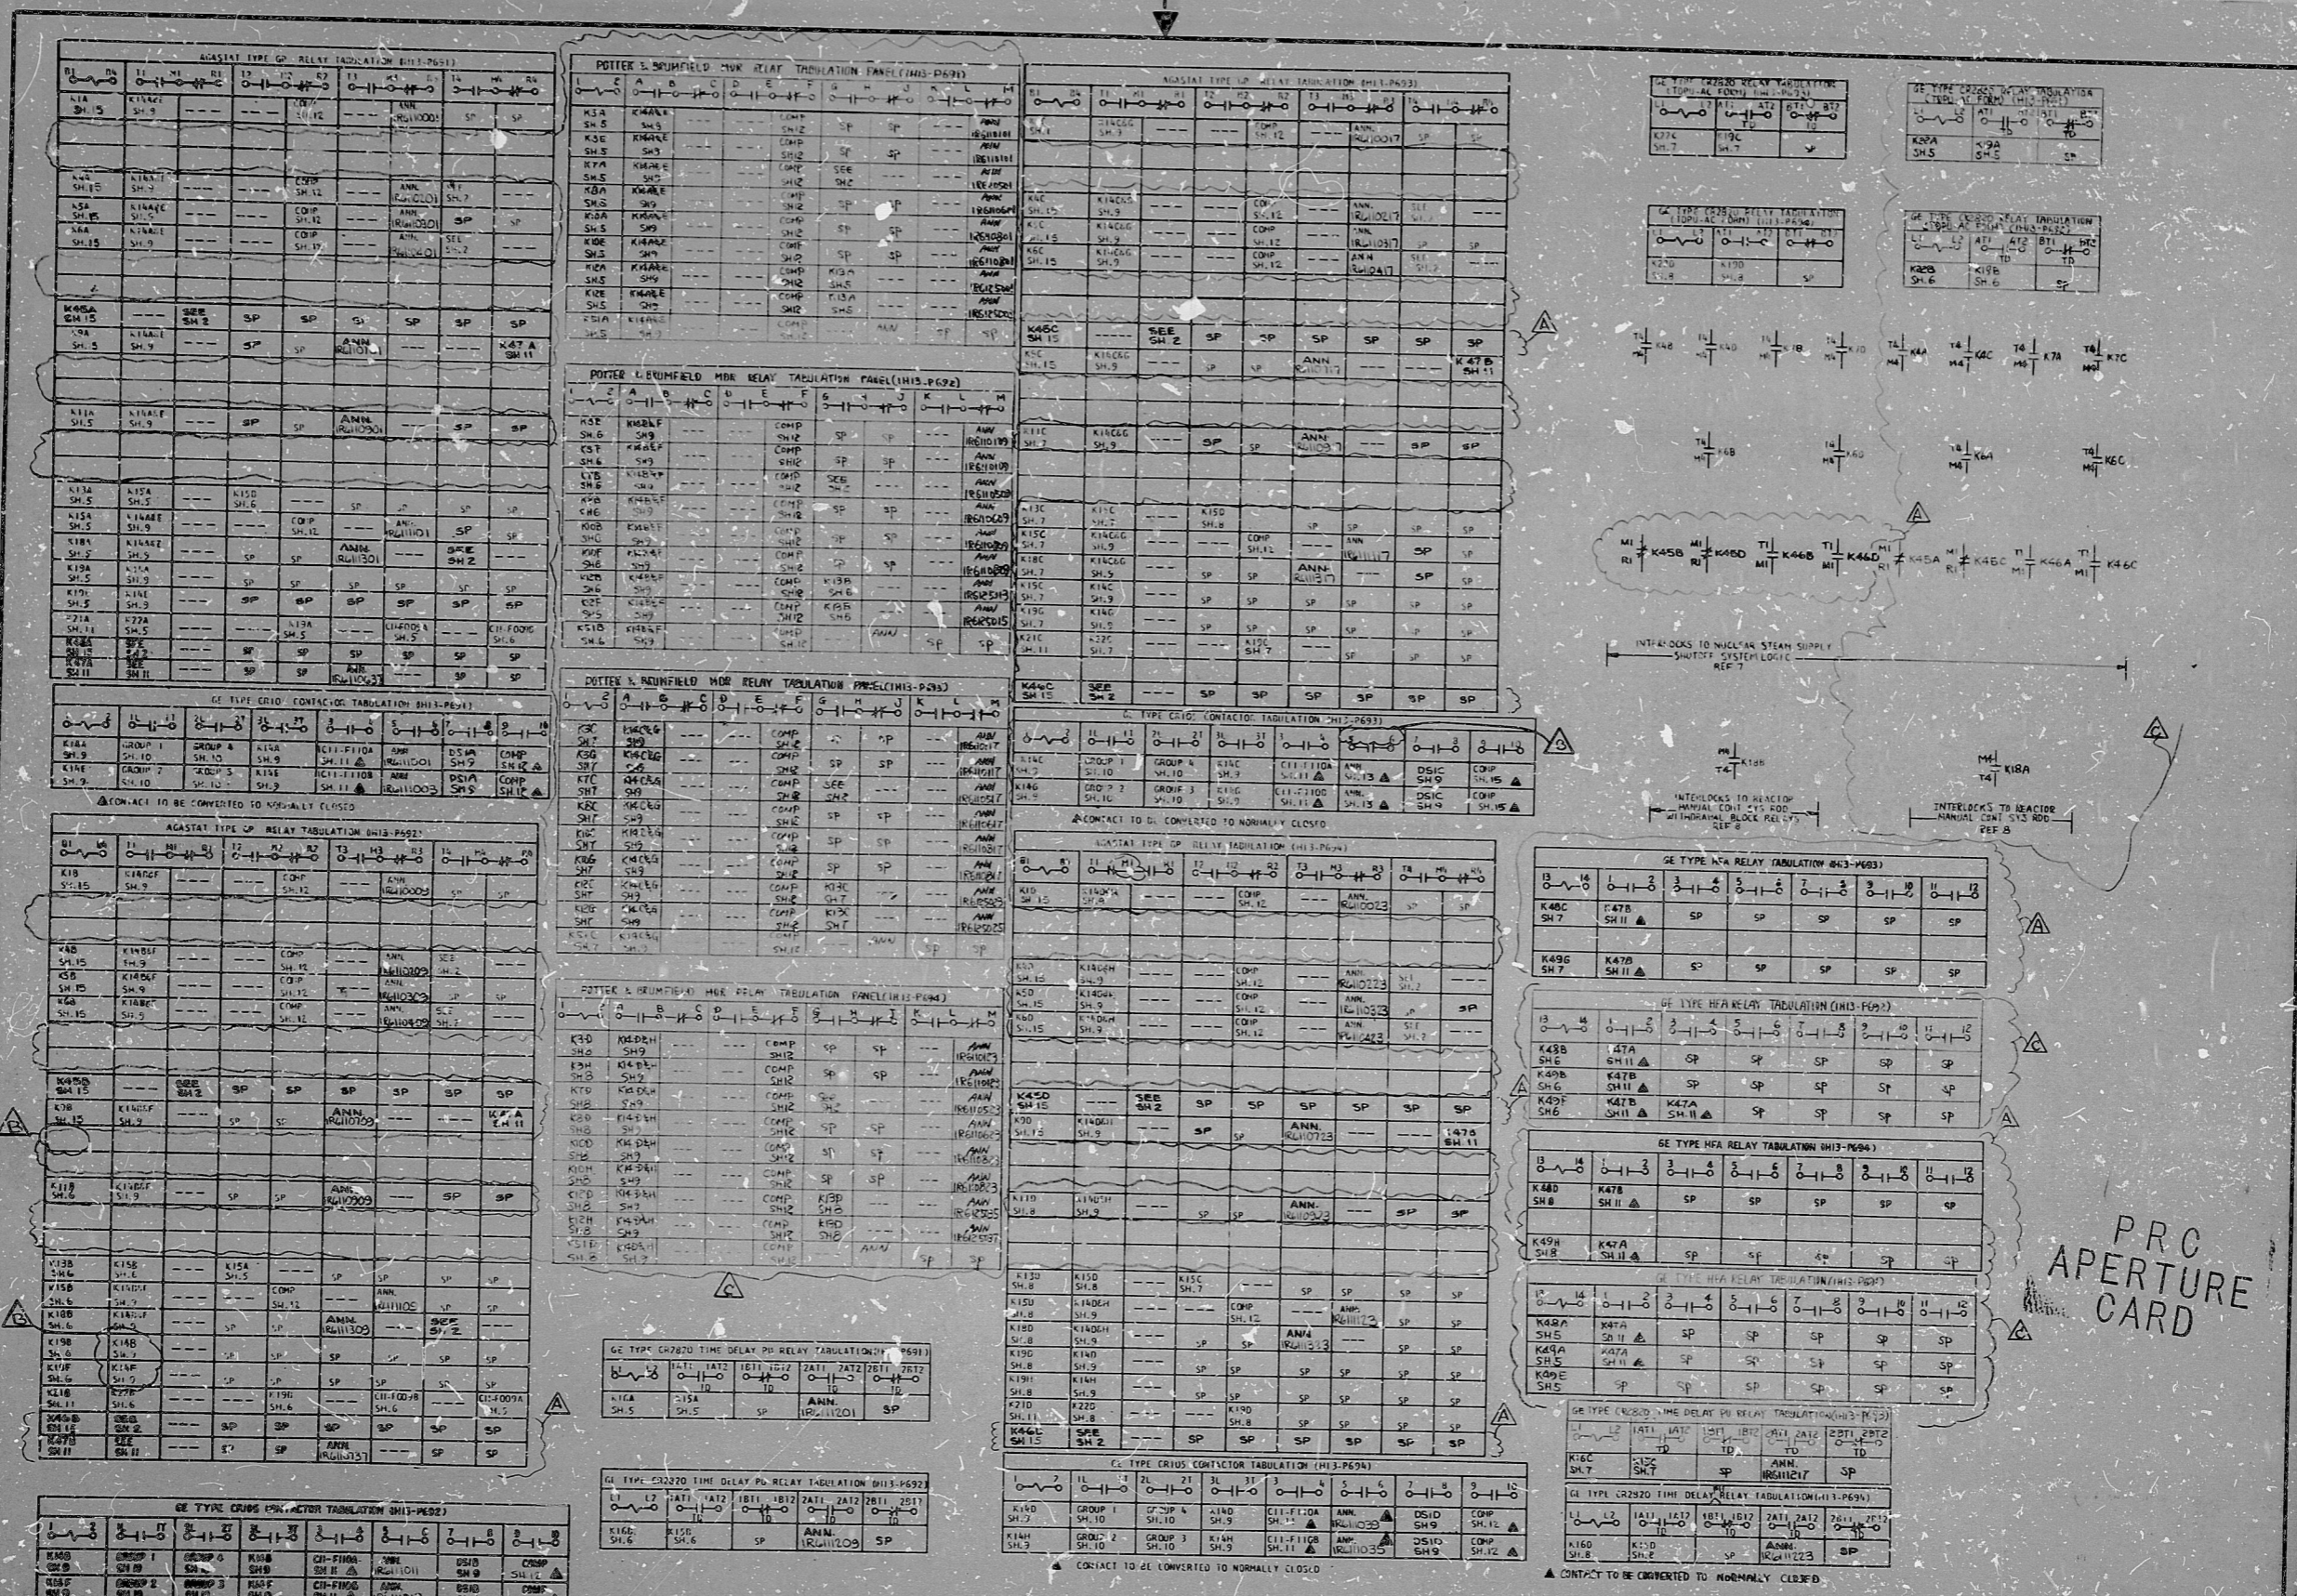

THE CLEVELAND ELECTRIC ILLUMINATING CO.
 PERRY NUCLEAR POWER PLANT UNIT 1
 ELECTRICAL-ELEMENTARY DIAGRAM
 REACTOR PROTECTION SYSTEM
 RELAY TABULATIONS

REVISIONS:
 REV. 1: MADE BY [Name], DATE [Date]
 REV. 2: MADE BY [Name], DATE [Date]
 REV. 3: MADE BY [Name], DATE [Date]
 REV. 4: MADE BY [Name], DATE [Date]
 REV. 5: MADE BY [Name], DATE [Date]
 REV. 6: MADE BY [Name], DATE [Date]
 REV. 7: MADE BY [Name], DATE [Date]
 REV. 8: MADE BY [Name], DATE [Date]
 REV. 9: MADE BY [Name], DATE [Date]
 REV. 10: MADE BY [Name], DATE [Date]

DATE: 4/30/77
 DRAWING NUMBER: 04 4549 18-208-040 C71 A02 C
 SYSTEM SH. NO. 000

RIDS

82/2140296

