


PRC APERTURE CARD

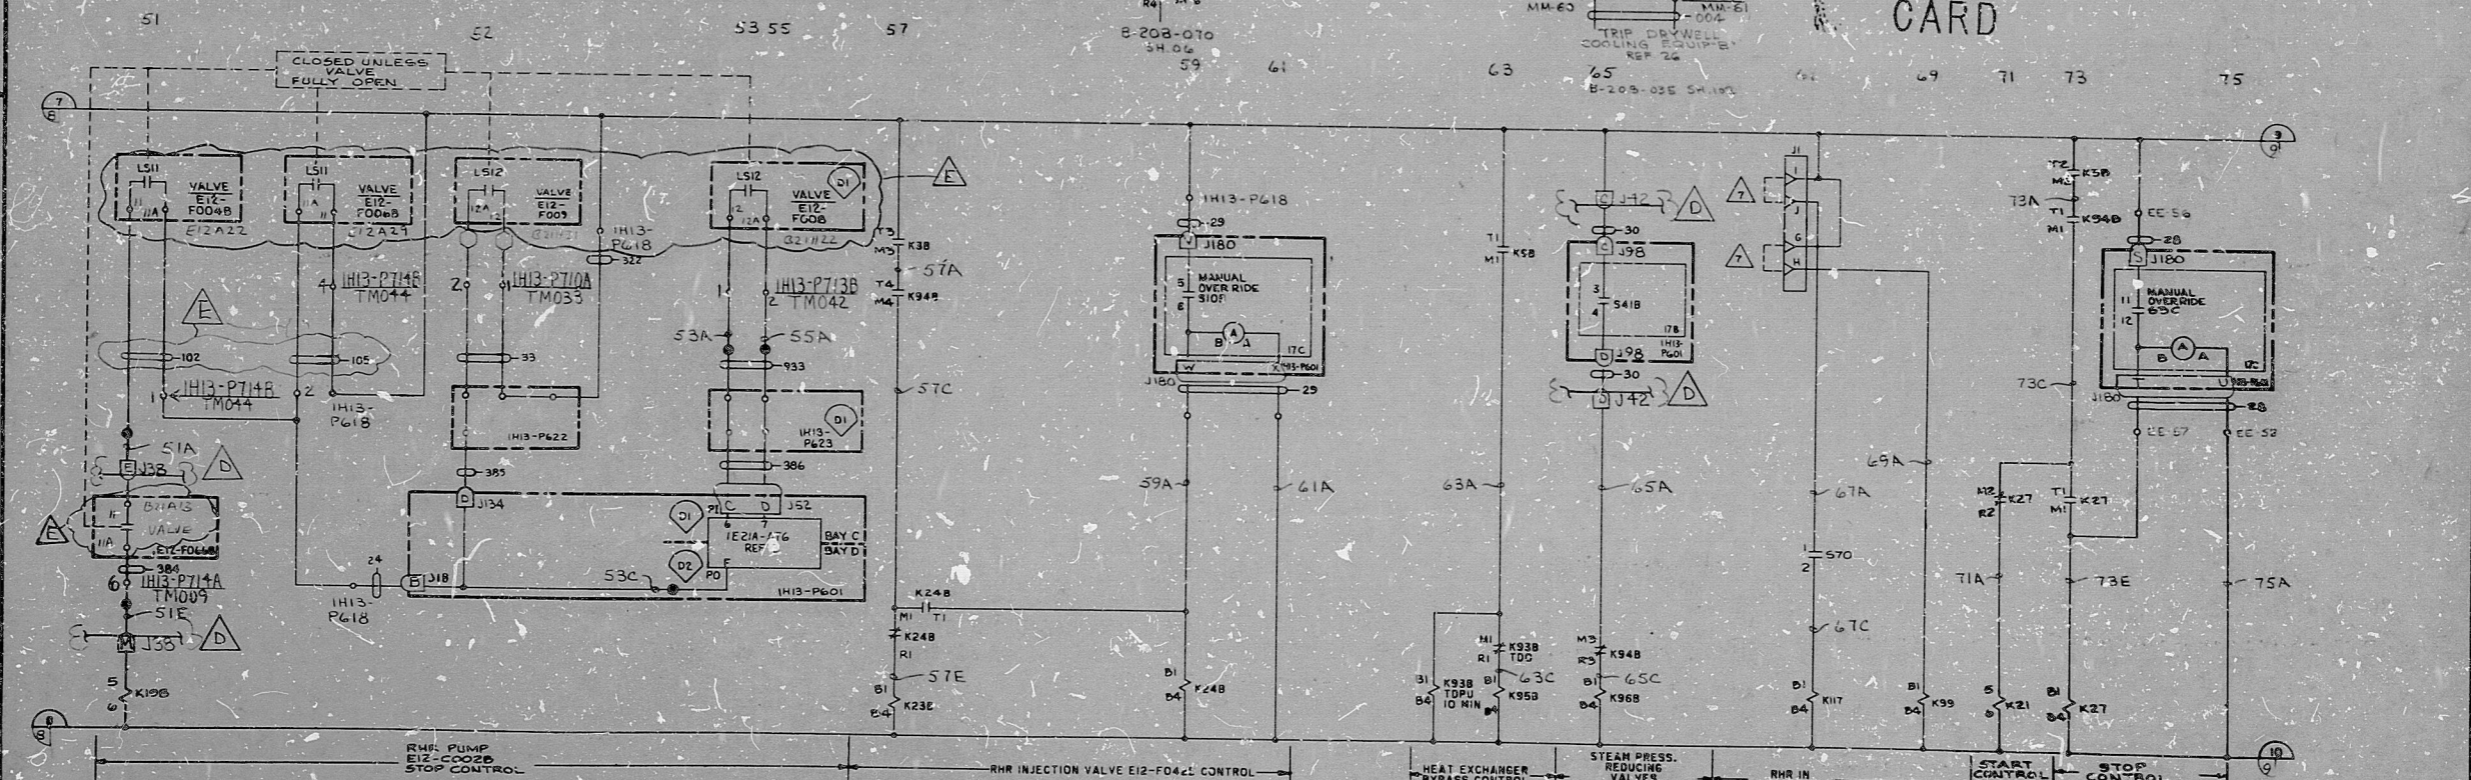

NUCLEAR SAFETY RELATED

CLOSED CONTACT; CHANGED PUMP NOS; ADDED VALVE LOCATION; TERM. PLS AS PER GE LOG. & CABL.										ADDED RELAY K118 & C										REVISED J35 TO J42 & J30 TO J31 PER GE REVISION 4										ADDED FITS INFORMATION AND PLUGS, ADDED SWGR. INFO.										REDRAWN PER GE REV. 2 REVISED LIMIT SWITCH LINE CODES PER MEETING AT GE.										READING PA. GILBERT ASSOCIATES, INC. ENGINEERS AND CONSULTANTS										THE CLEVELAND ELECTRIC ILLUMINATING CO. PERRY NUCLEAR POWER PLANT UNIT 1 ELECTRICAL-ELEMENTARY DIAGRAM									
E JET TAM DEG RAM 11/1/82										D TAG RM DEG RAM 2-11-81										C CAG RAM DEG RAM 11-1-79										B P J RAM DEG RAM 8-17-77										A RAM DEG RAM 9-2-78										044549-000 B C RAM DEG TFF 6/30/77 04 4549 B-208-C55 E12 ACS E																			
REV MADE CHKD APPROVALS DATE										REV MADE CHKD APPROVALS DATE										REV MADE CHKD APPROVALS DATE										REV MADE CHKD APPROVALS DATE										REV MADE CHKD APPROVALS DATE										WORK ORDER MADE CHKD. DR. APP. ENG. APP. DATE										DRAWING NUMBER SYSTEM SH. NO. REV									

ELEM DIAG IE12 RELAY LOGIC BUS B

RIDS

82-2140480

