
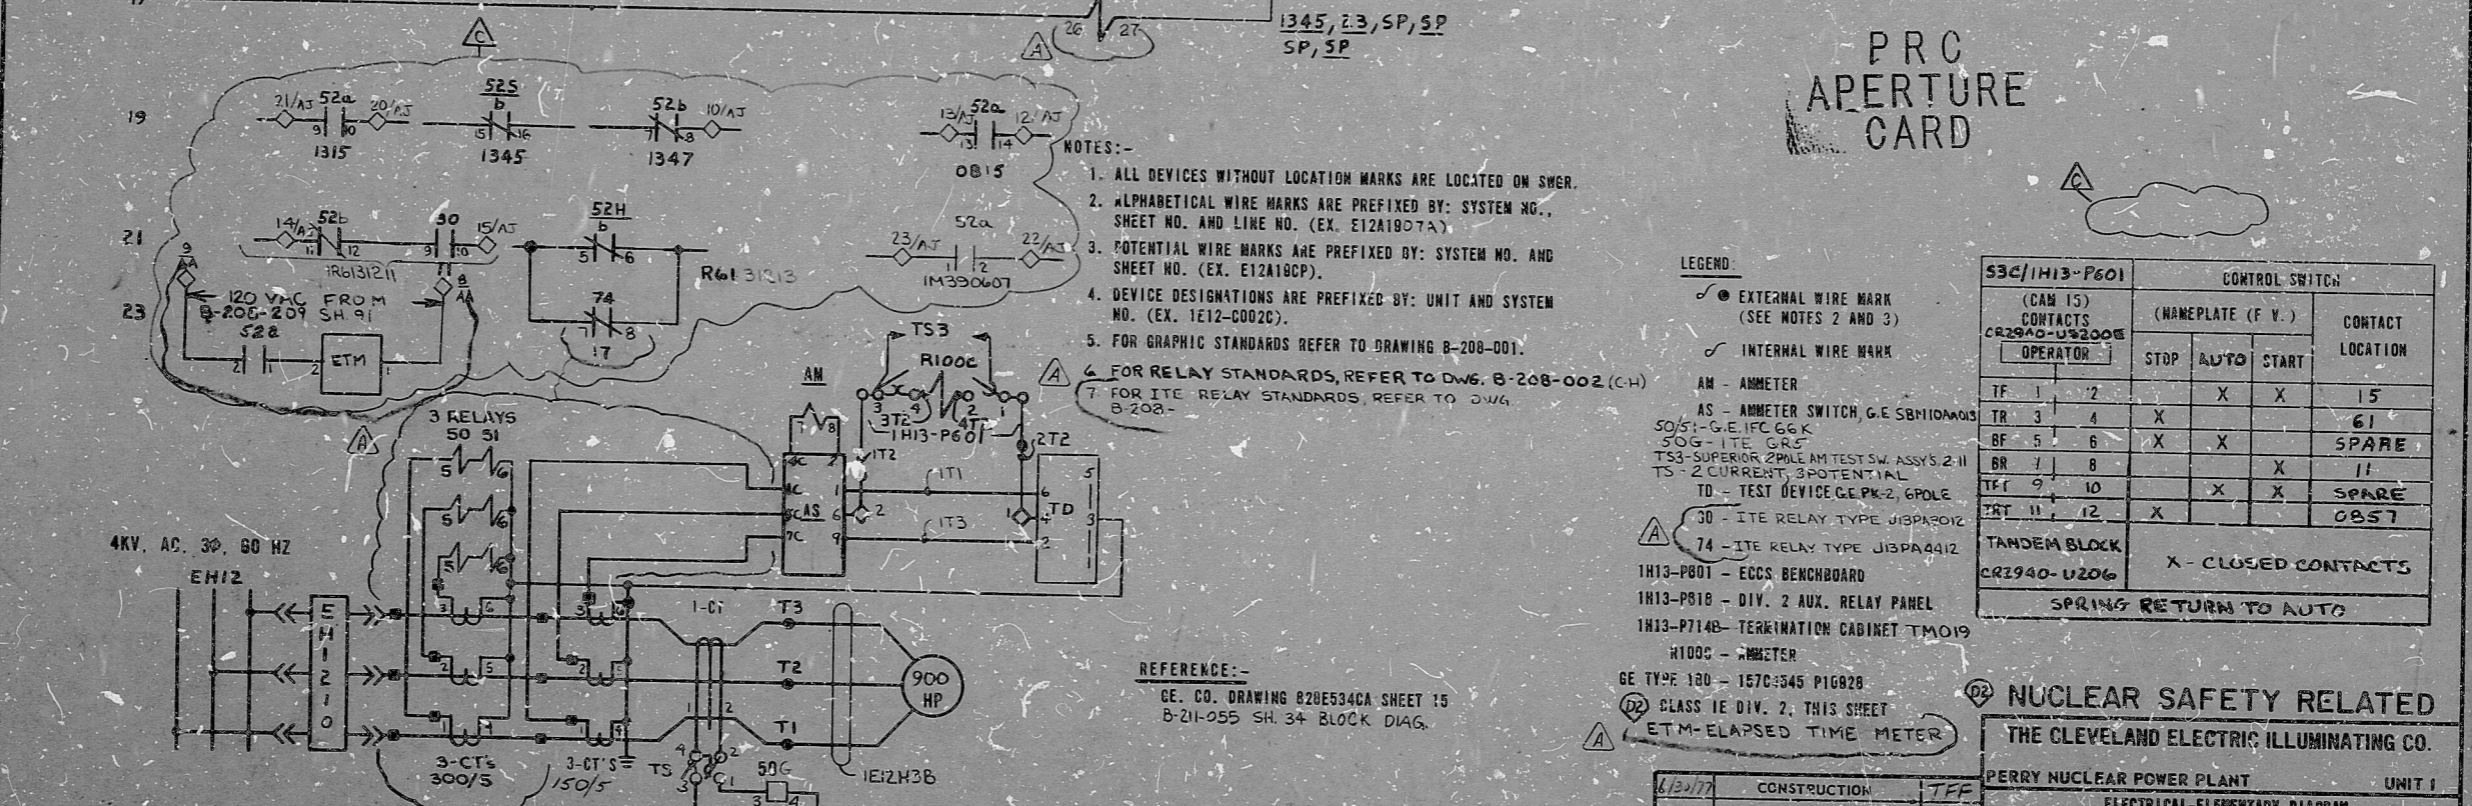


11
11
8.5"
11"
17"

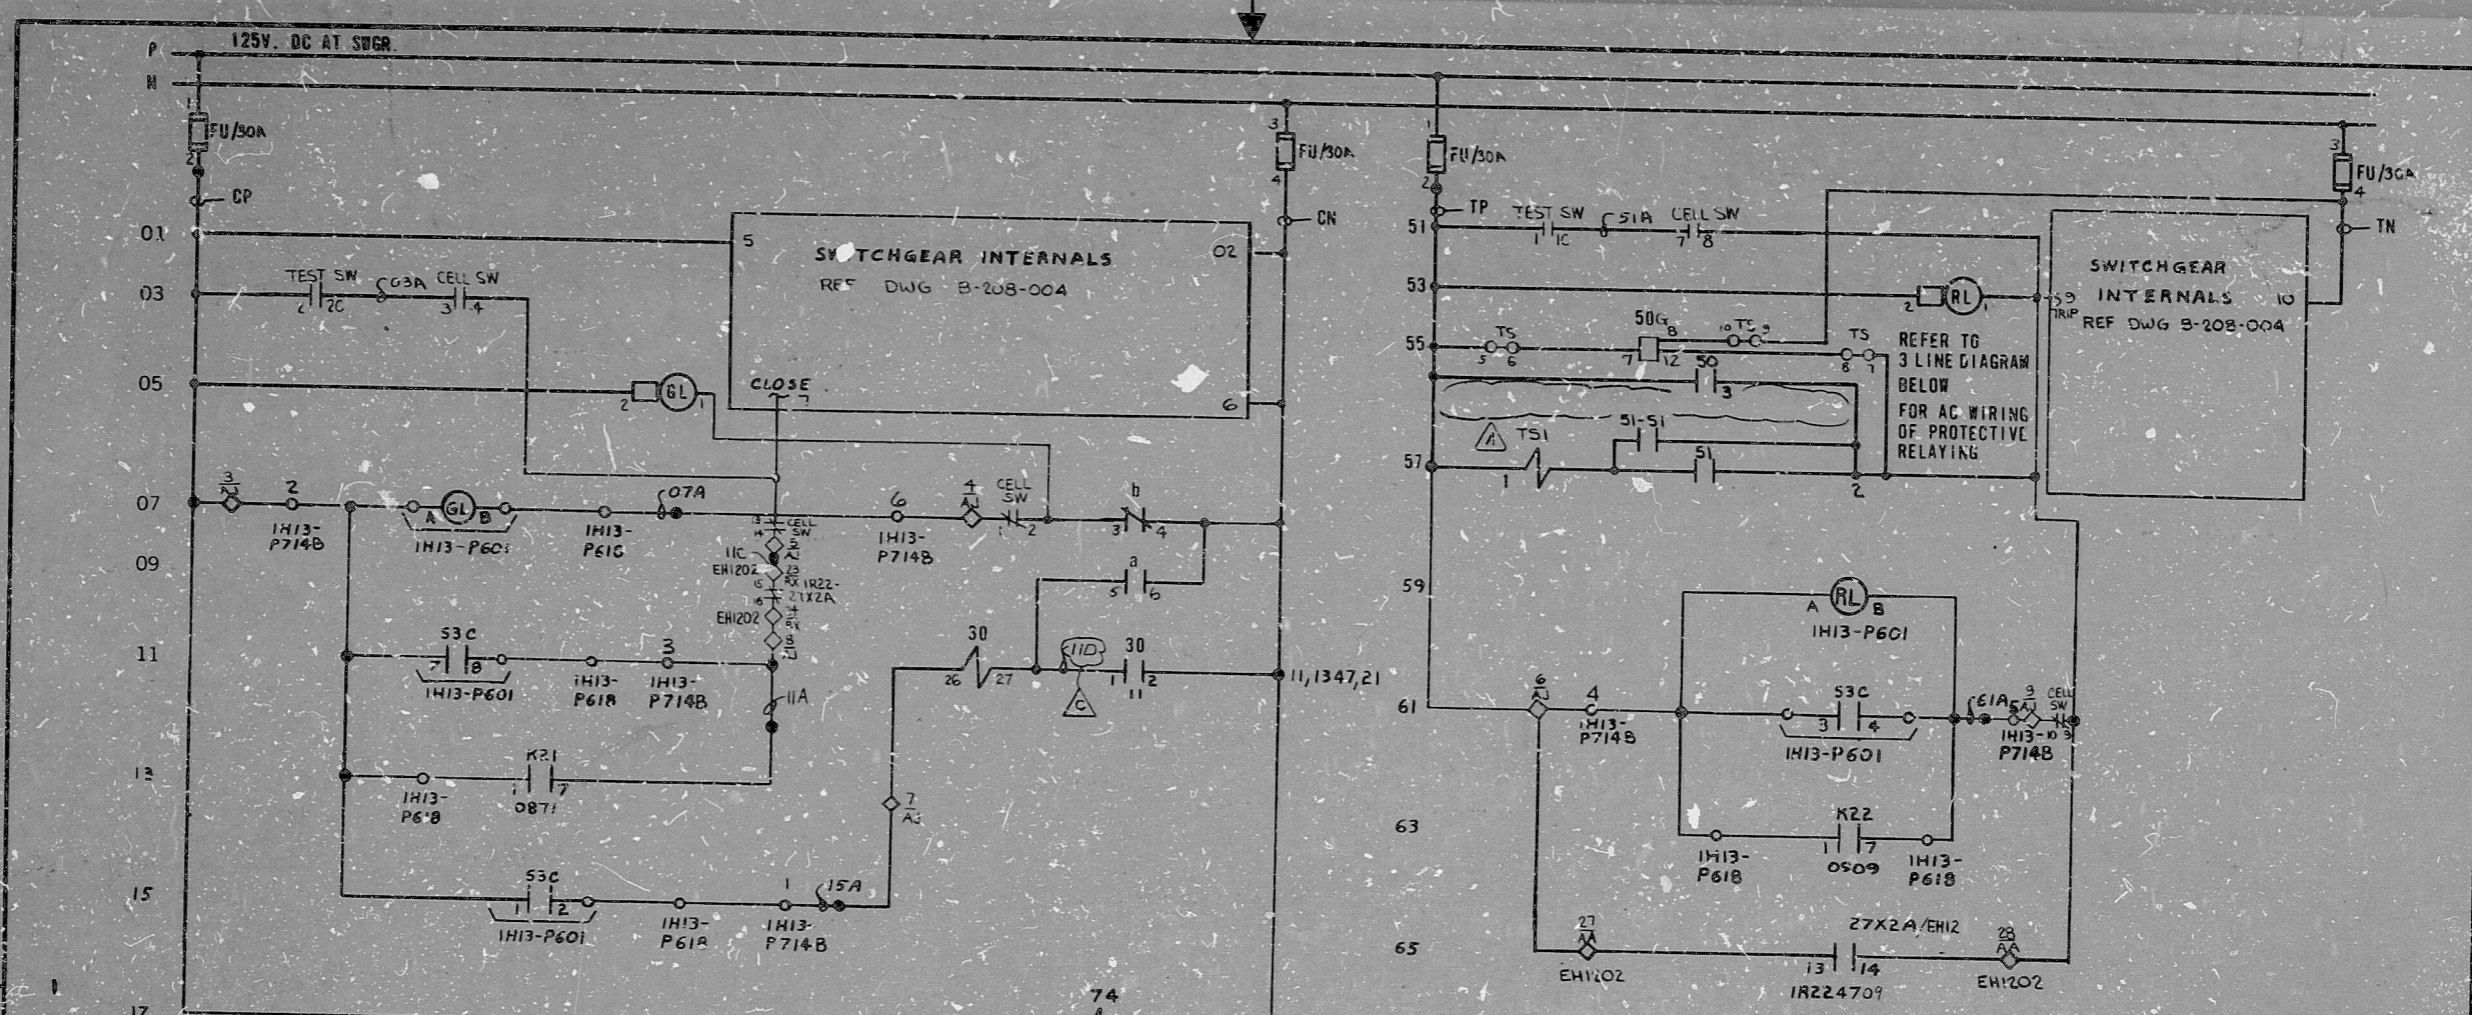

53C/1H13-P601		CONTROL SWITCH			CONTACT LOCATION
(CAM 15) CONTACTS CR2940-U2006 OPERATOR		(NAMEPLATE (F.V.))			
		STOP	AUTO	START	
TF	1, 2		X	X	15
TR	3, 4	X			61
BF	5, 6	X	X		SPARE
BR	7, 8			X	11
TF	9, 10		X	X	SPARE
TR	11, 12	X			0857

TANDEM BLOCK
CR2940-U206
X - CLOSED CONTACTS
SPRING RETURN TO AUTO

NUCLEAR SAFETY RELATED

THE CLEVELAND ELECTRIC ILLUMINATING CO.

PERRY NUCLEAR POWER PLANT UNIT 1
ELECTRICAL-ELEMENTARY DIAGRAM

RESIDUAL HEAT REMOVAL SYSTEM
RHR PUMP CO2C

CONSTRUCTION	TFE	DATE	RELEASED FOR	ENGR.
PRELIMINARY				

GILBERT ASSOCIATES, INC.
ENGINEERS AND CONSULTANTS

REV	MADE	CHKD	APPROVALS	DATE	REV	MADE	CHKD	APPROVALS	DATE	REV	MADE	CHKD	APPROVALS	DATE	REV	MADE	CHKD	APPROVALS	DATE	
C	TAM	DES	RAM	11/18/72	B	CAG	RAM	DES	RAM	11/18/72	A	DES	RAM	11/18/72						

044549-000
WORK ORDER
GILBERT ASSOCIATES, INC.
ENGINEERS AND CONSULTANTS

DATE	REV	MADE	CHKD	APPROVALS	DATE	REV	MADE	CHKD	APPROVALS	DATE	REV	MADE	CHKD	APPROVALS	DATE
11/20/72	1	DES	RAM	DES	RAM	11/20/72	1	CHKD	RAM	11/20/72	1	CHKD	RAM	11/20/72	1

4549 B-208-055 F12 A19 C
DRAWING NUMBER SYSTEM SH. NO. REV.

ELEM DIAG RHR PUMP CO2C

11
11
8.5"
11"
17"

RIDS

8212160252

