

17"

11"

8.5"

8.5"

11"

17"

17"


11"

8.5"

8.5"

11"

17"

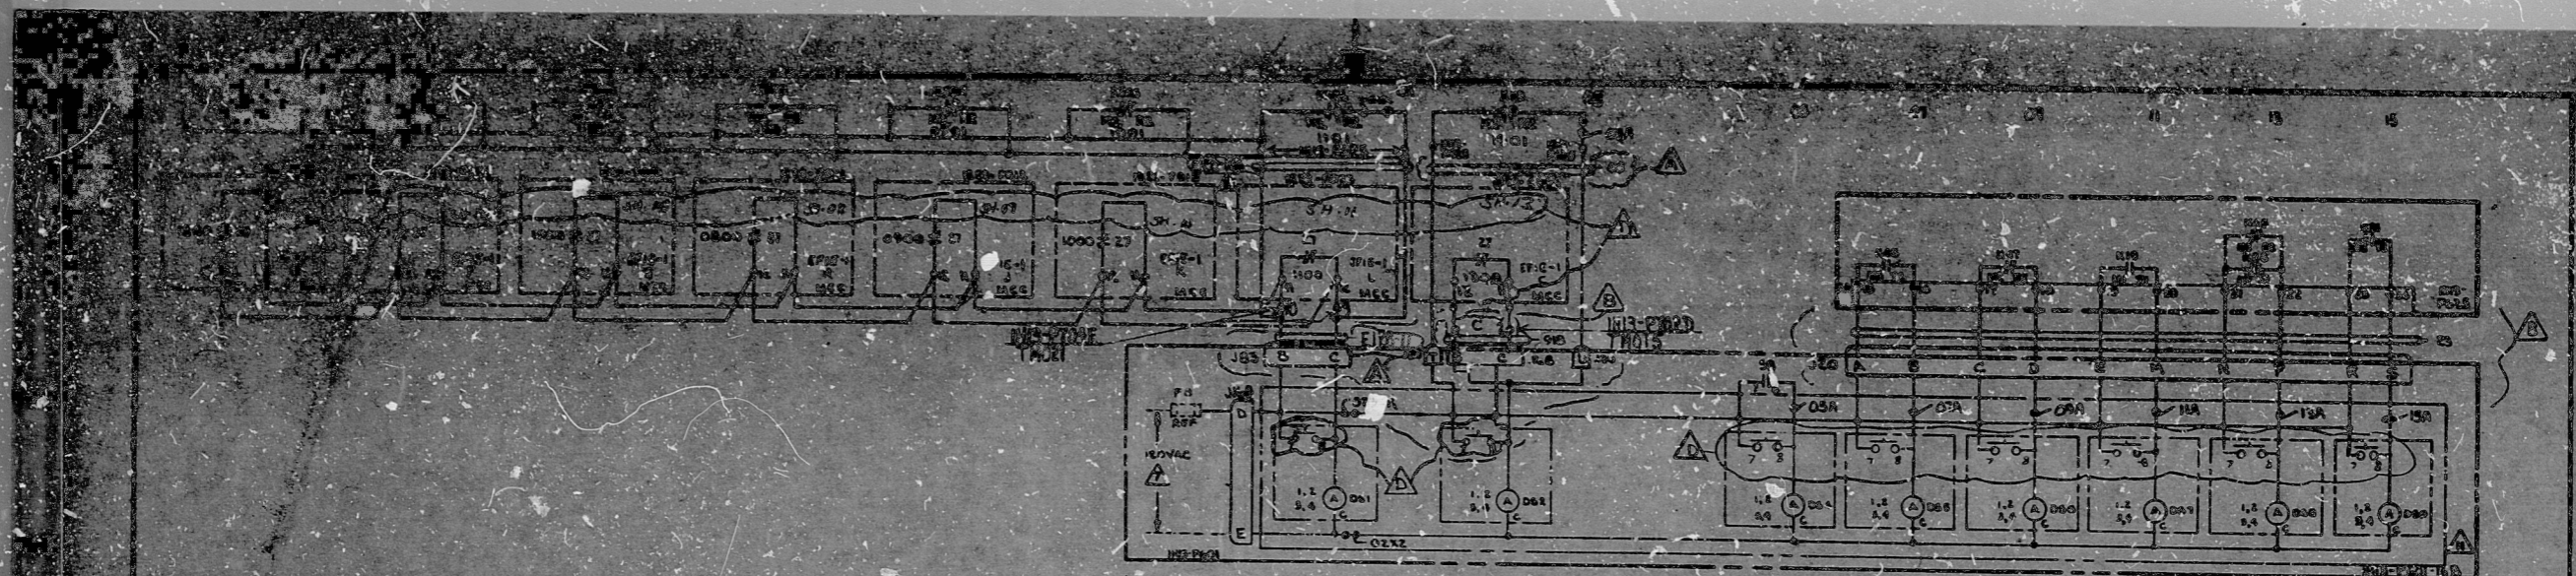

POWER LOSS AND HPCS VALVE STANBY WATER LEG PUMP ESS LOSS OVERLAY OR LOSS OF POWER HPCS OUT OF SERVICE SWITCH HPCS UNIT TRIP UNIT IN CAL OR HPCS FAILURE HPCS UNIT TRIP UNIT SET OF FILE OR POWER LOSS HPCS IN TEST STATUS HPCS LOGIC POWER FAILURE HPCS LOGIC LINE IMPACT (LEAN DETECTION)

REF
B-211-065 SH.4

PRC
APERTURE
CARD

LINE CODES 23, 40, 910

CONTRACT NO. 828536CA
SHEET NO. 6 REV. 4
ELEM DIAG
HIGH PRESSURE CORE SPRAY SYSTEM

CONSTRUCTION	TFE
PRELIMINARY	
DATE RELEASED FOR	ENGR.

NUCLEAR SAFETY RELATED
THE CLEVELAND ELECTRIC ILLUMINATING CO.
PEBBY NUCLEAR POWER PLANT UNIT 1
ELECTRICAL ELEMENTARY DIAGRAM
HIGH PRESSURE CORE SPRAY SYSTEM
STATUS LIGHTS

CHANGED CONTACTS TO PUSH-BUTTON TYPE, ADDED SH #3, ADDED PER'S, NEW TITLE Q1 AS REQ. OF I.E. Dwg.	REVERSED FITS TERM. NOS. PER 912 REVISION	ADDED FITS & LINE CODE CHANGED TERM. C.P.R. LINE CODE	REVISED LINE CODE FOR K110 & 74 RELAYS	MAKING	GILBERT ASSOCIATES, INC. ENGINEERS AND CONSULTANTS	044548-800	GRZ	01/2	DEC	TFE	6-30-77	OM	N500 10-200-025 E22	106	0
REV. MADE	CHKD	APPROVALS	DATE	REV. MADE	CHKD	APPROVALS	DATE	REV. MADE	CHKD	APPROVALS	DATE	REV. MADE	CHKD	APPROVALS	DATE

ELEM DIAG 11222A STATUS LIGHTS

RIDS

8212160520

