


8.5"
11"
17"

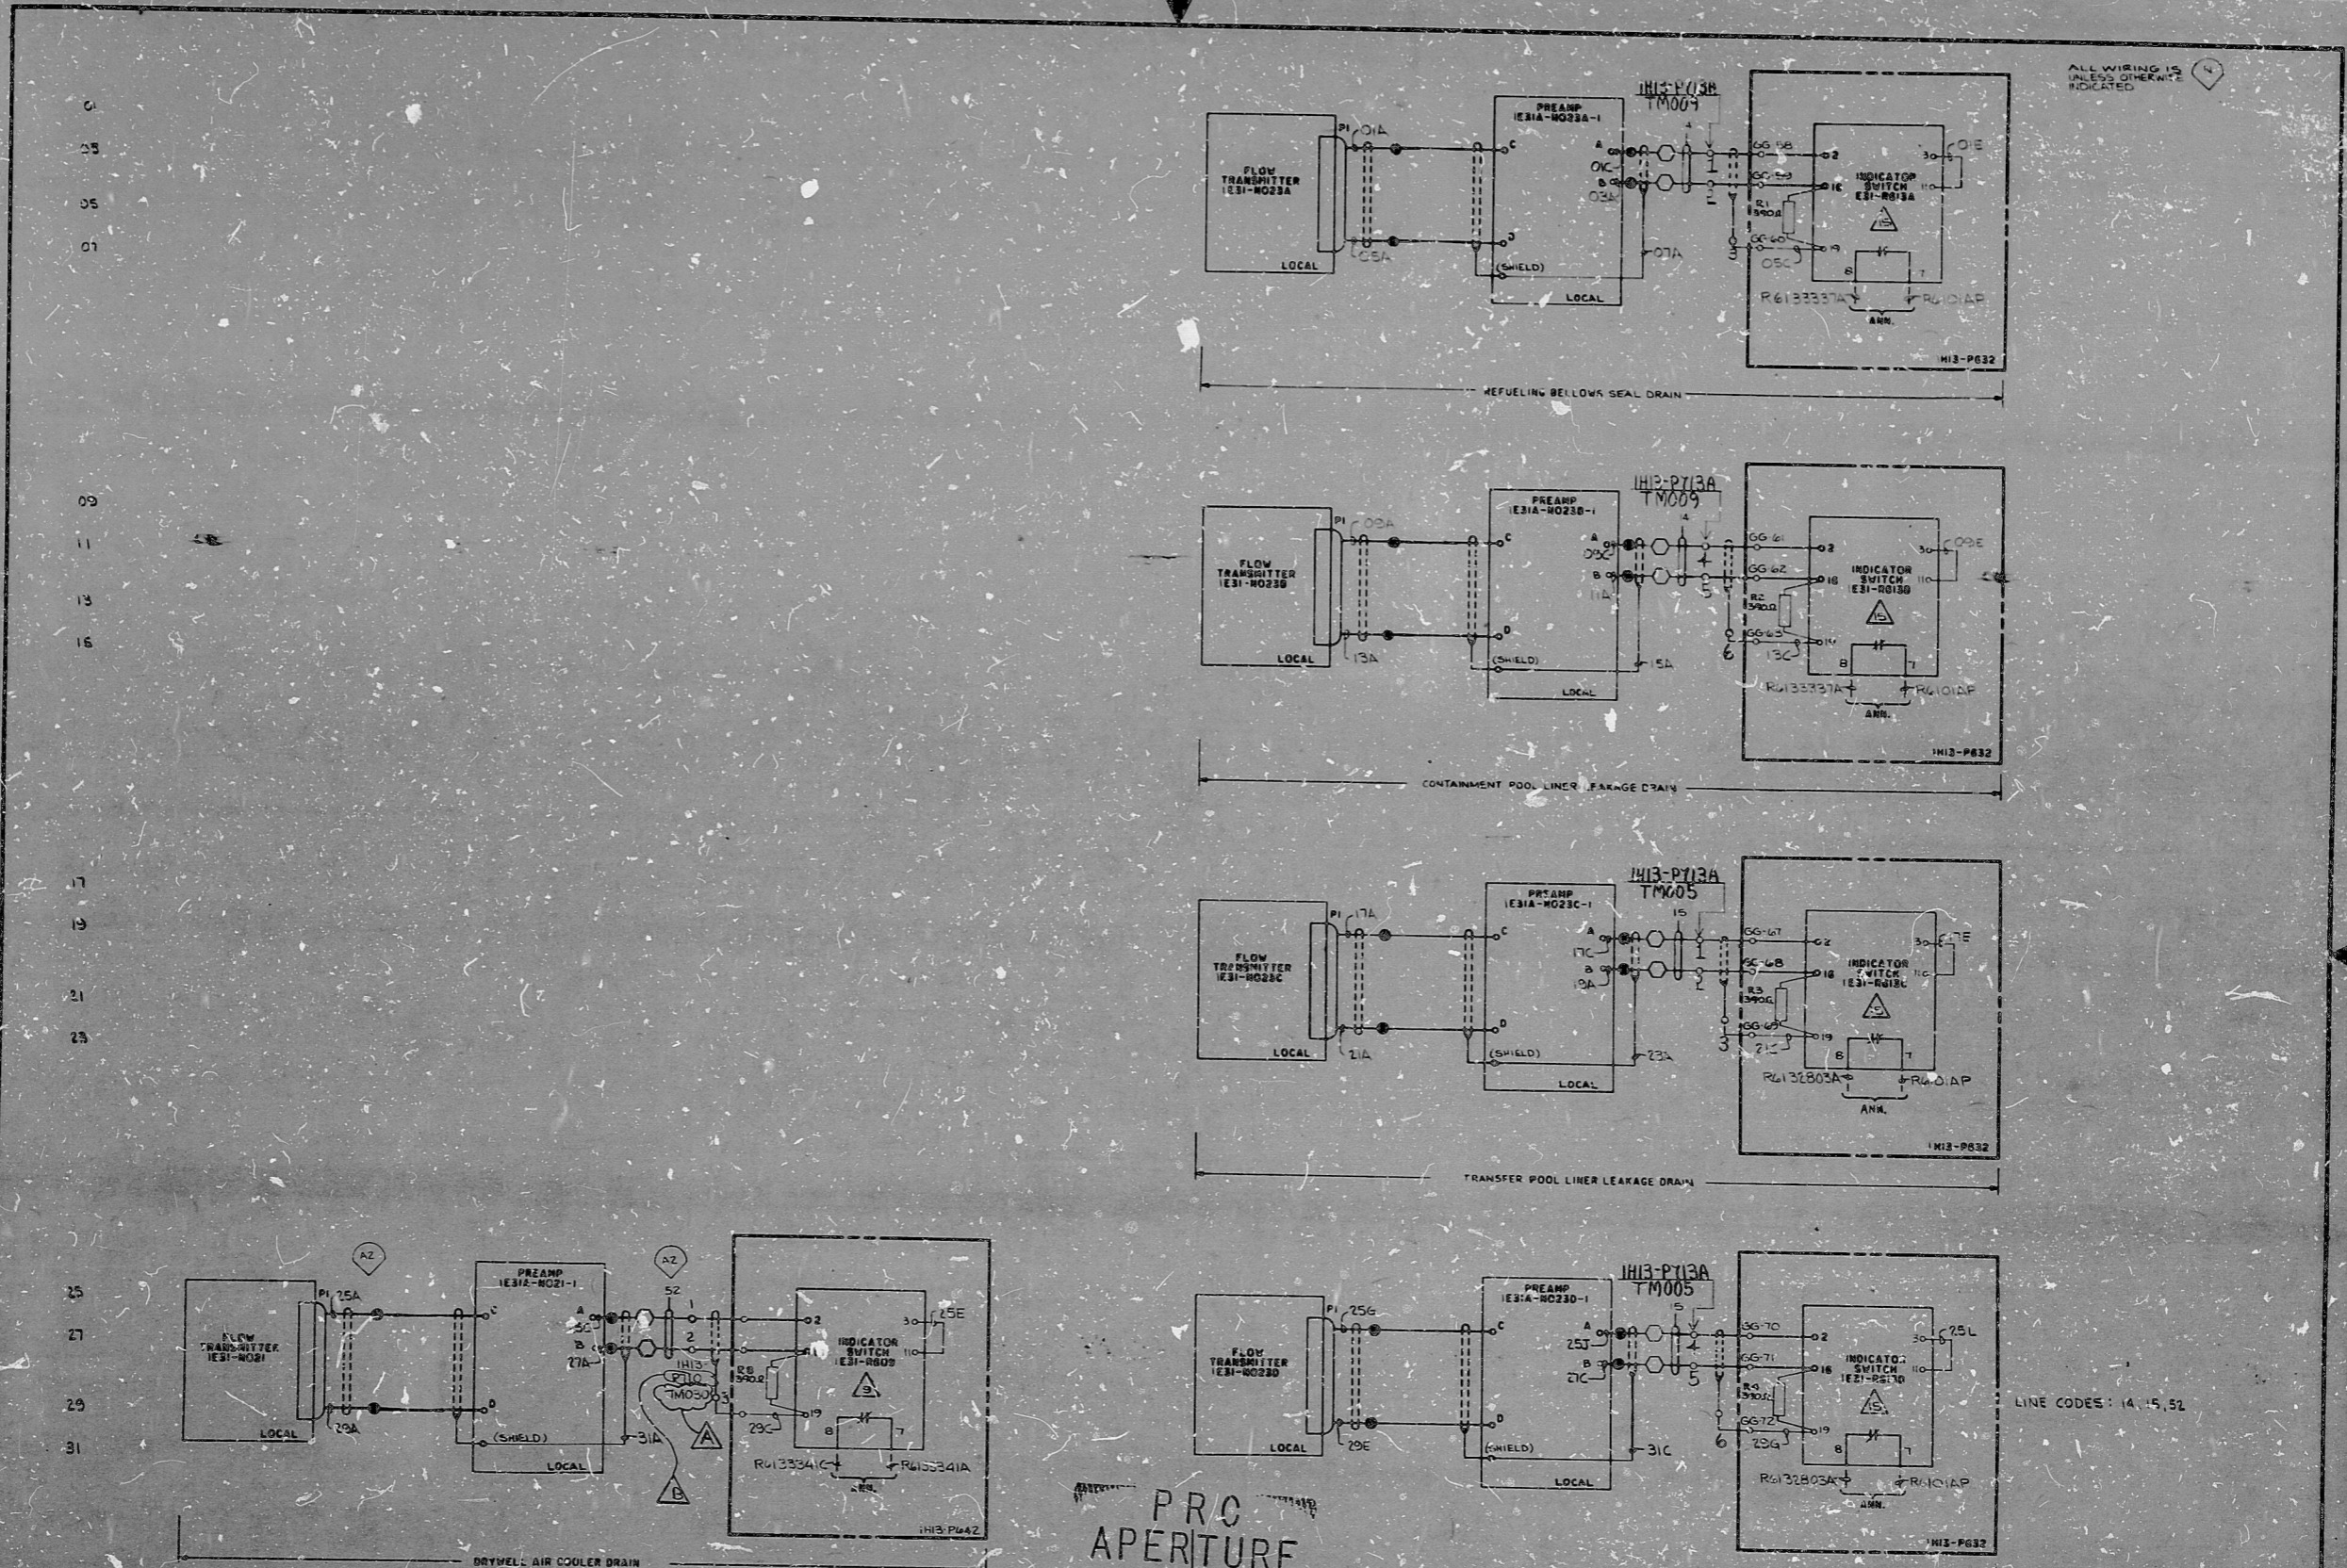

PROC APERTURE CARD

GENERAL ELECTRIC
LEAK DETECTION SYSTEM
REV. 10-79

NUCLEAR SAFETY RELATED
THE CLEVELAND ELECTRIC ILLUMINATING CO.
PERRY NUCLEAR POWER PLANT UNIT 1
ELECTRICAL-FUNDAMENTAL DIAGRAM

REV	DATE	BY	CHKD	APPROVALS	DATE	REV	DATE	BY	CHKD	APPROVALS	DATE	REV	DATE	BY	CHKD	APPROVALS	DATE	REV	DATE	BY	CHKD	APPROVALS	DATE
1						1						1						1					
2						2						2						2					
3						3						3						3					
4						4						4						4					
5						5						5						5					
6						6						6						6					
7						7						7						7					
8						8						8						8					
9						9						9						9					
10						10						10						10					
11						11						11						11					
12						12						12						12					
13						13						13						13					
14						14						14						14					
15						15						15						15					
16						16						16						16					
17						17						17						17					
18						18						18						18					
19						19						19						19					
20						20						20						20					
21						21						21						21					
22						22						22						22					
23						23						23						23					
24						24						24						24					
25						25						25						25					
26						26						26						26					
27						27						27						27					
28						28						28						28					
29						29						29						29					
30						30						30						30					
31						31						31						31					

ELECTRICAL IESIA LEAKAGE FLOW MON

NUCLEAR SAFETY RELATED
THE CLEVELAND ELECTRIC ILLUMINATING CO.
PERRY NUCLEAR POWER PLANT UNIT 1
ELECTRICAL-FUNDAMENTAL DIAGRAM
LEAK DETECTION SYSTEM
LEAKAGE FLOW MONITORS

REVISIONS
REV 1 3/1/78
REV 2 3/1/78
REV 3 3/1/78
REV 4 3/1/78
REV 5 3/1/78
REV 6 3/1/78
REV 7 3/1/78
REV 8 3/1/78
REV 9 3/1/78
REV 10 3/1/78
REV 11 3/1/78
REV 12 3/1/78
REV 13 3/1/78
REV 14 3/1/78
REV 15 3/1/78
REV 16 3/1/78
REV 17 3/1/78
REV 18 3/1/78
REV 19 3/1/78
REV 20 3/1/78
REV 21 3/1/78
REV 22 3/1/78
REV 23 3/1/78
REV 24 3/1/78
REV 25 3/1/78
REV 26 3/1/78
REV 27 3/1/78
REV 28 3/1/78
REV 29 3/1/78
REV 30 3/1/78
REV 31 3/1/78

DATE 3/1/78
CONSTRUCTION 1/78
PRELIMINARY
RELEASED FOR ENGR.

CHILBERT ASSOCIATES, INC.
ENGINEERS AND CONSULTANTS
844549-000
JES RAM DEG JMD
3/1/78
4549 15-208-070 E31 A08
DRAWING NUMBER SYSTEM OR INC. OR

RIPS

82L2160615

