

11

11

8.5

8.5

11

17

11


11

8.5

8.5

11

17

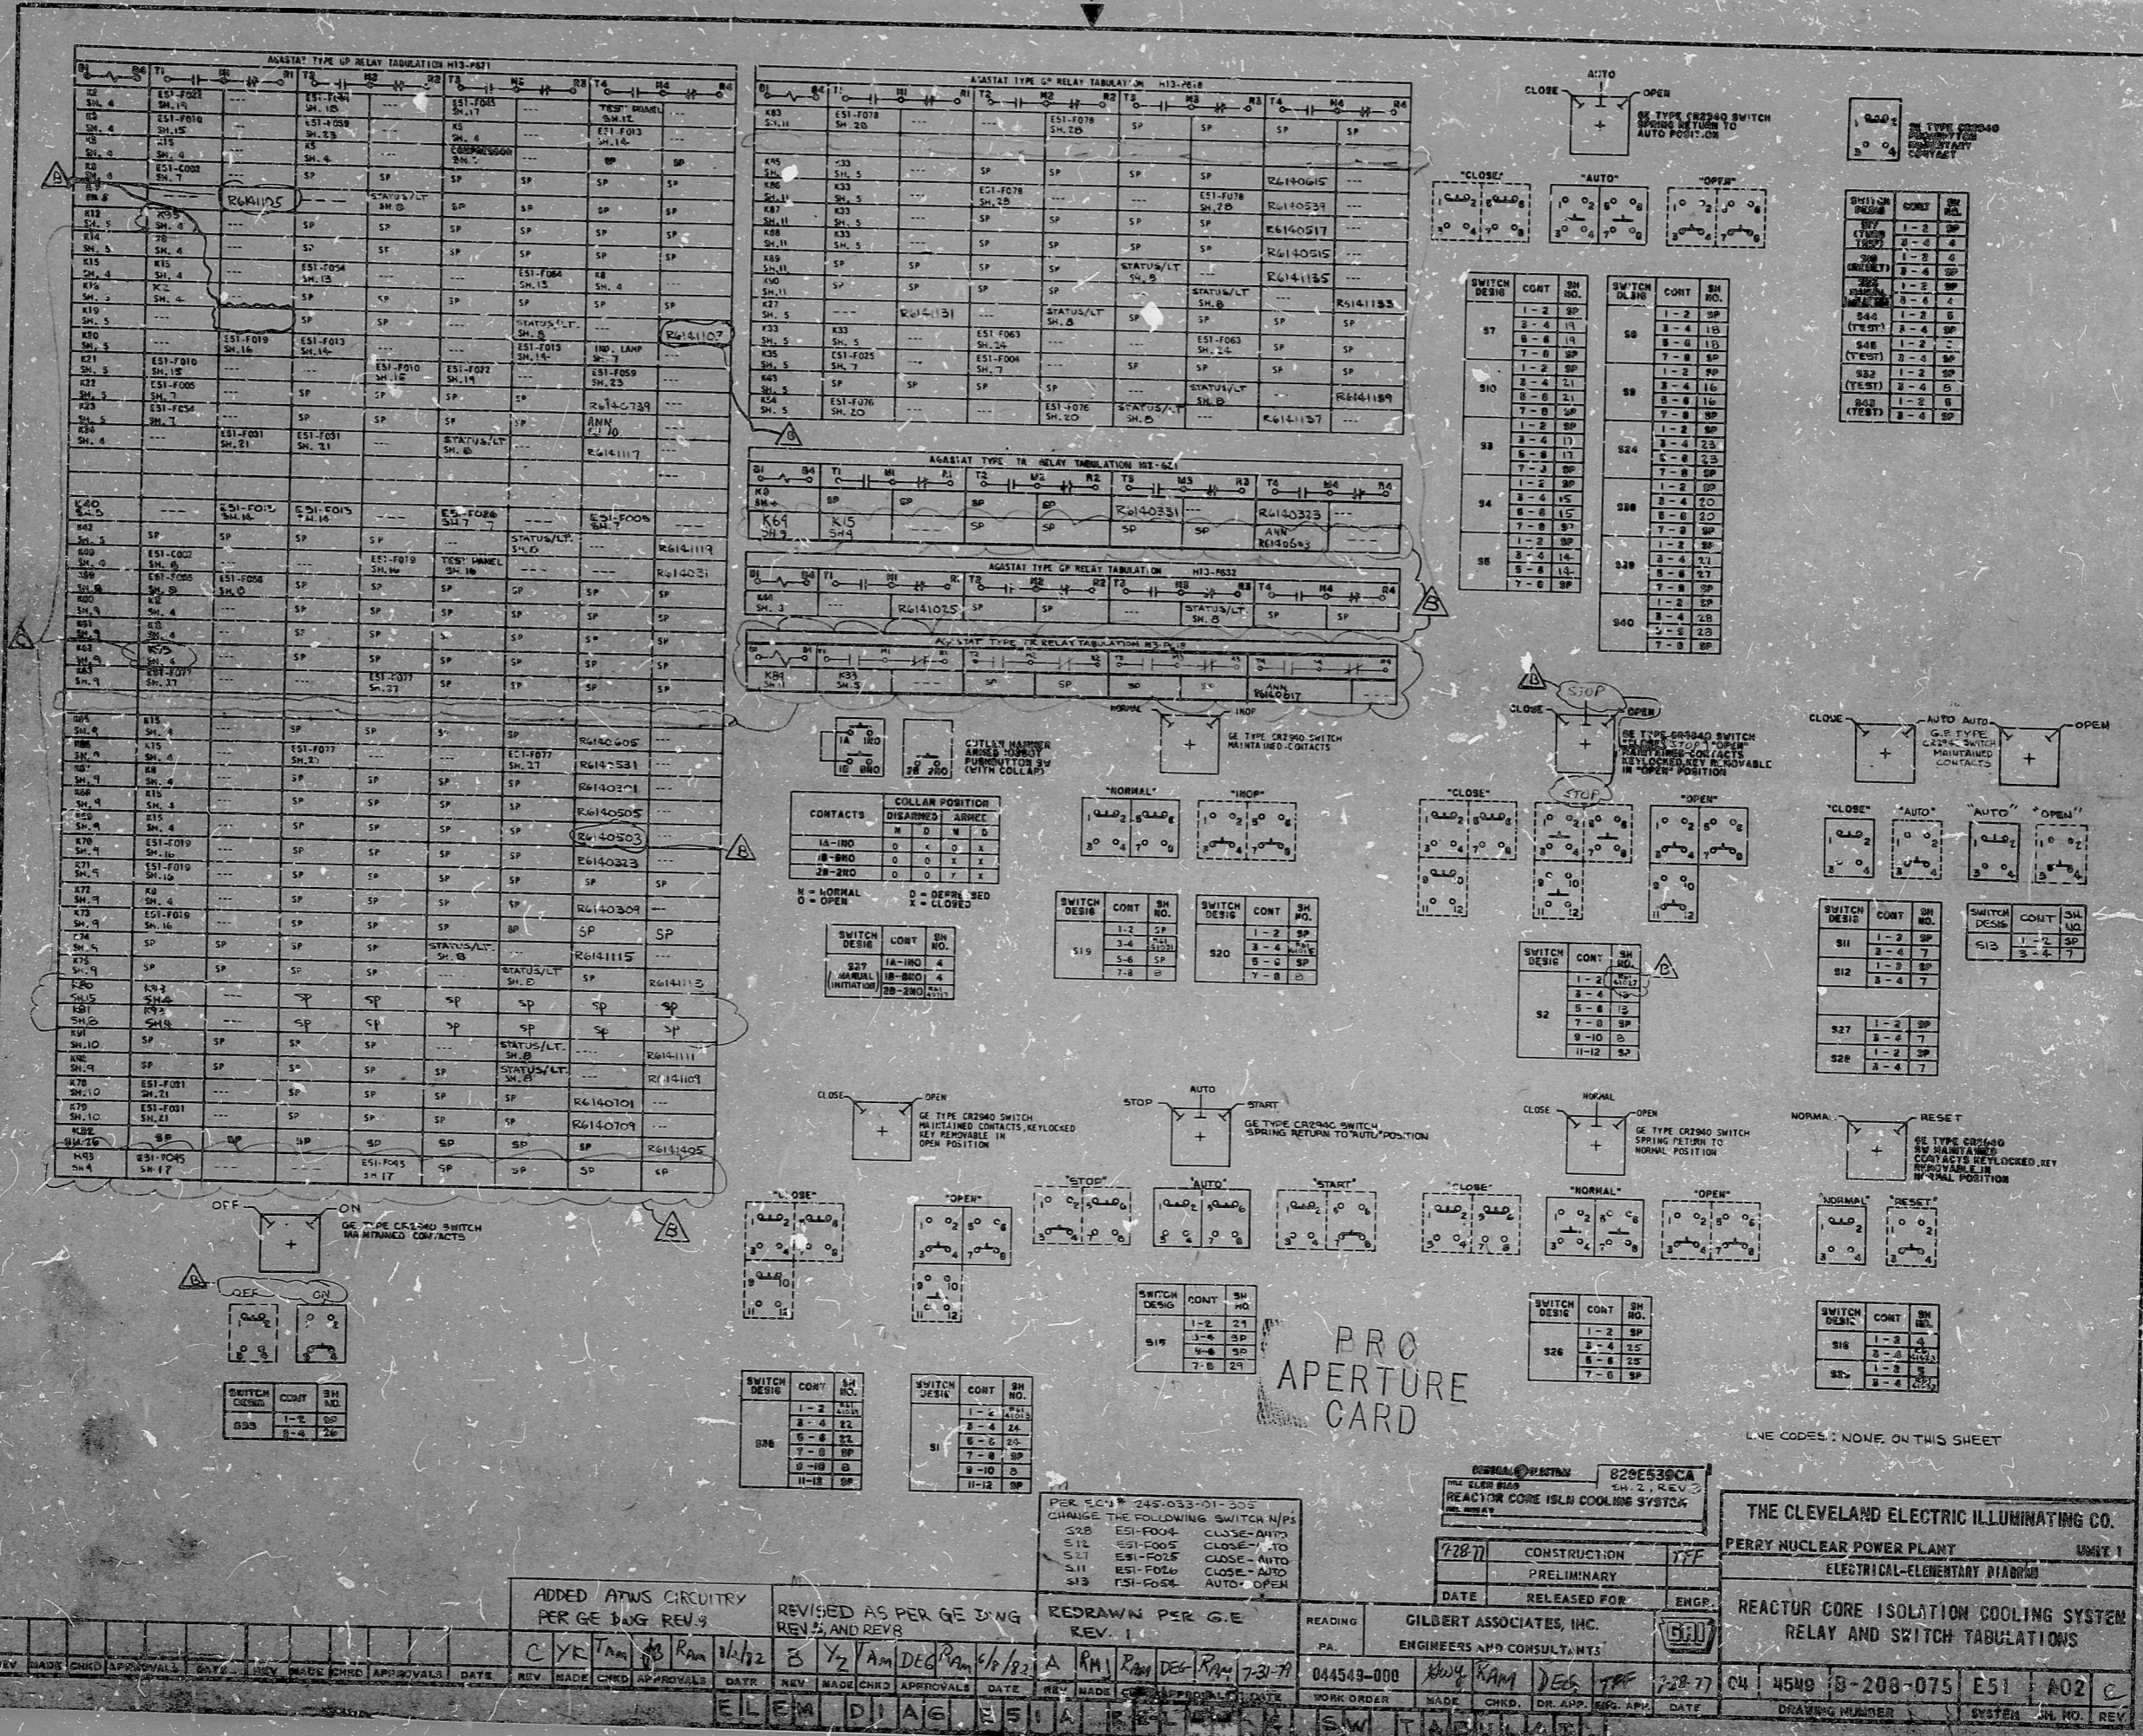

PRO APERTURE CARD

LINE CODES: NONE ON THIS SHEET

REV. MADE	CHKD	APPROVALS	DATE	REV. MADE	CHKD	APPROVALS	DATE	REV. MADE	CHKD	APPROVALS	DATE	REV. MADE	CHKD	APPROVALS	DATE	REV. MADE	CHKD	APPROVALS	DATE

ADDED APNS CIRCUITRY PER GE Dwg REV. 3	REVISED AS PER GE Dwg REV. 2 AND REV. 1	REDRAWN PER GE REV. 1	READING PA	GILBERT ASSOCIATES, INC. ENGINEERS AND CONSULTANTS
CYE Tam Ram 11/12	B Y2 Am Dec Ram 1/6/82	A RM Ram Dec Ram 7/31/71	044549-000	MADE CHKD DR. APP. DATE

820E530CA SH. 2, REV. 2	REACTOR CORE ISOLATION COOLING SYSTEM
72877	CONSTRUCTION
	PRELIMINARY
	RELEASED FOR ENGR.
THE CLEVELAND ELECTRIC ILLUMINATING CO.	PERRY NUCLEAR POWER PLANT UNIT 1
ELECTRICAL-ELEMENTARY DIAGRAM	
REACTOR CORE ISOLATION COOLING SYSTEM RELAY AND SWITCH TABULATIONS	
04	4549
18-208-075	E51 A02 C
DRAWING NUMBER	SYSTEM SH. NO. REV.

RIDS

82.12.160671

