

11

11

5.8

8.5"

11"

17

11


11

5.8

8.5"

11"

17

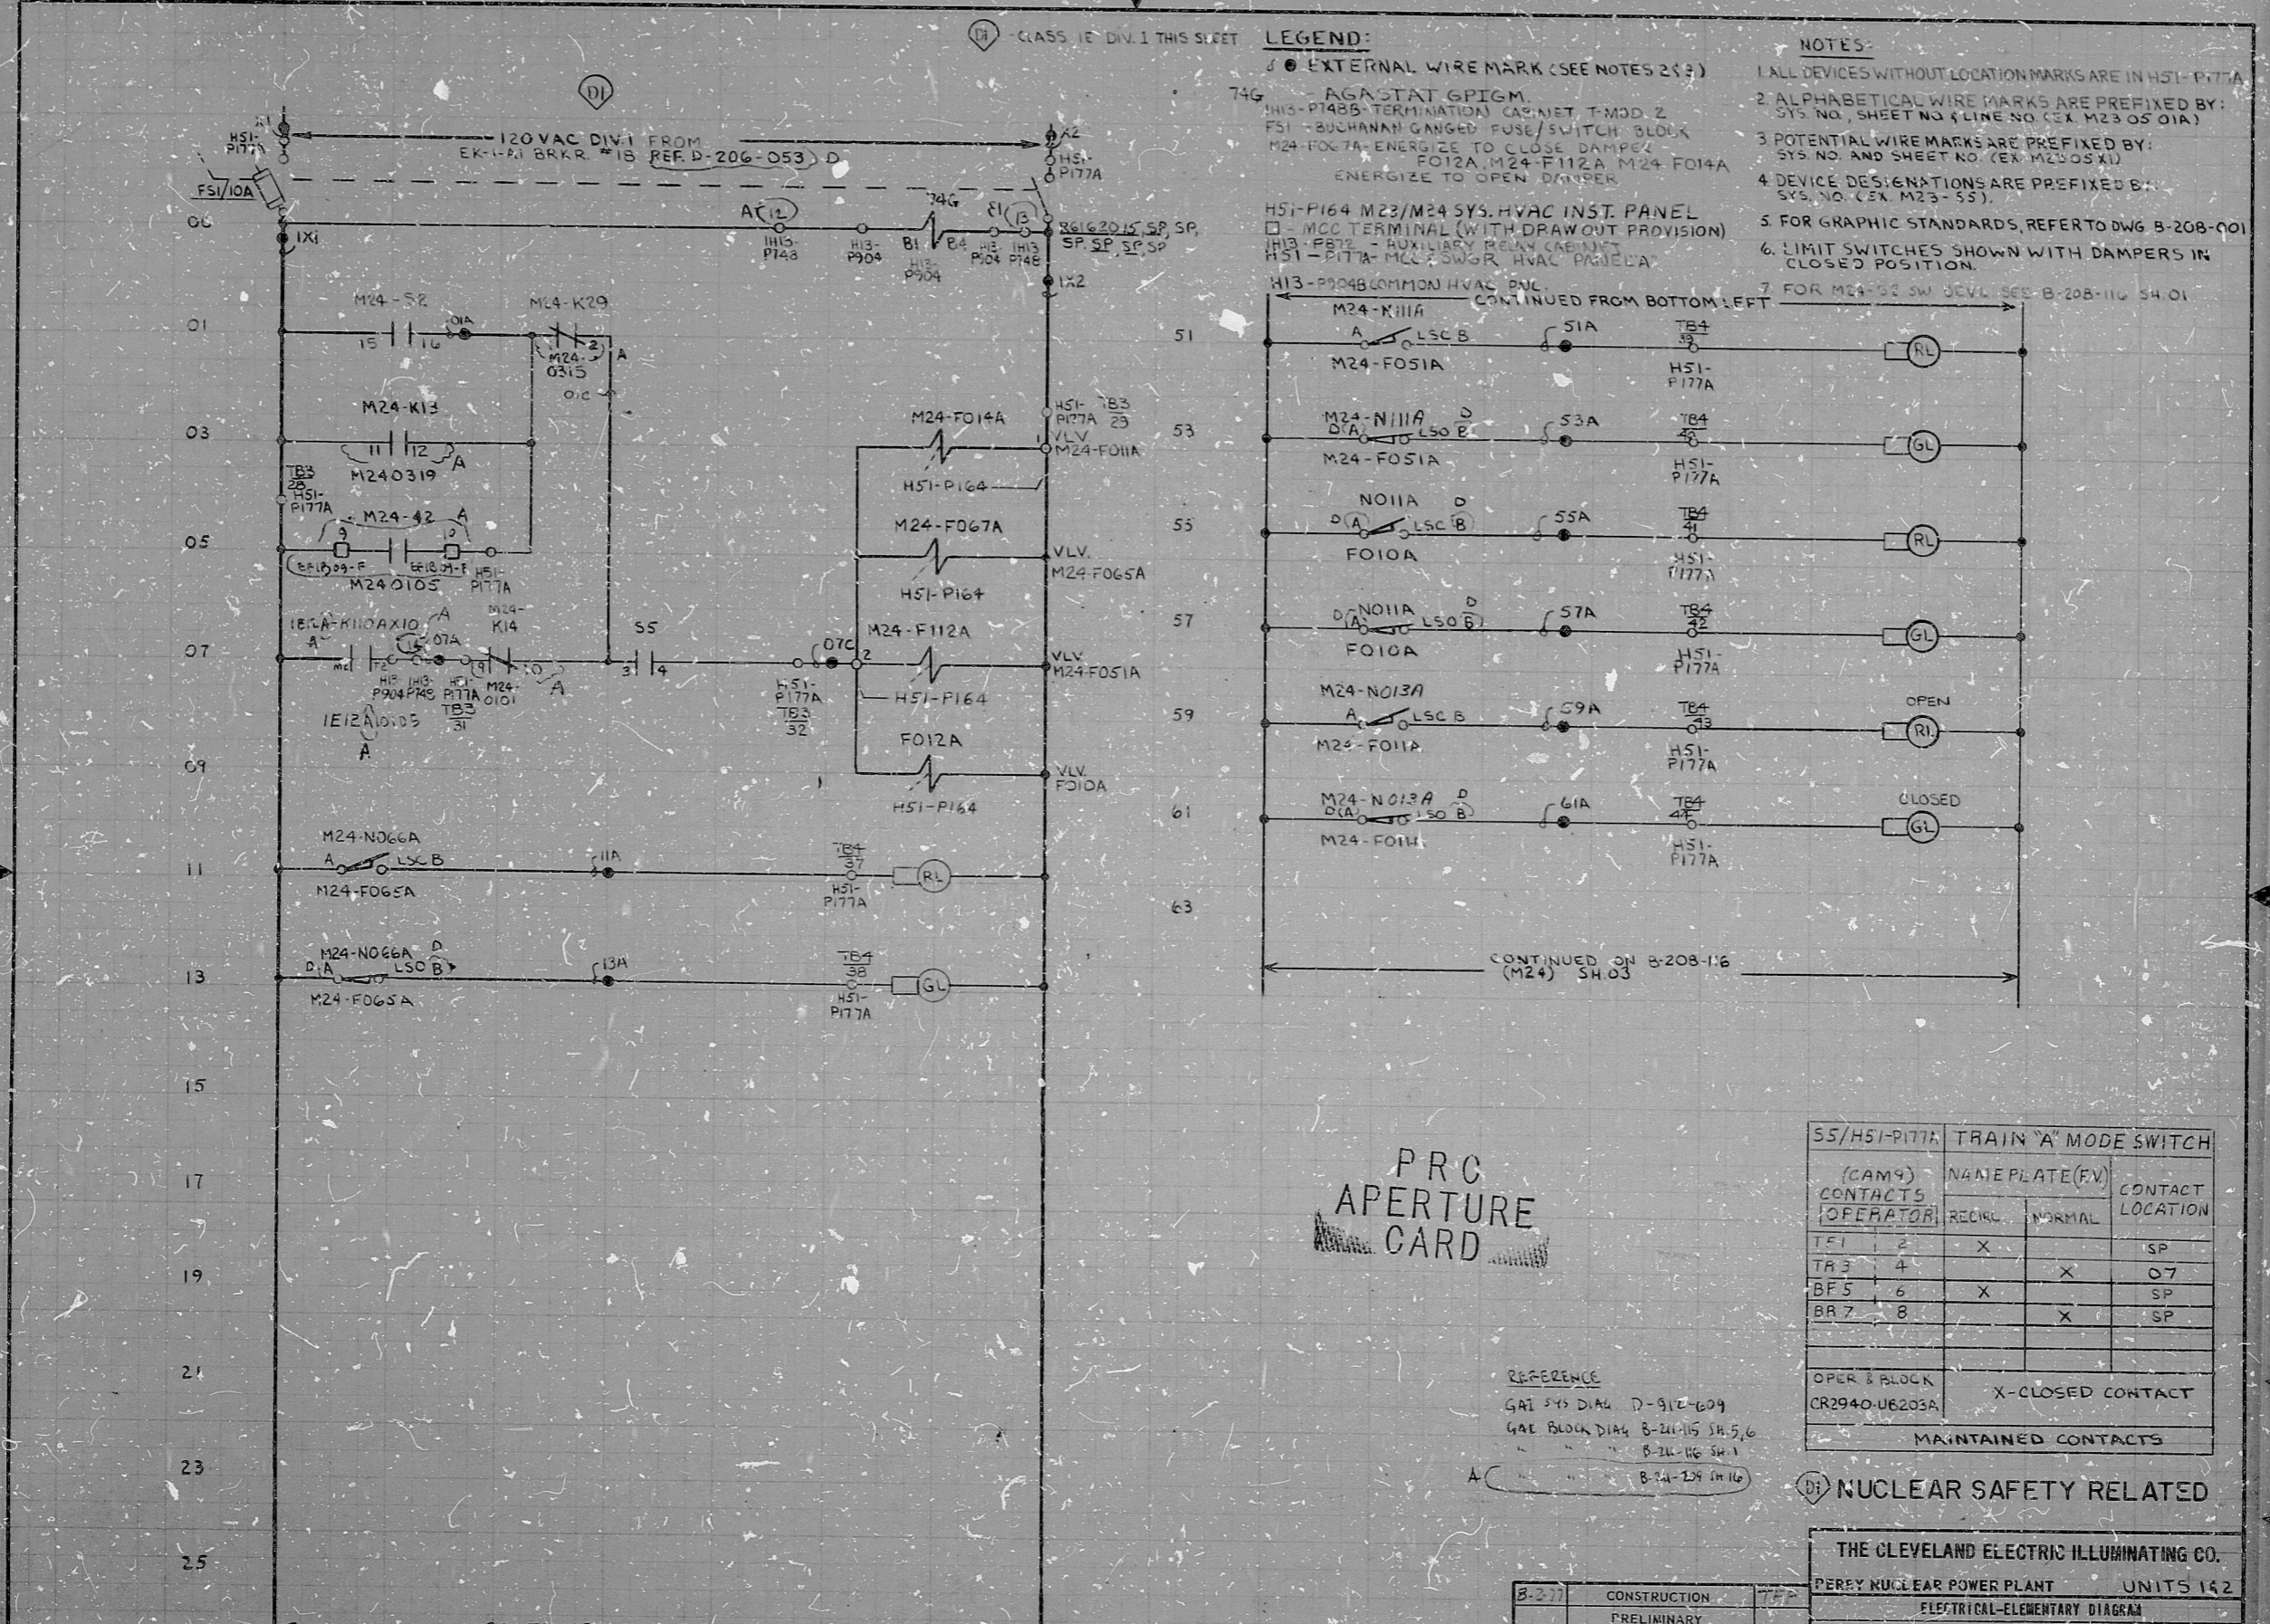

PRC APERTURE CARD

REFERENCE

GAI 543 DIAL D-912-609

GAE BLOCK DIA4 B-211-15 SH.5,6

" " " B-211-16 SH.1

" " " B-211-19 SH.16

55/H51-P177A TRAIN "A" MODE SWITCH		NAMEPLATE (FV)		CONTACT LOCATION
(CAM) CONTACTS OPERATOR		REC'D	NORMAL	
TS1	2	X		SP
TR3	4		X	O7
BF5	6	X		SP
BR7	8		X	SP
OPER BLOCK CR2940-UB203A		X-CLOSED CONTACT		
MAINTAINED CONTACTS				

NUCLEAR SAFETY RELATED

THE CLEVELAND ELECTRIC ILLUMINATING CO.	
PEREY NUCLEAR POWER PLANT UNITS 1&2	
ELECTRICAL-ELEMENTARY DIAGRAM	
MCC SWITCHGEAR MISC ELECTRICAL EQUIPMENT AREA, HVAC SYSTEMS MISC SOLENOID DAMPERS "A"	
DRAWING NUMBER	SYSTEM SH. NO. REV.
04 45119 B-208-115	M23 05 D

ADDED REV. CONTACTS, ADDED REF.		ADDED T-MOD 2, TERMINAL POINTS		ADDED H51-P164 TERM. IN 23		ADDED FTS ADDED STUDY B REL. TO M24-52 (LINE 05) APPROV. 14		READING PA		GILBERT ASSOCIATES, INC. ENGINEERS AND CONSULTANTS		DATE		DATE	
D	T.P.	C	CAG	RAM	DEG	10-11-79	B	DES	11-1-79	044543-900	RAM	DEG	TFE	B-217	04 45119 B-208-115 M23 05 D
REV	MADE	CHKD	APPROVALS	DATE	REV	MADE	CHKD	APPROVALS	DATE	WORK ORDER	MADE	CHKD	DR. APP.	ENG. APP.	DATE
ELEM DIAG MISC SOL DAMPER A															

RIDS

82LR170 332

