

11

11

11

11

8.5

8.5

8.5


8.5

11

11

11

11

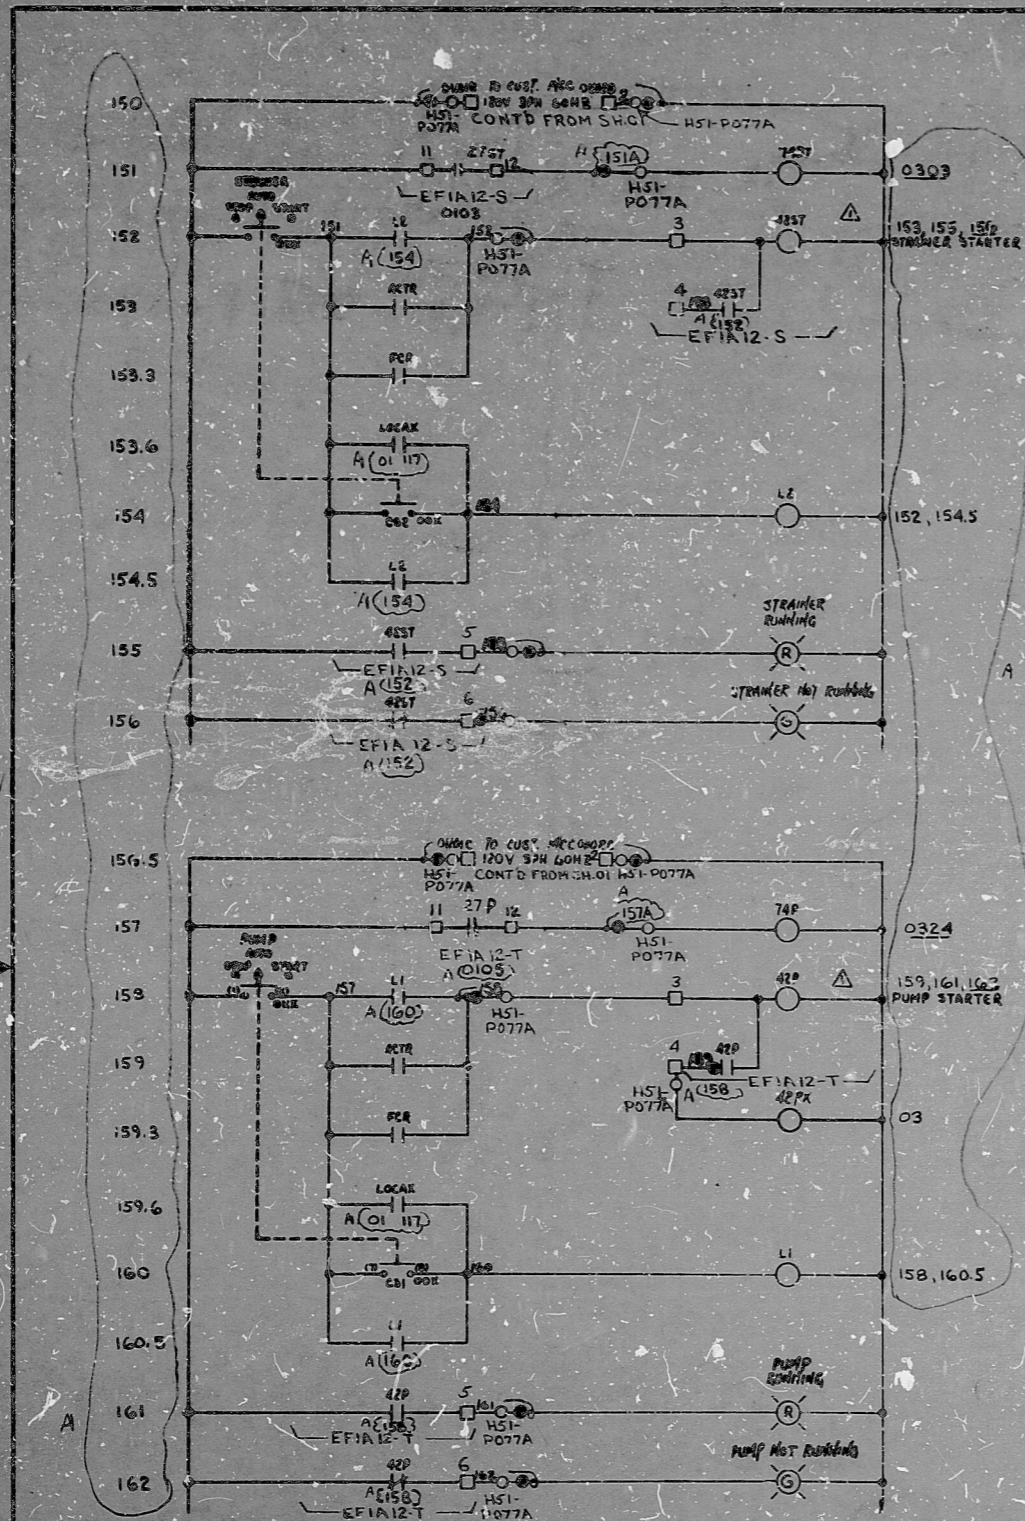

- NOTES:-**
1. ALL DEVICES WITHOUT LOCATION MARKS ARE LOCATED IN H51-P077A
  2. ALPHABETICAL WIRE MARKS ARE PREFIXED BY SYSTEM NO. AND SHEET NO. (EXAMPLE: P490201A)
  3. POTENTIAL WIRE MARKS ARE PREFIXED BY SYSTEM NO. AND SHEET NO. (EXAMPLE: P490202)
  4. DEVICE DESIGNATIONS ARE PREFIXED BY SYSTEM NO. (EXAMPLE: P49-052)

- LEGEND:-**
- ( ) EXTERNAL WIRE MARK
  - [ ] MCC TERMINAL (WITH PULL OUT PROVISION)
  - (D) CLASS 1F, DIVISION 1
  - A H51-P077A EMERGENCY SERVICE WATER SCREEN CONTROL STATION "A"

**REFERENCES:-**  
B-211-1ED SHEETS 1 AND 5, BLOCK DIAGRAM

PRC  
APERTURE  
CARD

PL. TRAINING	
CONFIDENTIAL - ALL RIGHTS RESERVED - PROPERTY OF	
General Inc.	
DEFENSE GENERAL ELECTRIC SERVICE	
DATE: 12-1-77	BY: PMS
SCHEMATIC DRAWING FOR STRAINER & PUMP IE	
DRAWING NO. H99408 D56-753	

NUCLEAR SAFETY RELATED

THE CLEVELAND ELECTRIC ILLUMINATING CO.

PERRY NUCLEAR POWER PLANT UNITS 1&2

ELECTRICAL-ELEMENTARY DIAGRAM

EMERGENCY SERVICE WATER SCREEN WASH STRAINER P49-D003A AND PUMP P49-C002A

ADDED RELAY REF'S, LINE REF'S, LEGEND & REF. REV. WIRE MARKS. N/A

REV	MADE	CHKD	APPROVALS	DATE	REV	MADE	CHKD	APPROVALS	DATE	REV	MADE	CHKD	APPROVALS	DATE	REV	MADE	CHKD	APPROVALS	DATE
	A	T	P	M					11-10-81										

WORK ORDER	PA	044549-000	DPS	RAM	DEG	MIS	11-17-78
------------	----	------------	-----	-----	-----	-----	----------

04	4549	B-208-180	P49	02	A
----	------	-----------	-----	----	---

DRAWING NUMBER SYSTEM SH. NO. REV.

ELEM DIAG P49-D003A P49-C002A

GAI 7013

Rid's

8212170464

