

17"

11"

8.5"

8.5"

11"

17"

17"


11"

8.5"

8.5"

11"

17"

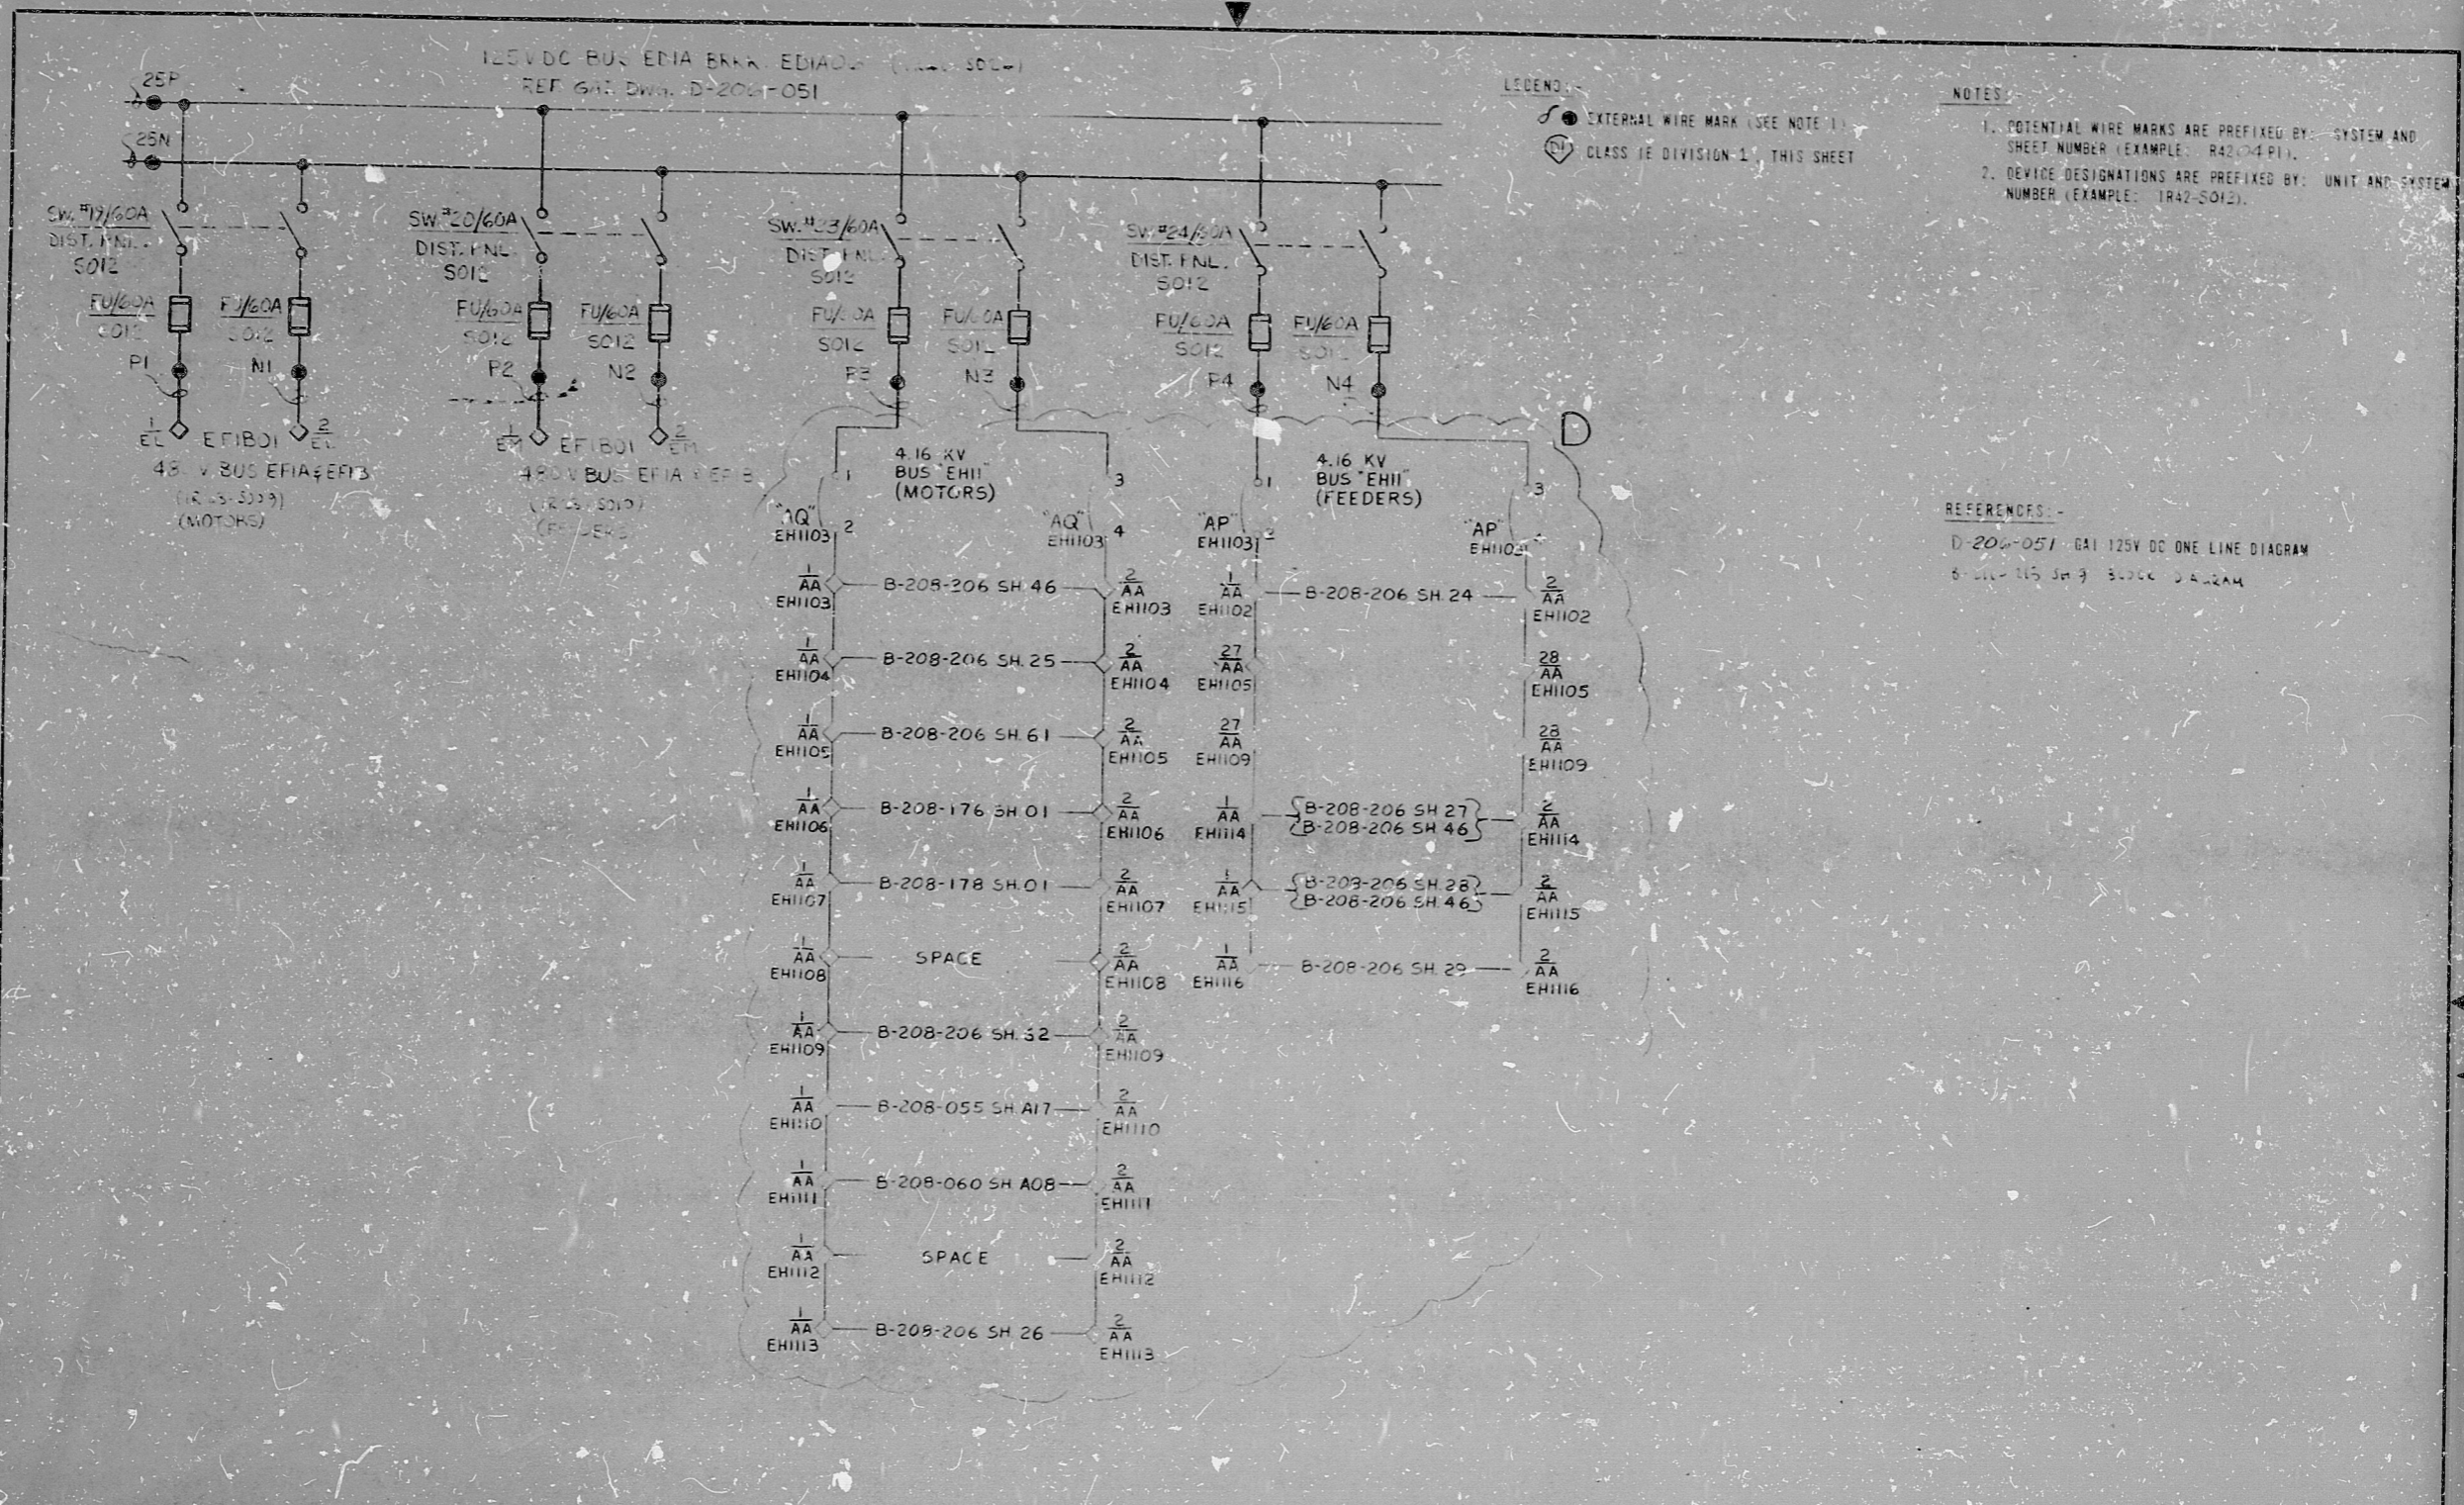

PRC APERTURE CARD

NUCLEAR SAFETY RELATED

THE CLEVELAND ELECTRIC ILLUMINATING CO.

PERRY NUCLEAR POWER PLANT UNIT 1

ELECTRICAL-ELEMENTARY DIAGRAM

D.C. SYSTEM

DISTRIBUTION PANEL R42-S012 SWITCH AND FEEDS

REVISED 1 PLACE PER ECN 8853-86-131	ADDED TERM 2 INT	REV. W 8/10/50	ADDED SW. AT N-3 & SOI. B. AT 208	READING PA	GILBERT ASSOCIATES, INC. ENGINEERS AND CONSULTANTS	044549-000	04	4549	B-208-206	R42	04	D
REV. MADE CHKD APPROVALS DATE	REV. MADE CHKD APPROVALS DATE	REV. MADE CHKD APPROVALS DATE	REV. MADE CHKD APPROVALS DATE	REV. MADE CHKD APPROVALS DATE	REV. MADE CHKD APPROVALS DATE	REV. MADE CHKD APPROVALS DATE	REV. MADE CHKD APPROVALS DATE	REV. MADE CHKD APPROVALS DATE	REV. MADE CHKD APPROVALS DATE	REV. MADE CHKD APPROVALS DATE	REV. MADE CHKD APPROVALS DATE	REV. MADE CHKD APPROVALS DATE
D	W	Rw	Rw	205	205	205	205	205	205	205	205	205

DRAWING NUMBER SYSTEM SH NO REV

Rids

82L2210554

