

11

8.5

8.5

11

17

17


11

8.5

8.5

11

17

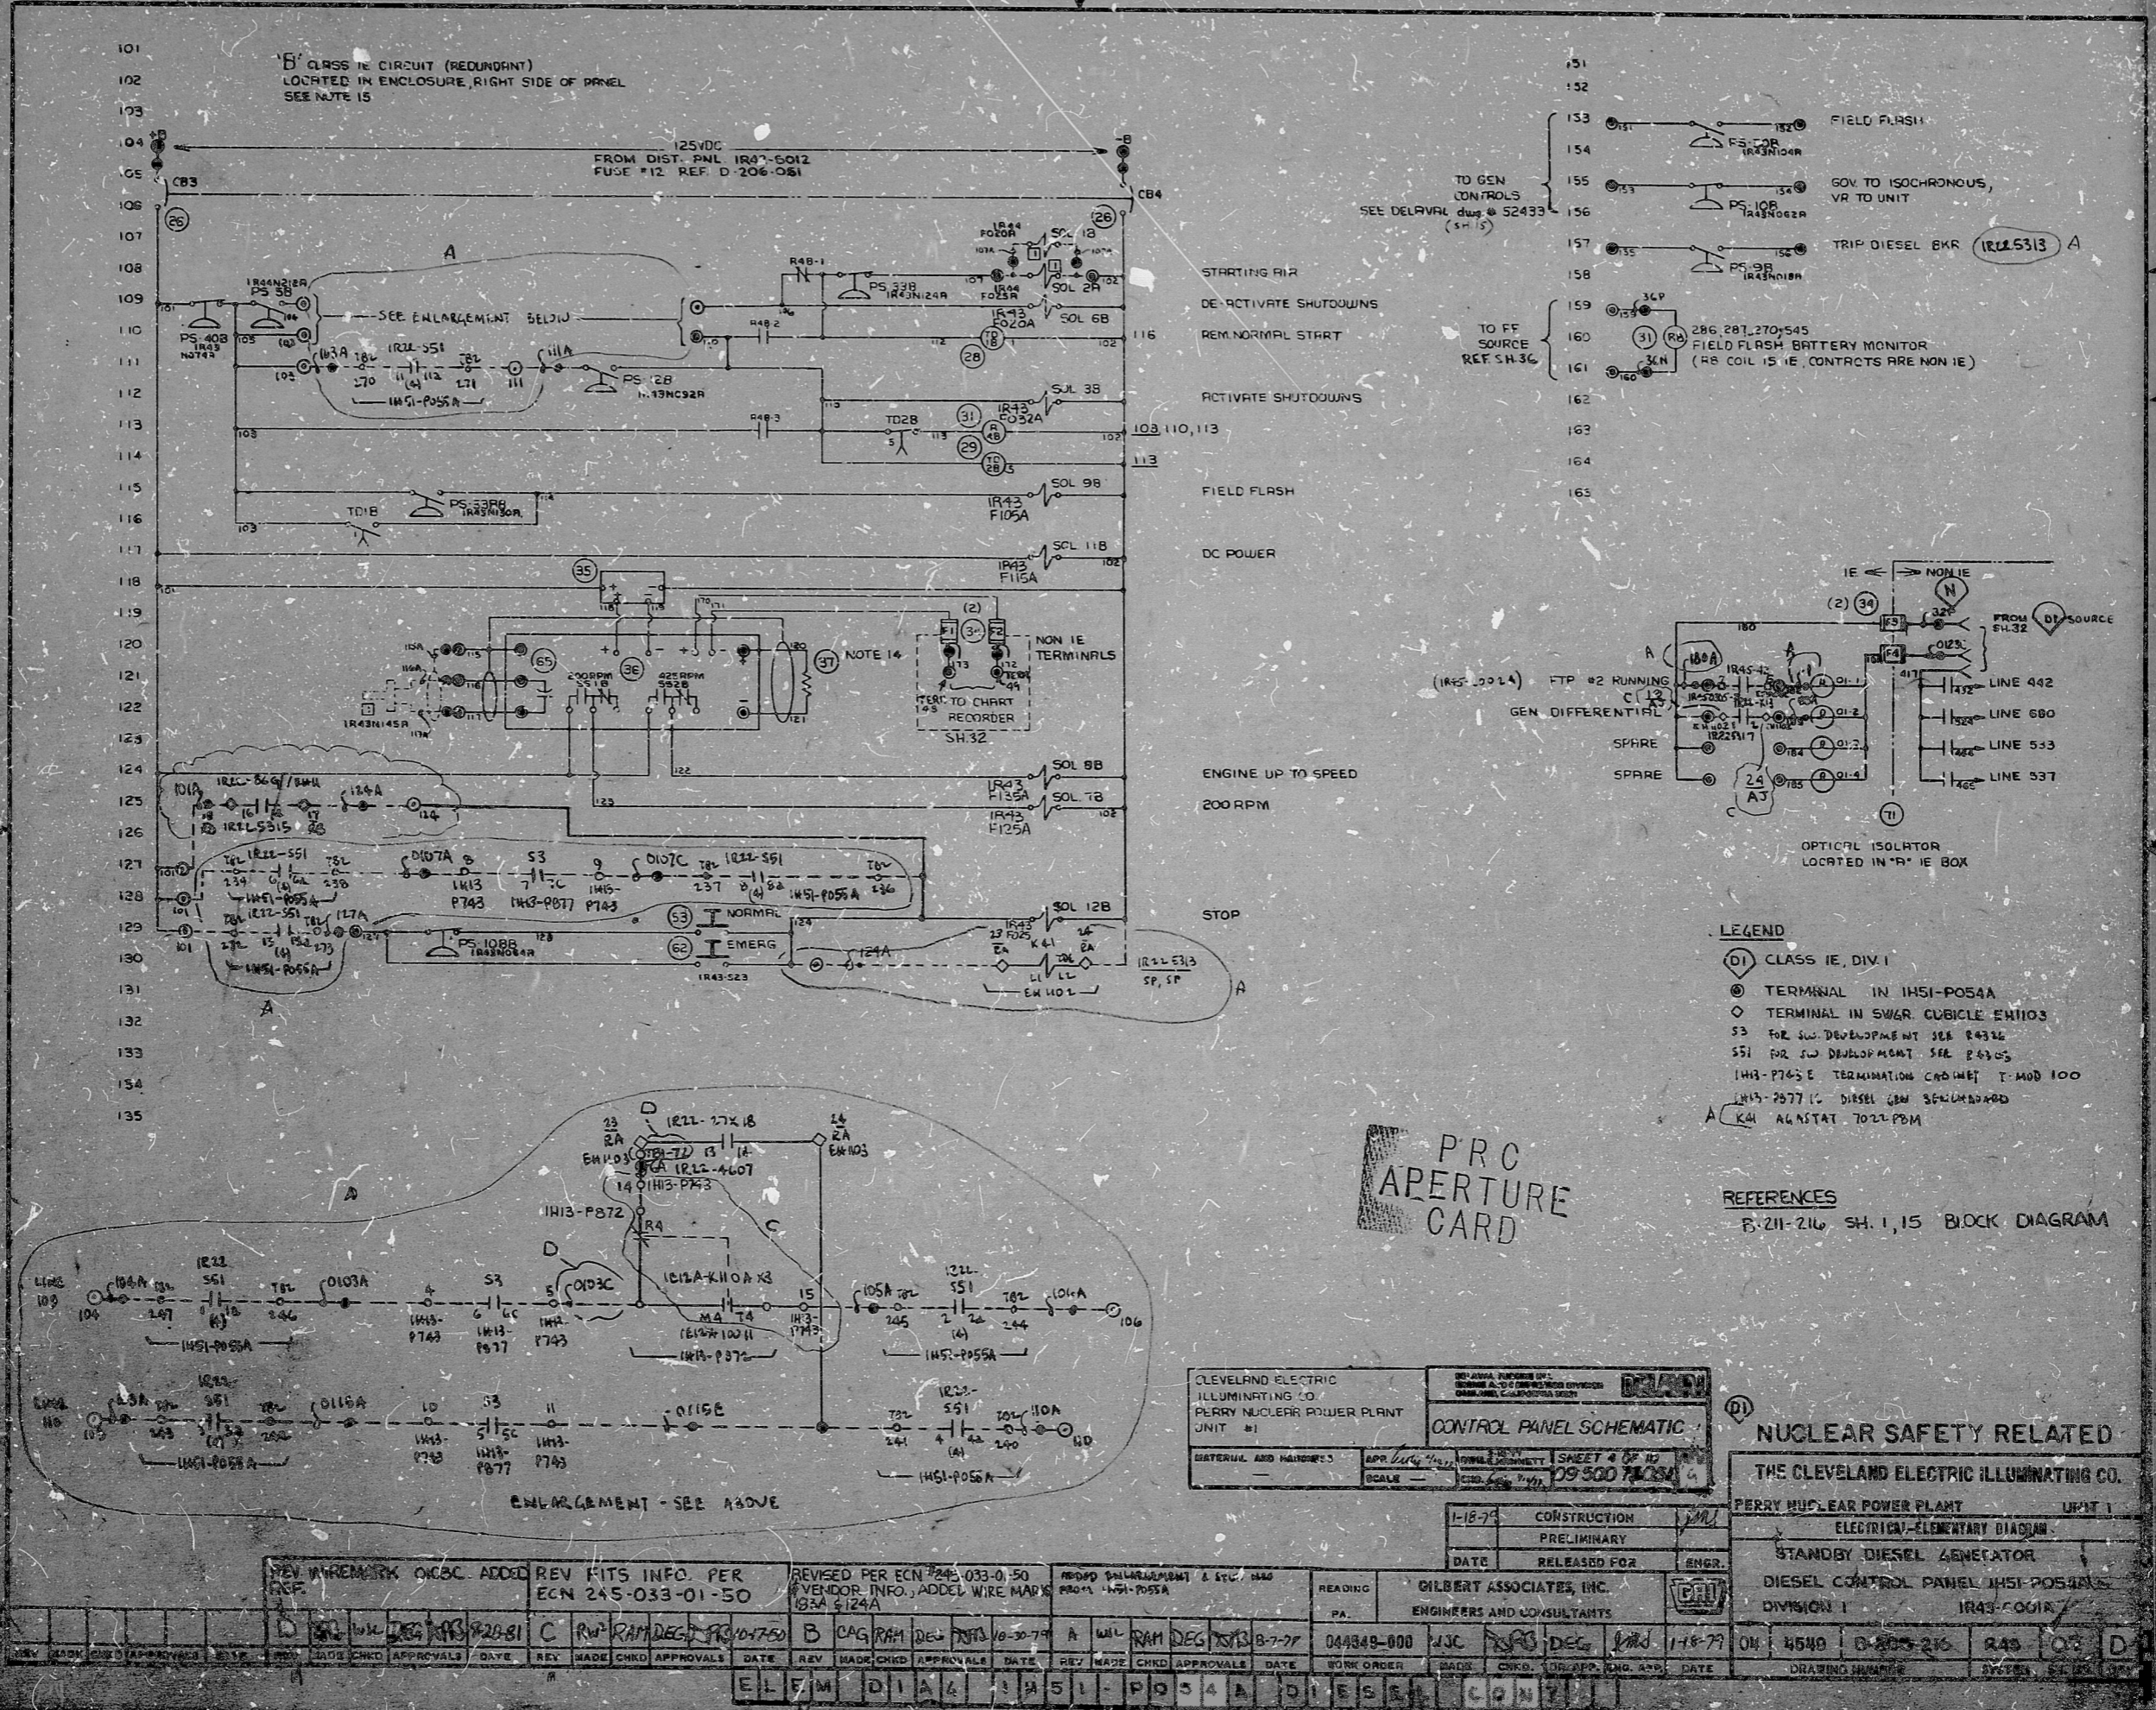

- LEGEND**
- (DI) CLASS I.E., DIV. I
 - ⊙ TERMINAL IN IHSI-POS4A
 - ⊙ TERMINAL IN SWGR CUBICLE ENT103
 - S3 FOR SW DEVELOPMENT SEE P4336
 - S51 FOR SW DEVELOPMENT SEE P4305
 - IHSI-P745 E TERMINATION CAPACITOR T-MOD 100
 - IHSI-P877 C DIESEL GEN 36V STANDARD
 - A K41 ALNSTAT 7022 PDM

REFERENCES
 B-211-216 SH-1,15 BLOCK DIAGRAM

PRC
 APERTURE
 CARD

CLEVELAND ELECTRIC ILLUMINATING CO.
 PERRY NUCLEAR POWER PLANT UNIT #1
CONTROL PANEL SCHEMATIC
 SHEET 4 OF 10
 DATE: 1-18-79
 SCALE: AS SHOWN

(DI) **NUCLEAR SAFETY RELATED**
 THE CLEVELAND ELECTRIC ILLUMINATING CO.
 PERRY NUCLEAR POWER PLANT UNIT #1
 ELECTRICAL-ELEMENTARY DIAGRAM
 STANDBY DIESEL GENERATOR
 DIESEL CONTROL PANEL IHSI-POS4A
 DIVISION 1
 IR43-CO01R

REV	DATE	BY	CHKD	APPROVALS	DATE	REV	DATE	BY	CHKD	APPROVALS	DATE	REV	DATE	BY	CHKD	APPROVALS	DATE	REV	DATE	BY	CHKD	APPROVALS	DATE	
1	1-18-79	JJC	DEC	1-18-79	1	1-18-79	JJC	DEC	1-18-79	1	1-18-79	JJC	DEC	1-18-79	1	1-18-79	JJC	DEC	1-18-79	1	1-18-79	JJC	DEC	1-18-79

ELEM DIA 4 IHSI-POS4A DIESEL CONT

Rids

8212210567

