

11

11

9.8

8.8

11

17

11


11

9.8

8.5

11

17

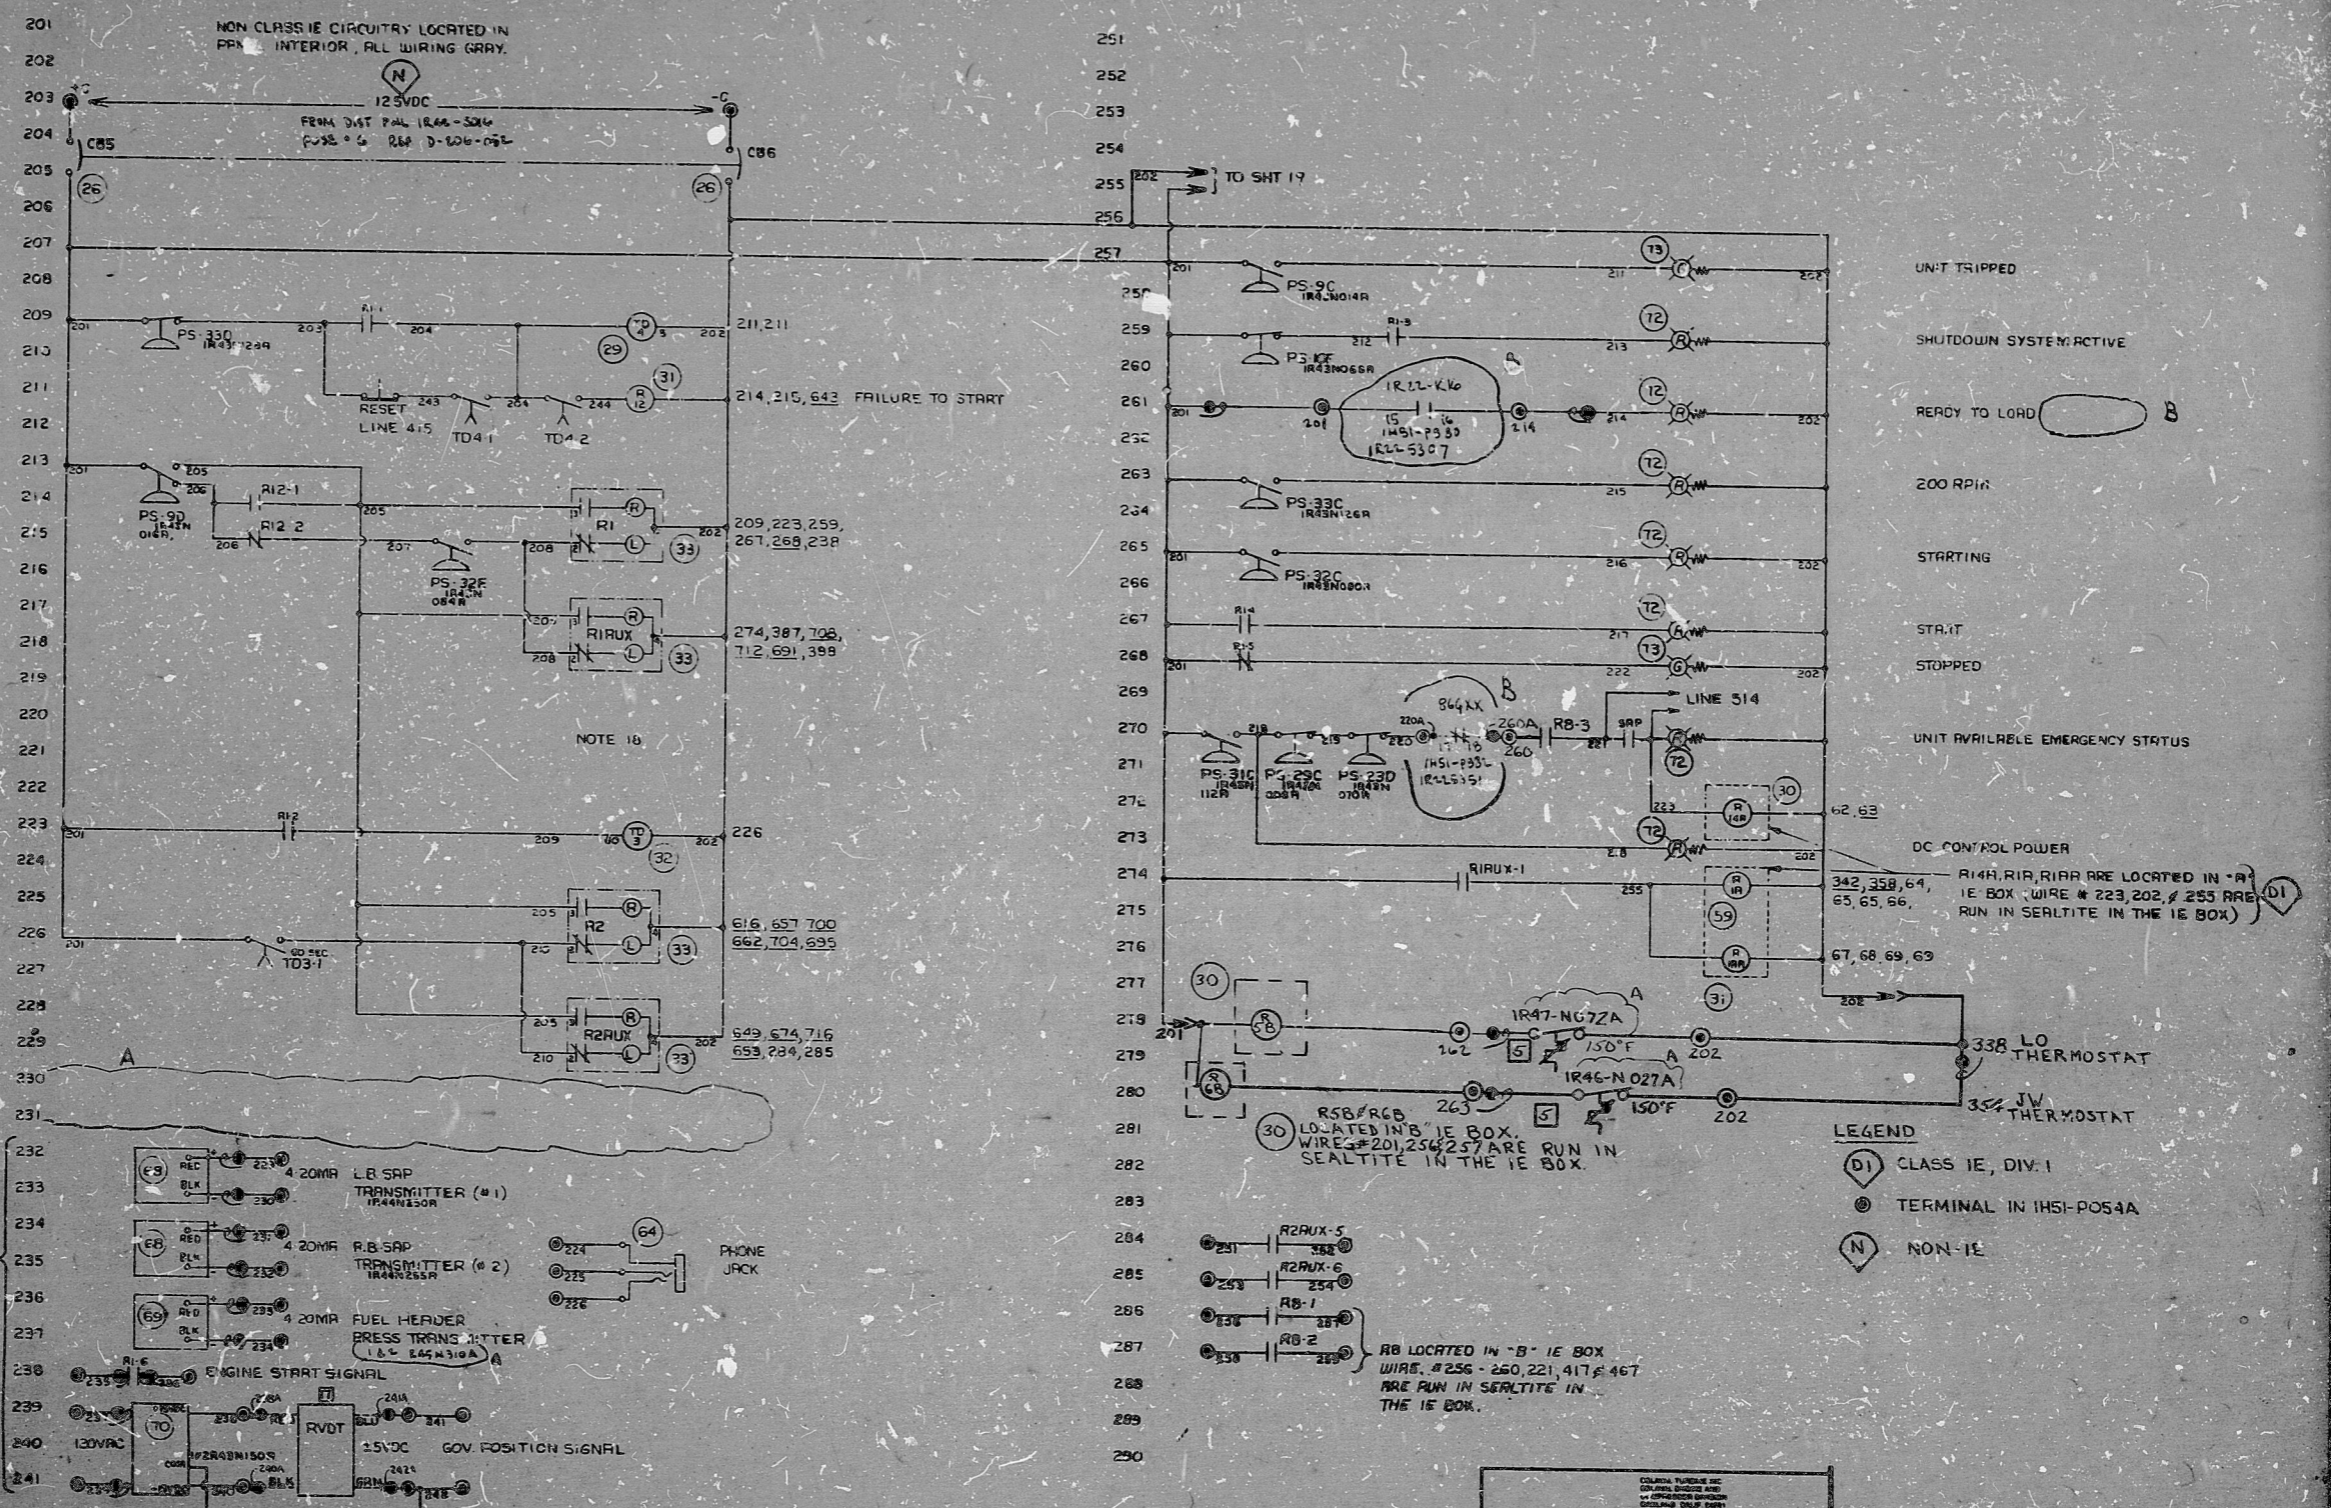

CLEVELAND ELECTRIC ILLUMINATING CO. PERRY NUCLEAR POWER PLANT UNIT #1

DELAVAL

CONTROL PANEL SCHEMATIC

DATE: 11-14-58

CONSTRUCTION: [initials]

PRELIMINARY: [initials]

RELEASED FOR: [initials]

ENGR. [initials]

GILBERT ASSOCIATES, INC. ENGINEERS AND CONSULTANTS

044548-000 VSC RPL DEC 1958

11-14-58

04 4548 D-10226 242 09 6

DRAWING NUMBER SYSTEM SH. M.

NUCLEAR SAFETY RELATED

THE CLEVELAND ELECTRIC ILLUMINATING CO.

PERRY NUCLEAR POWER PLANT UNIT #1

ELECTRICAL-ELEMENTARY DIAGRAM

STANDBY DIESEL GENERATOR

DIESEL CONTROL PANEL IHSI-POS4A

DIVISION I 1R42-C200A

PRO APERTURE CARD

Rids

82.1221.0573

