

11
8.5
8.5
11
17

11
8.5
8.5
11
17

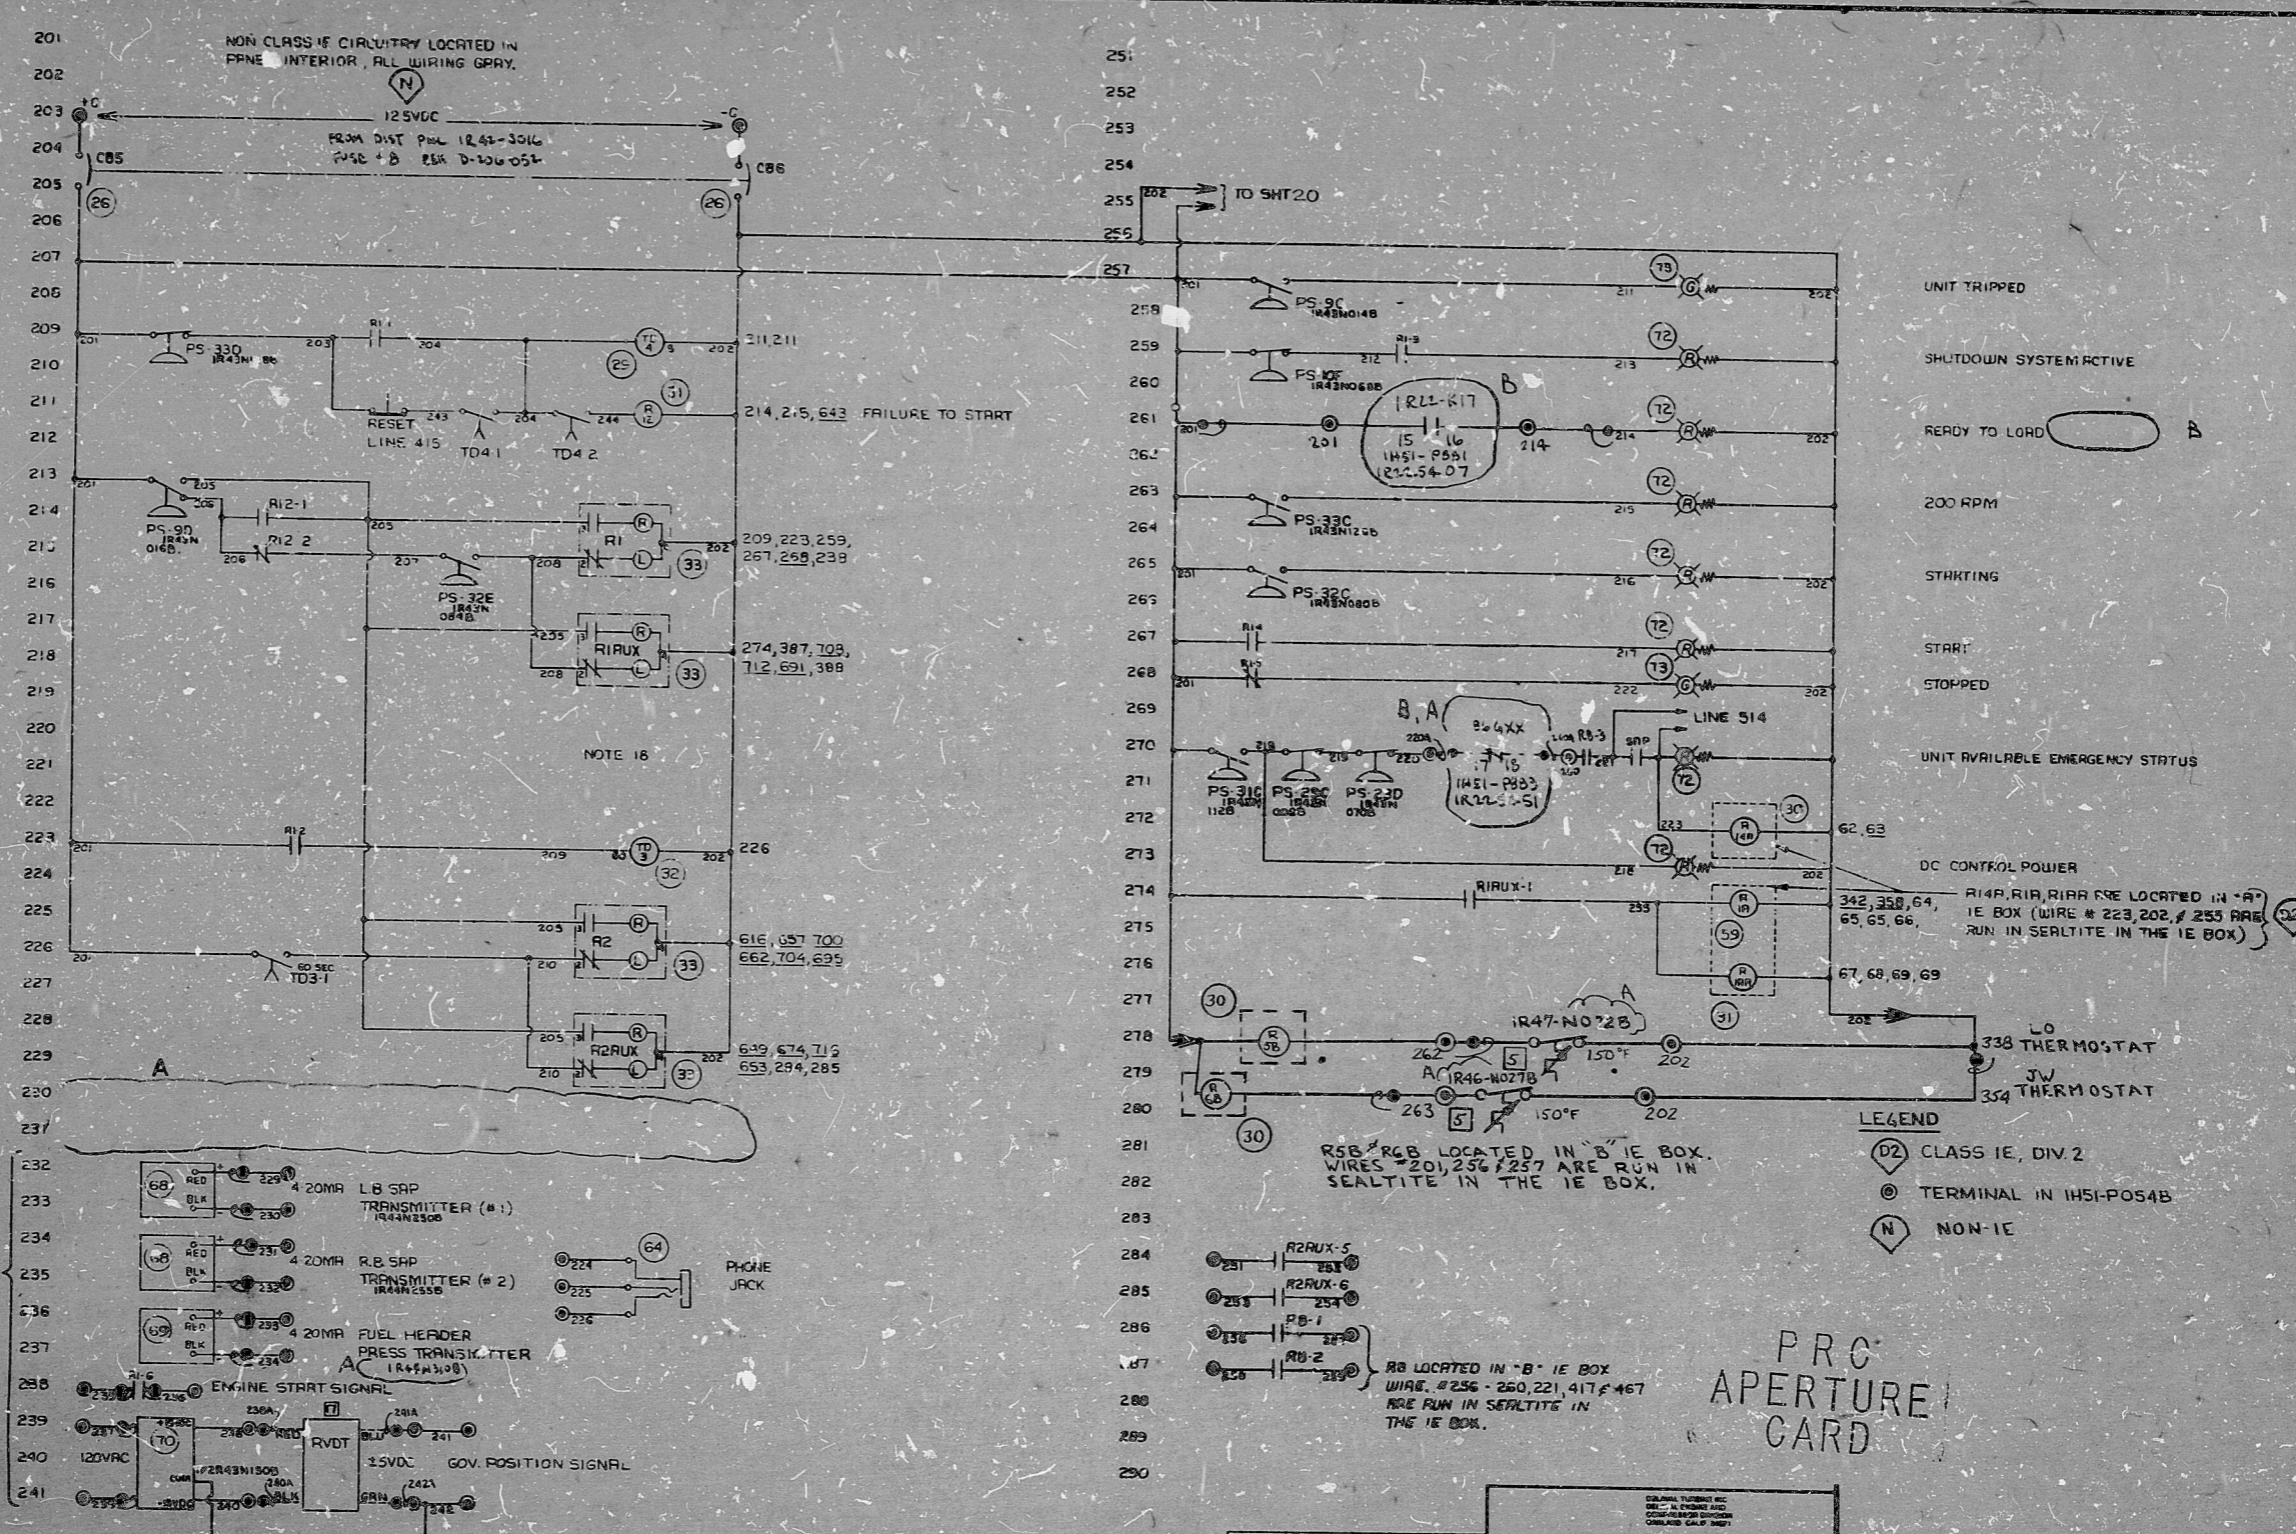


CHART READER INPUTS REF. SM.33

232	RED	229	4 20MA	LB SFP TRANSMITTER (#1)	IR44N2500	64	PHONE JACK
233	BLK	230	4 20MA	R.B. SFP TRANSMITTER (#2)	IR44N2500		
234	RED	231	4 20MA	FUEL HEADER PRESS TRANSMITTER AC	IR44N2500		
235	BLK	232	4 20MA	FUEL HEADER PRESS TRANSMITTER AC	IR44N2500		
236	RED	233	4 20MA	FUEL HEADER PRESS TRANSMITTER AC	IR44N2500		
237	BLK	234	4 20MA	FUEL HEADER PRESS TRANSMITTER AC	IR44N2500		
238	RED	235	4 20MA	FUEL HEADER PRESS TRANSMITTER AC	IR44N2500		
239	BLK	236	4 20MA	FUEL HEADER PRESS TRANSMITTER AC	IR44N2500		
240	RED	237	4 20MA	FUEL HEADER PRESS TRANSMITTER AC	IR44N2500		
241	BLK	238	4 20MA	FUEL HEADER PRESS TRANSMITTER AC	IR44N2500		

REV MADE CHKD APPROVALS DATE

REV	MADE	CHKD	APPROVALS	DATE

ADDED CONTACT IR2L-K17 (LINE 261) & B64X (LINE 270)

REMOVED 20V TANK LEVEL XMT & METER WIRING, LINES 230 & 231. REVISED TAG # LINE 237

READING: 044548-000 WJC DRS DEG JMS 1-14-79 04 4549 B-208-216 RAS IC B

WORK ORDER: ELEM DIAL IHS1-POS4B DIESEL CONT

CLEVELAND ELECTRIC ILLUMINATING CO. PERRY NUCLEAR POWER PLANT UNIT #1

DELAVAL

CONTROL PANEL SCHEMATIC

NUCLEAR SAFETY RELATED

THE CLEVELAND ELECTRIC ILLUMINATING CO. PERRY NUCLEAR POWER PLANT UNIT #1

ELECTRICAL-ELEMENTARY DIAGRAM

STANDBY DIESEL GENERATOR

DIESEL CONTROL PANEL IHS1-POS4B

DIVISION 2 IR45-C0018

DATE	RELEASED FOR	ENGR.
1-15-79	CONSTRUCTION	
	PRELIMINARY	

REV MADE CHKD APPROVALS DATE

REV	MADE	CHKD	APPROVALS	DATE

DATE: 1-14-79

DRAWING NUMBER: B-208-216

SYSTEM IN. NO. 106

Rids

8212210574

