

17"

11"

8.5"

8.5"

11"

17"

17"


11"

8.5"

8.5"

11"

17"

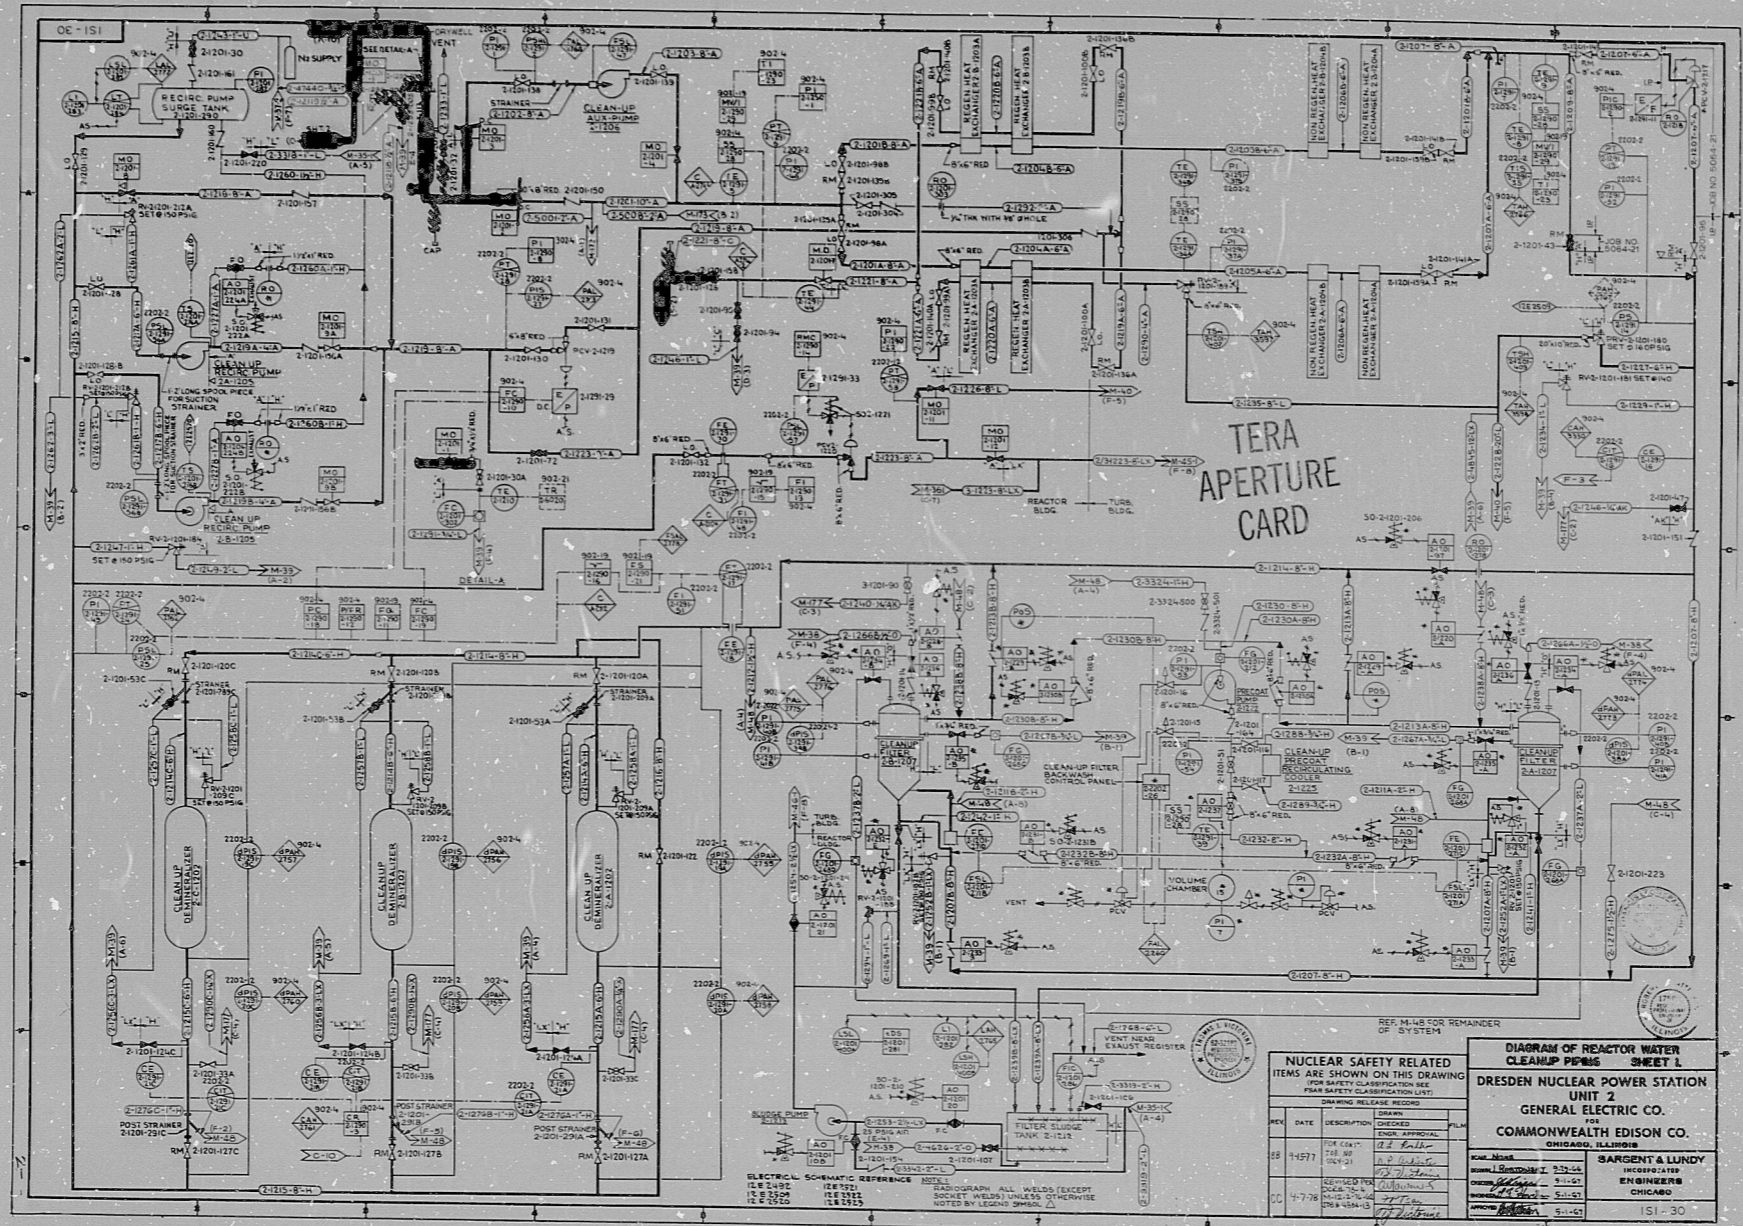

REF: M-48 FOR REMAINDER OF SYSTEM

NUCLEAR SAFETY RELATED ITEMS ARE SHOWN ON THIS DRAWING FOR SAFETY CLASSIFICATION SEE P&ID SAFETY CLASSIFICATION LIST			
REV	DATE	DESCRIPTION	DESIGNED BY
01	04-04-68	ISSUED FOR CONSTRUCTION	J. J. Lundy
02	04-04-68	ISSUED FOR CONSTRUCTION	J. J. Lundy
03	04-04-68	ISSUED FOR CONSTRUCTION	J. J. Lundy
04	04-04-68	ISSUED FOR CONSTRUCTION	J. J. Lundy

DRAWN BY: J. J. Lundy
 CHECKED BY: J. J. Lundy
 APPROVED BY: J. J. Lundy
 TITLE: DIAGRAM OF REACTOR WATER CLEANUP PIPING SHEET 1
 PROJECT: DRESDEN NUCLEAR POWER STATION UNIT 2
 COMPANY: GENERAL ELECTRIC CO. COMMONWEALTH EDISON CO.
 ENGINEER: SARGENT & LUNDY
 CHICAGO, ILLINOIS
 151-30

1205

8107130529

