


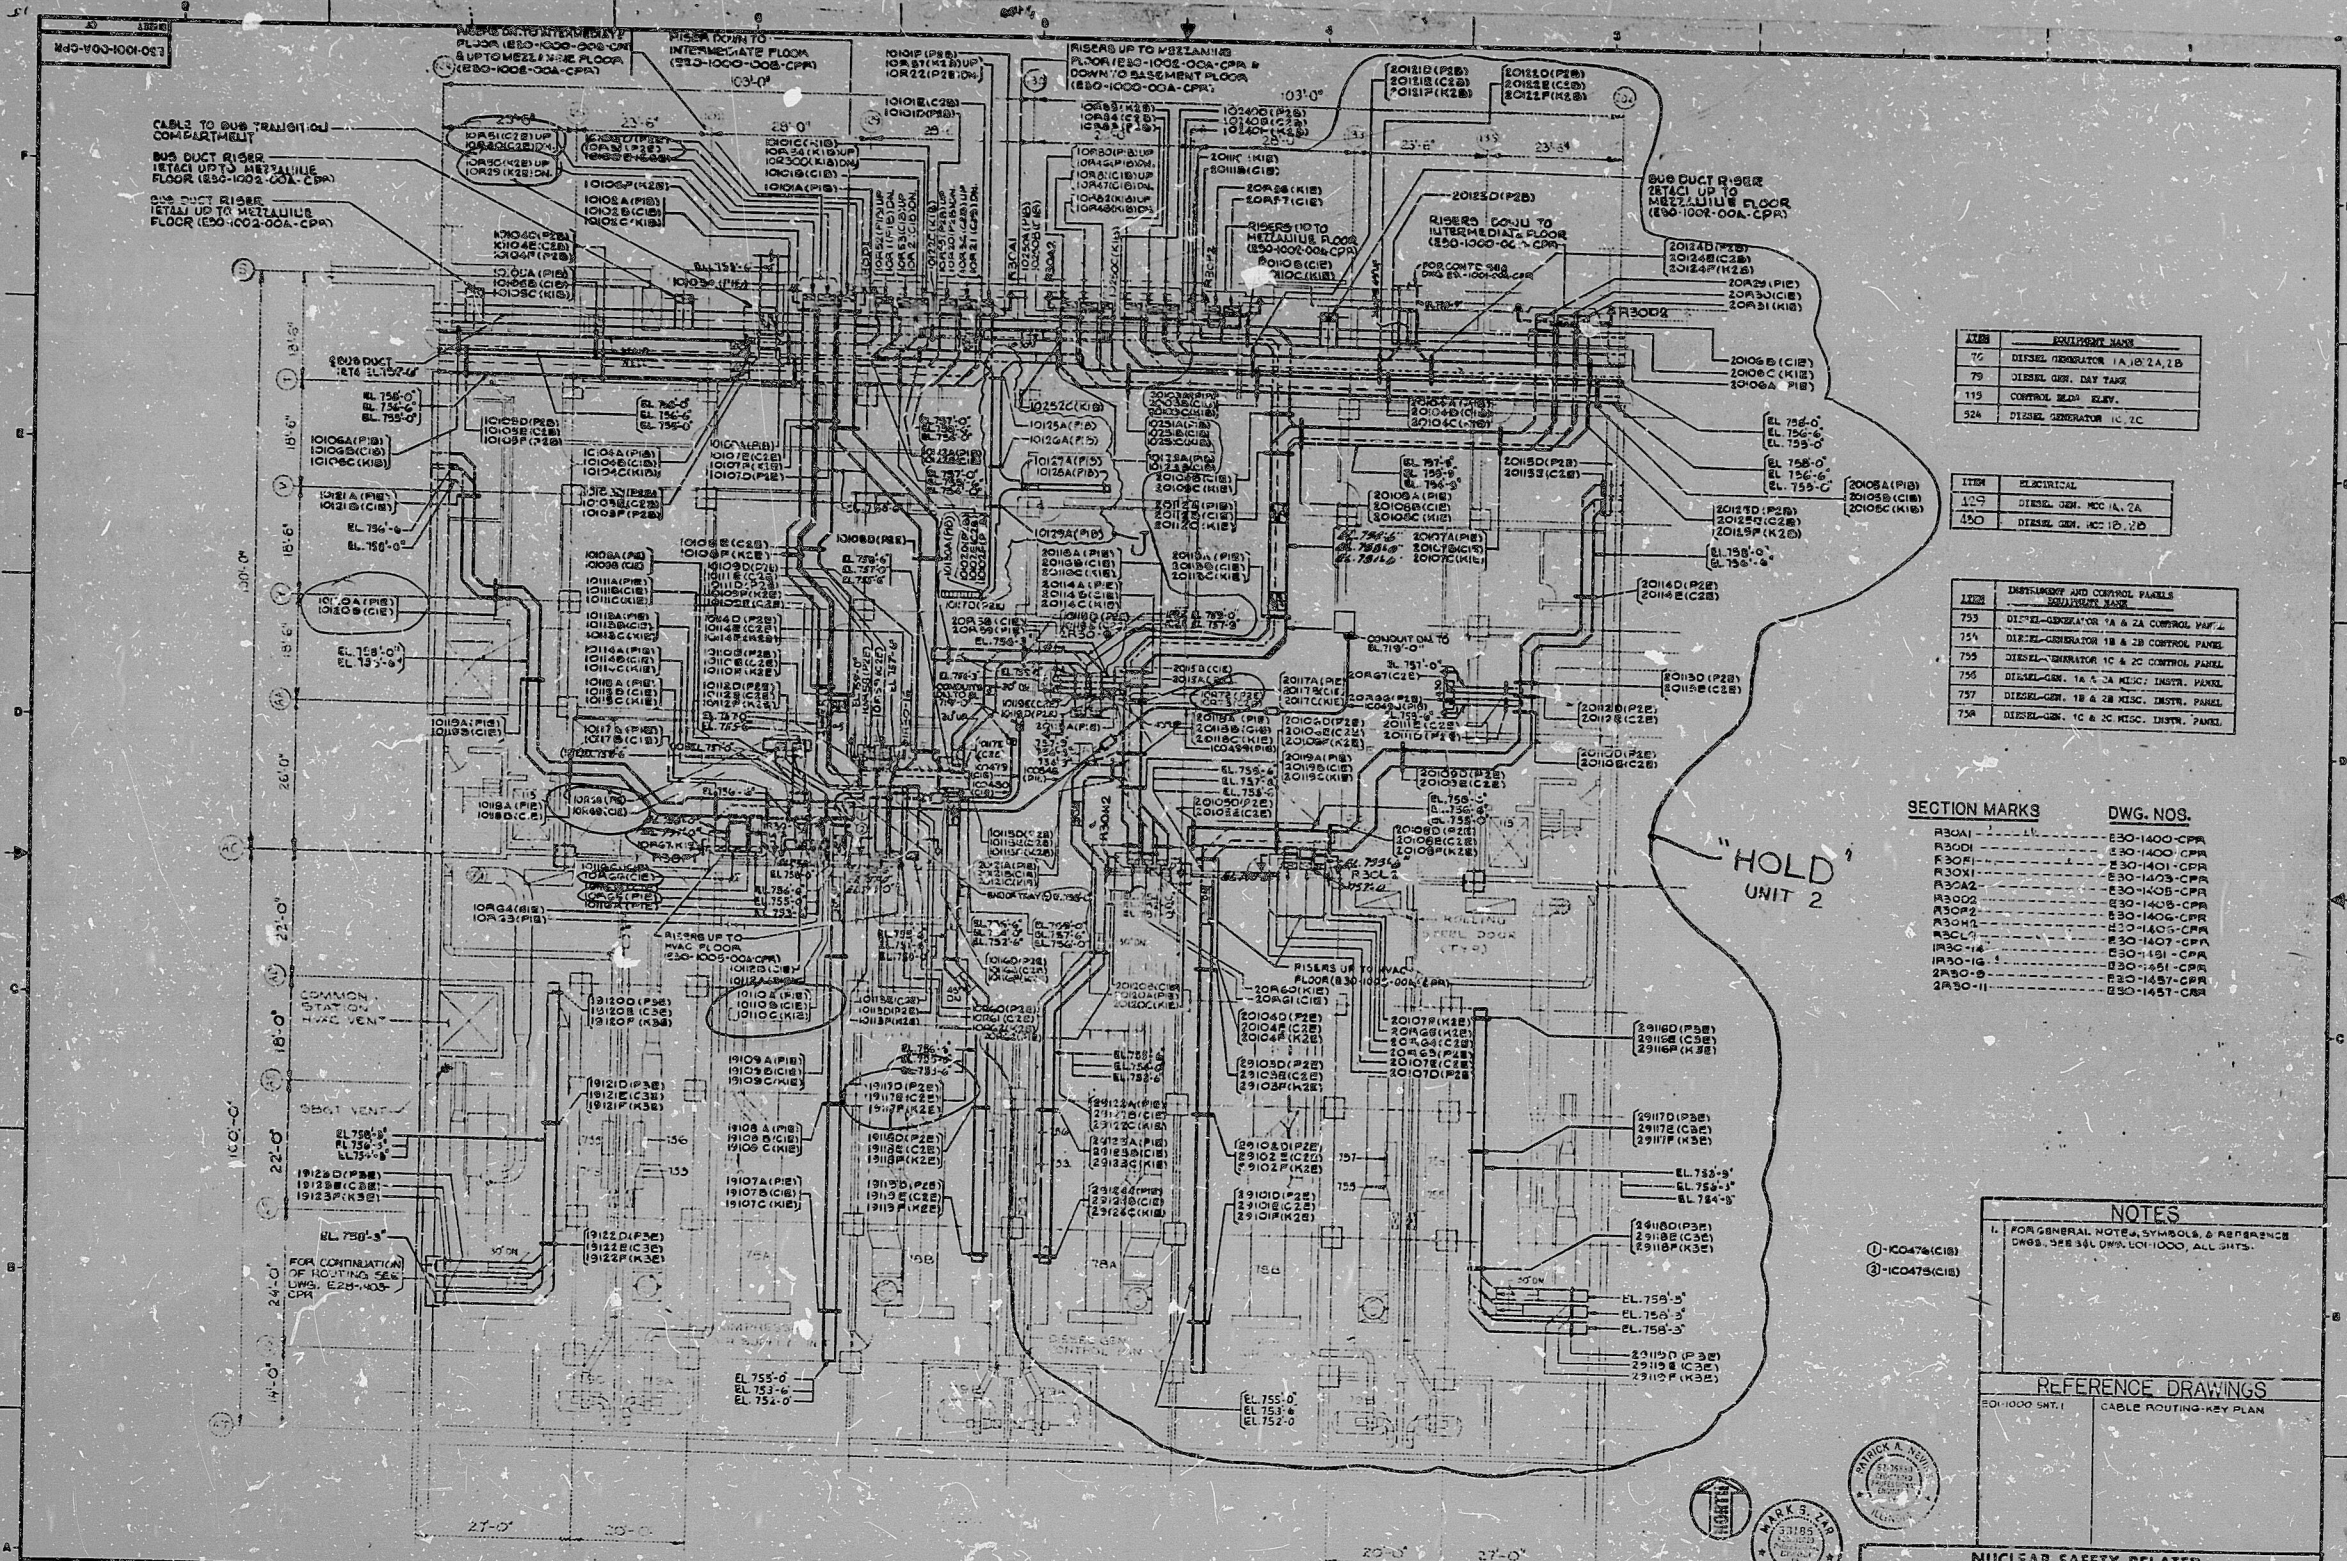

ITEM	EQUIPMENT NAME
70	DIESEL GENERATOR 1A, 10, 2A, 1B
71	DIESEL GEN. DAY TANK
115	CONTROL BENCH, ELEV.
324	DIESEL GENERATOR 1C, 1C

ITEM	ELECTRICAL
101	DIESEL GEN. NO. 1A, 2A
100	DIESEL GEN. NO. 1B, 2B

ITEM	INSTRUMENT AND CONTROL PANELS
753	DIESEL GENERATOR 1A & 2A CONTROL PANEL
754	DIESEL GENERATOR 1B & 2B CONTROL PANEL
755	DIESEL GEN. 1A, 2A, 1B, 2B CONTROL PANEL
757	DIESEL GEN. 1B & 2B INSTR. PANEL
758	DIESEL GEN. 1C & 2C INSTR. PANEL

SECTION MARKS	DWG. NOS.
R301	E30-1400-CPR
R302	E30-1401-CPR
R303	E30-1402-CPR
R304	E30-1403-CPR
R305	E30-1404-CPR
R306	E30-1405-CPR
R307	E30-1406-CPR
R308	E30-1407-CPR
R309	E30-1408-CPR
R310	E30-1409-CPR
R311	E30-1410-CPR
R312	E30-1411-CPR
R313	E30-1412-CPR
R314	E30-1413-CPR
R315	E30-1414-CPR
R316	E30-1415-CPR

NOTES
1. FOR GENERAL NOTES, SYMBOLS, & REFERENCE
DWS. SEE 301 DWS. 1000, ALL SHTS.

REFERENCE DRAWINGS
E30-1000-SHT. 1
CABLE ROUTING-KEY PLAN

DRAWING RELEASE RECORD				DRAWING RELEASE RECORD			
REV.	DATE	BY	REASON	REV.	DATE	BY	REASON
1	11-2-51	...	...	1	3-15-58	...	...
2	...	...	...	2	...	...	...
3	...	...	...	3	...	...	...
4	...	...	...	4	...	...	...
5	...	...	...	5	...	...	...
6	...	...	...	6	...	...	...
7	...	...	...	7	...	...	...
8	...	...	...	8	...	...	...
9	...	...	...	9	...	...	...
10	...	...	...	10	...	...	...

NUCLEAR SAFETY RELATED
EQUIPMENT IS SHOWN ON THIS DRAWING.
(FOR SAFETY CLASSIFICATION SEE EQUIPMENT, VALVE, OR INSTRUMENT LIST)

CABLE TRAY ROUTING
CONTROL/DIESEL GENERATOR BUILDING
GRADE FLOOR PLAN - EL. 737'-0"

CLINTON POWER STATION - UNITS 1 & 2
ILLINOIS POWER COMPANY
CLINTON, ILLINOIS

SARGENT & LUNDY
CHICAGO
DRAWING NO. E30-1001-00A-CPR
SHEET 01

PRO
APERTURE
CARL

RIDS

8301110116

