

32"

22"

17"

11"

9.5"

8.5"

11"

17"

22"

34"

34"

22"

17"

11"

9.5"


8.5"

11"

17"

22"

34"

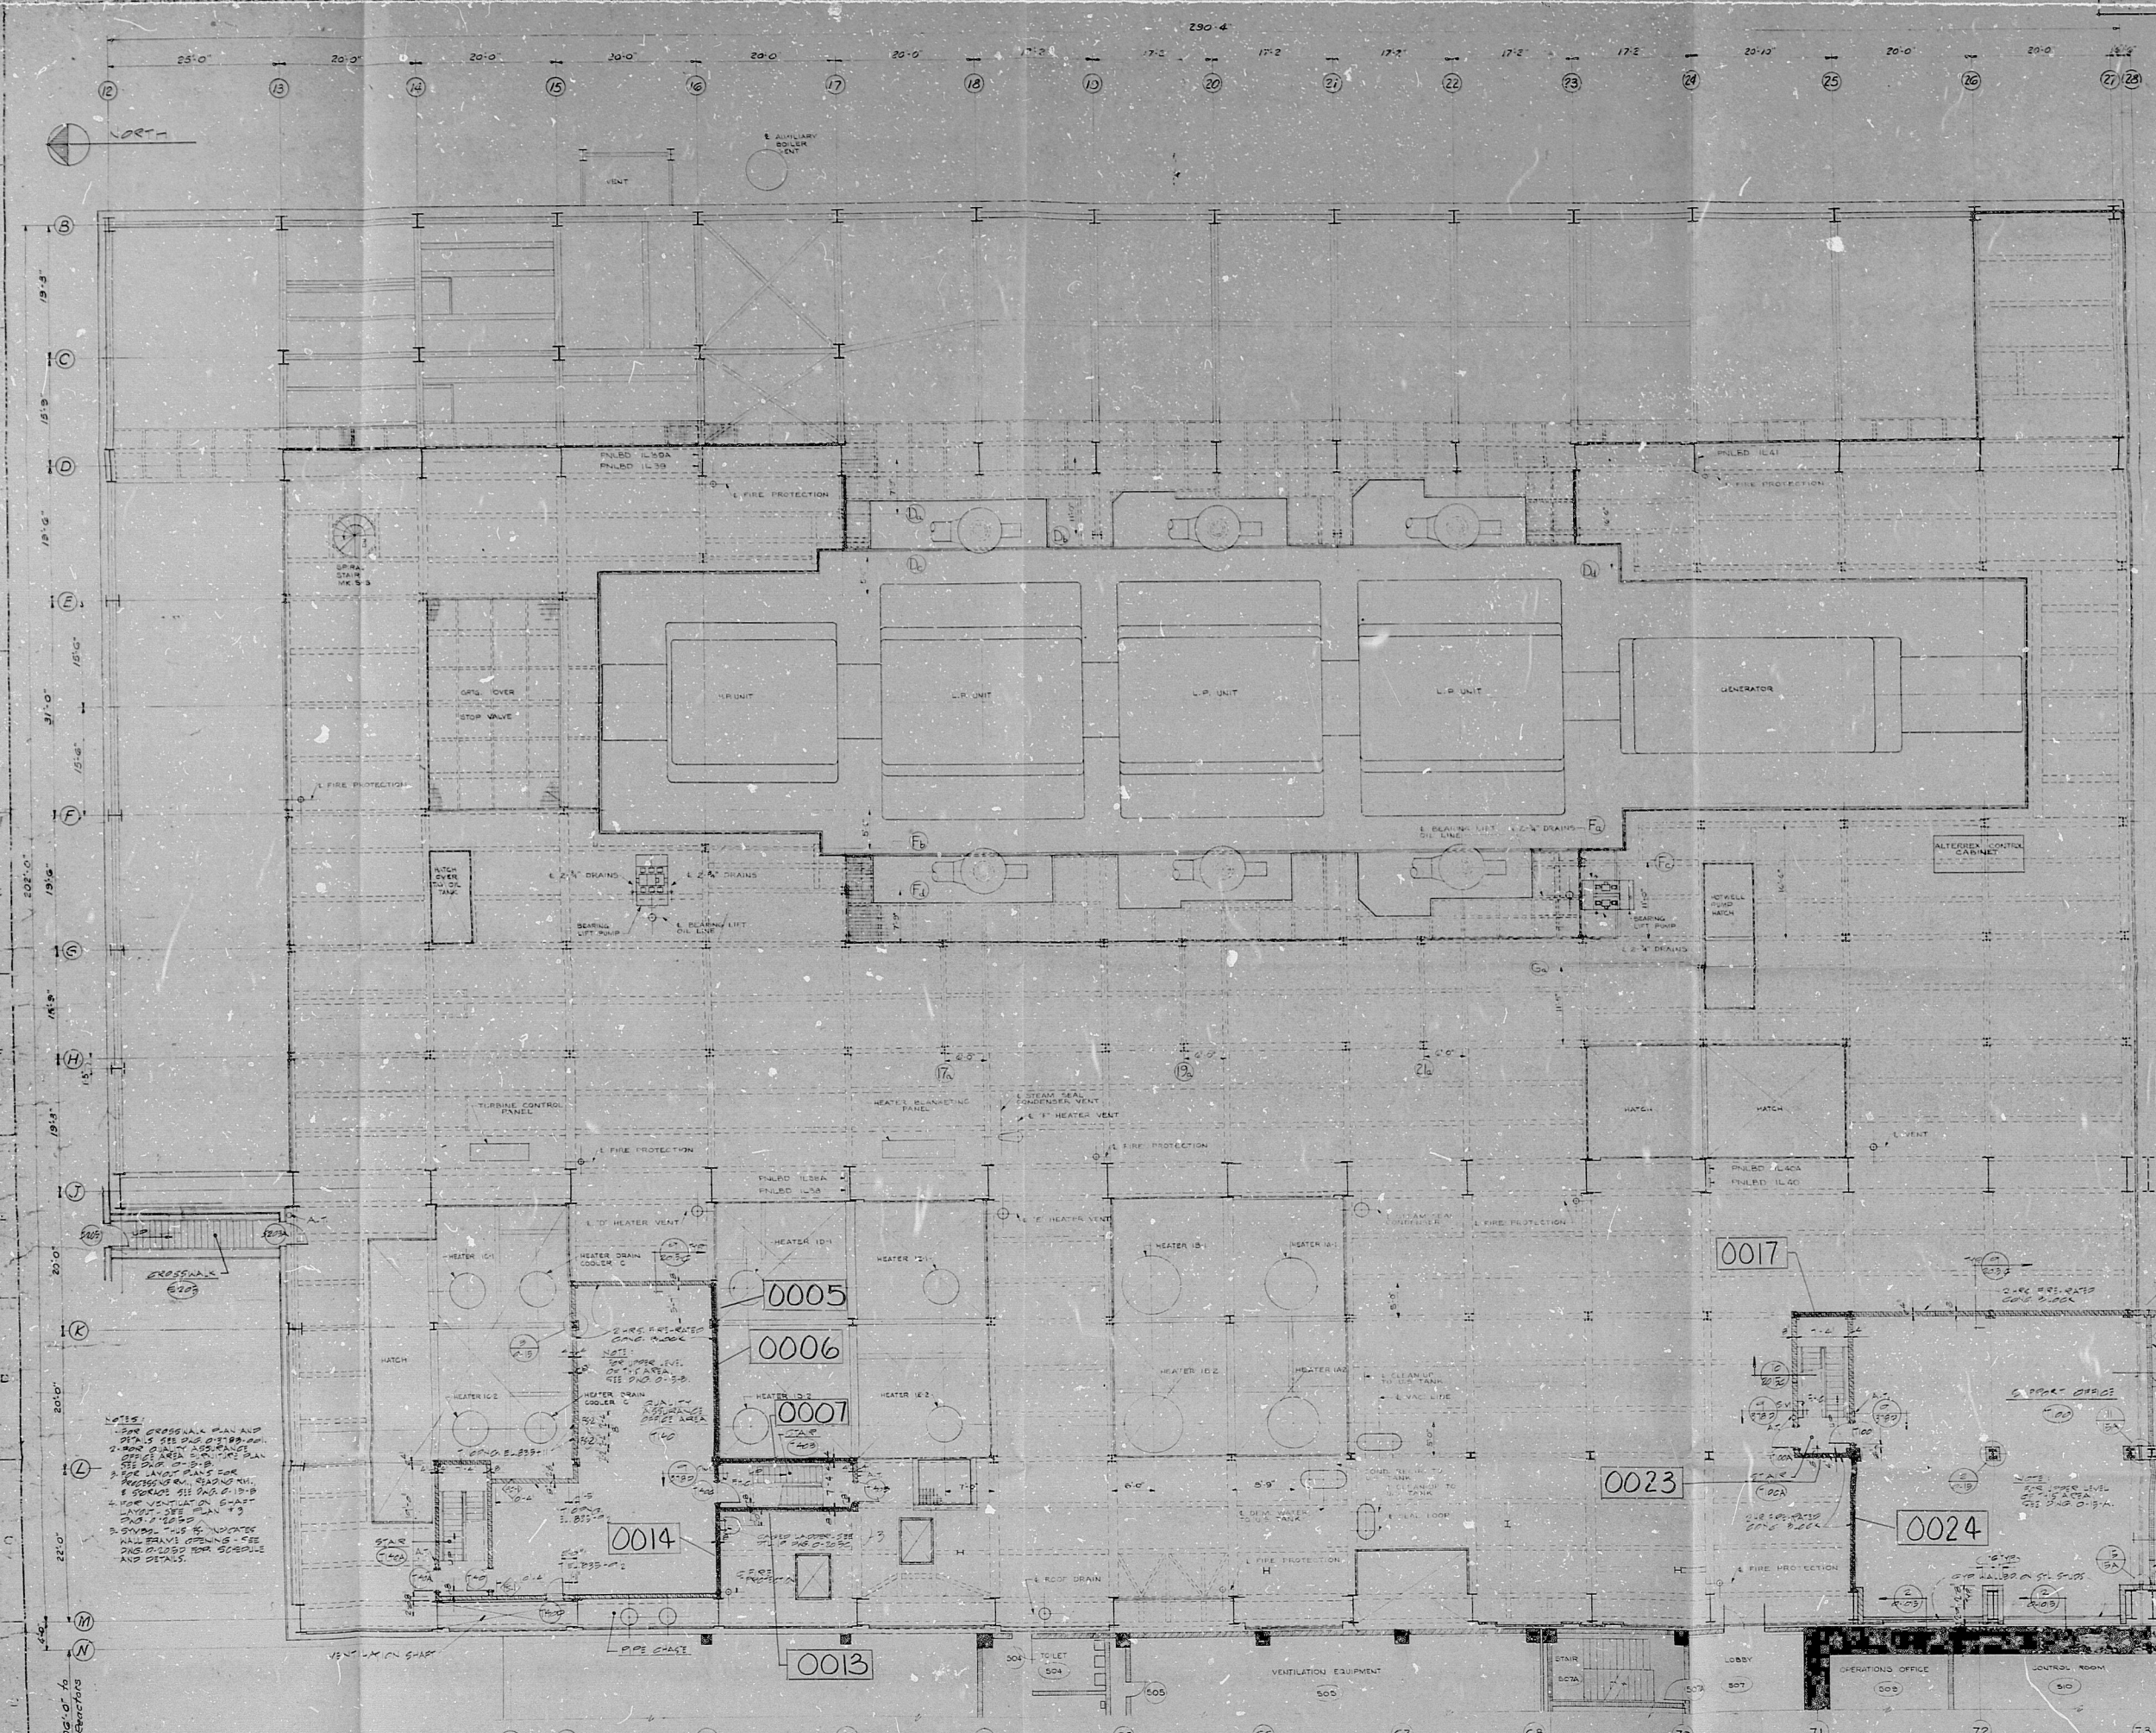

NOTES:  
1. SEE CROSS-SECTION PLAN AND  
DETAILS FOR DIMENSIONS AND  
CONSTRUCTION OF THIS PLAN.  
2. SEE LAYOUT PLAN FOR  
POSITIONS OF ALL EQUIPMENT.  
3. SEE VENTILATION PLAN FOR  
POSITIONS OF ALL VENTS.  
4. SEE ELEVATION PLAN FOR  
POSITIONS OF ALL ELEVATIONS.  
5. SEE SECTION PLAN FOR  
POSITIONS OF ALL SECTIONS.  
6. SEE DETAIL PLAN FOR  
POSITIONS OF ALL DETAILS.  
7. SEE GENERAL NOTE FOR  
POSITIONS OF ALL GENERAL NOTES.  
8. SEE SPECIFICATION FOR  
POSITIONS OF ALL SPECIFICATIONS.  
9. SEE STANDARD FOR  
POSITIONS OF ALL STANDARDS.  
10. SEE CODE FOR  
POSITIONS OF ALL CODES.

2 COLUMN FLOORING DETAIL  
SCALE: 1/4" = 1'-0" (SEE COLUMN)

3 COLUMN FLOORING DETAIL  
SCALE: 1/4" = 1'-0" (SEE COLUMN)

NOTES:  
1. FOR REPAIR OF OPENINGS & REINFORCEMENTS IN FIBER REINFORCED PLASTIC FLOOR  
OFFICE AREA FIBER REINFORCED PLASTIC FLOORING SHALL BE REINFORCED WITH 1/2" DIA. STEEL  
BARS. SEE DETAIL SHEET 0-0-0.

| DUKE POWER COMPANY              |           |            |                   |
|---------------------------------|-----------|------------|-------------------|
| OCCONEE NUCLEAR STATION-UNIT 1  |           |            |                   |
| TURBINE BUILDING - UNIT 1       |           |            |                   |
| PLAN AT EL 822'-0"              |           |            |                   |
| 1E BULLETIN 80-11               |           |            |                   |
| MASONRY WALLS-SHOWN ON DWG 0-15 |           |            |                   |
| DESIGNED                        | DATE      | REVISION   | DATE              |
| CHECKED                         | DATE      | REVISION   | DATE              |
| APPROVED                        | DATE      | REVISION   | DATE              |
| NO.                             | REVISIONS | CH-KD APPR | DWG. NO. 80-11-02 |

TERA  
APERTURE  
CARD



RIDS

8107270344

