




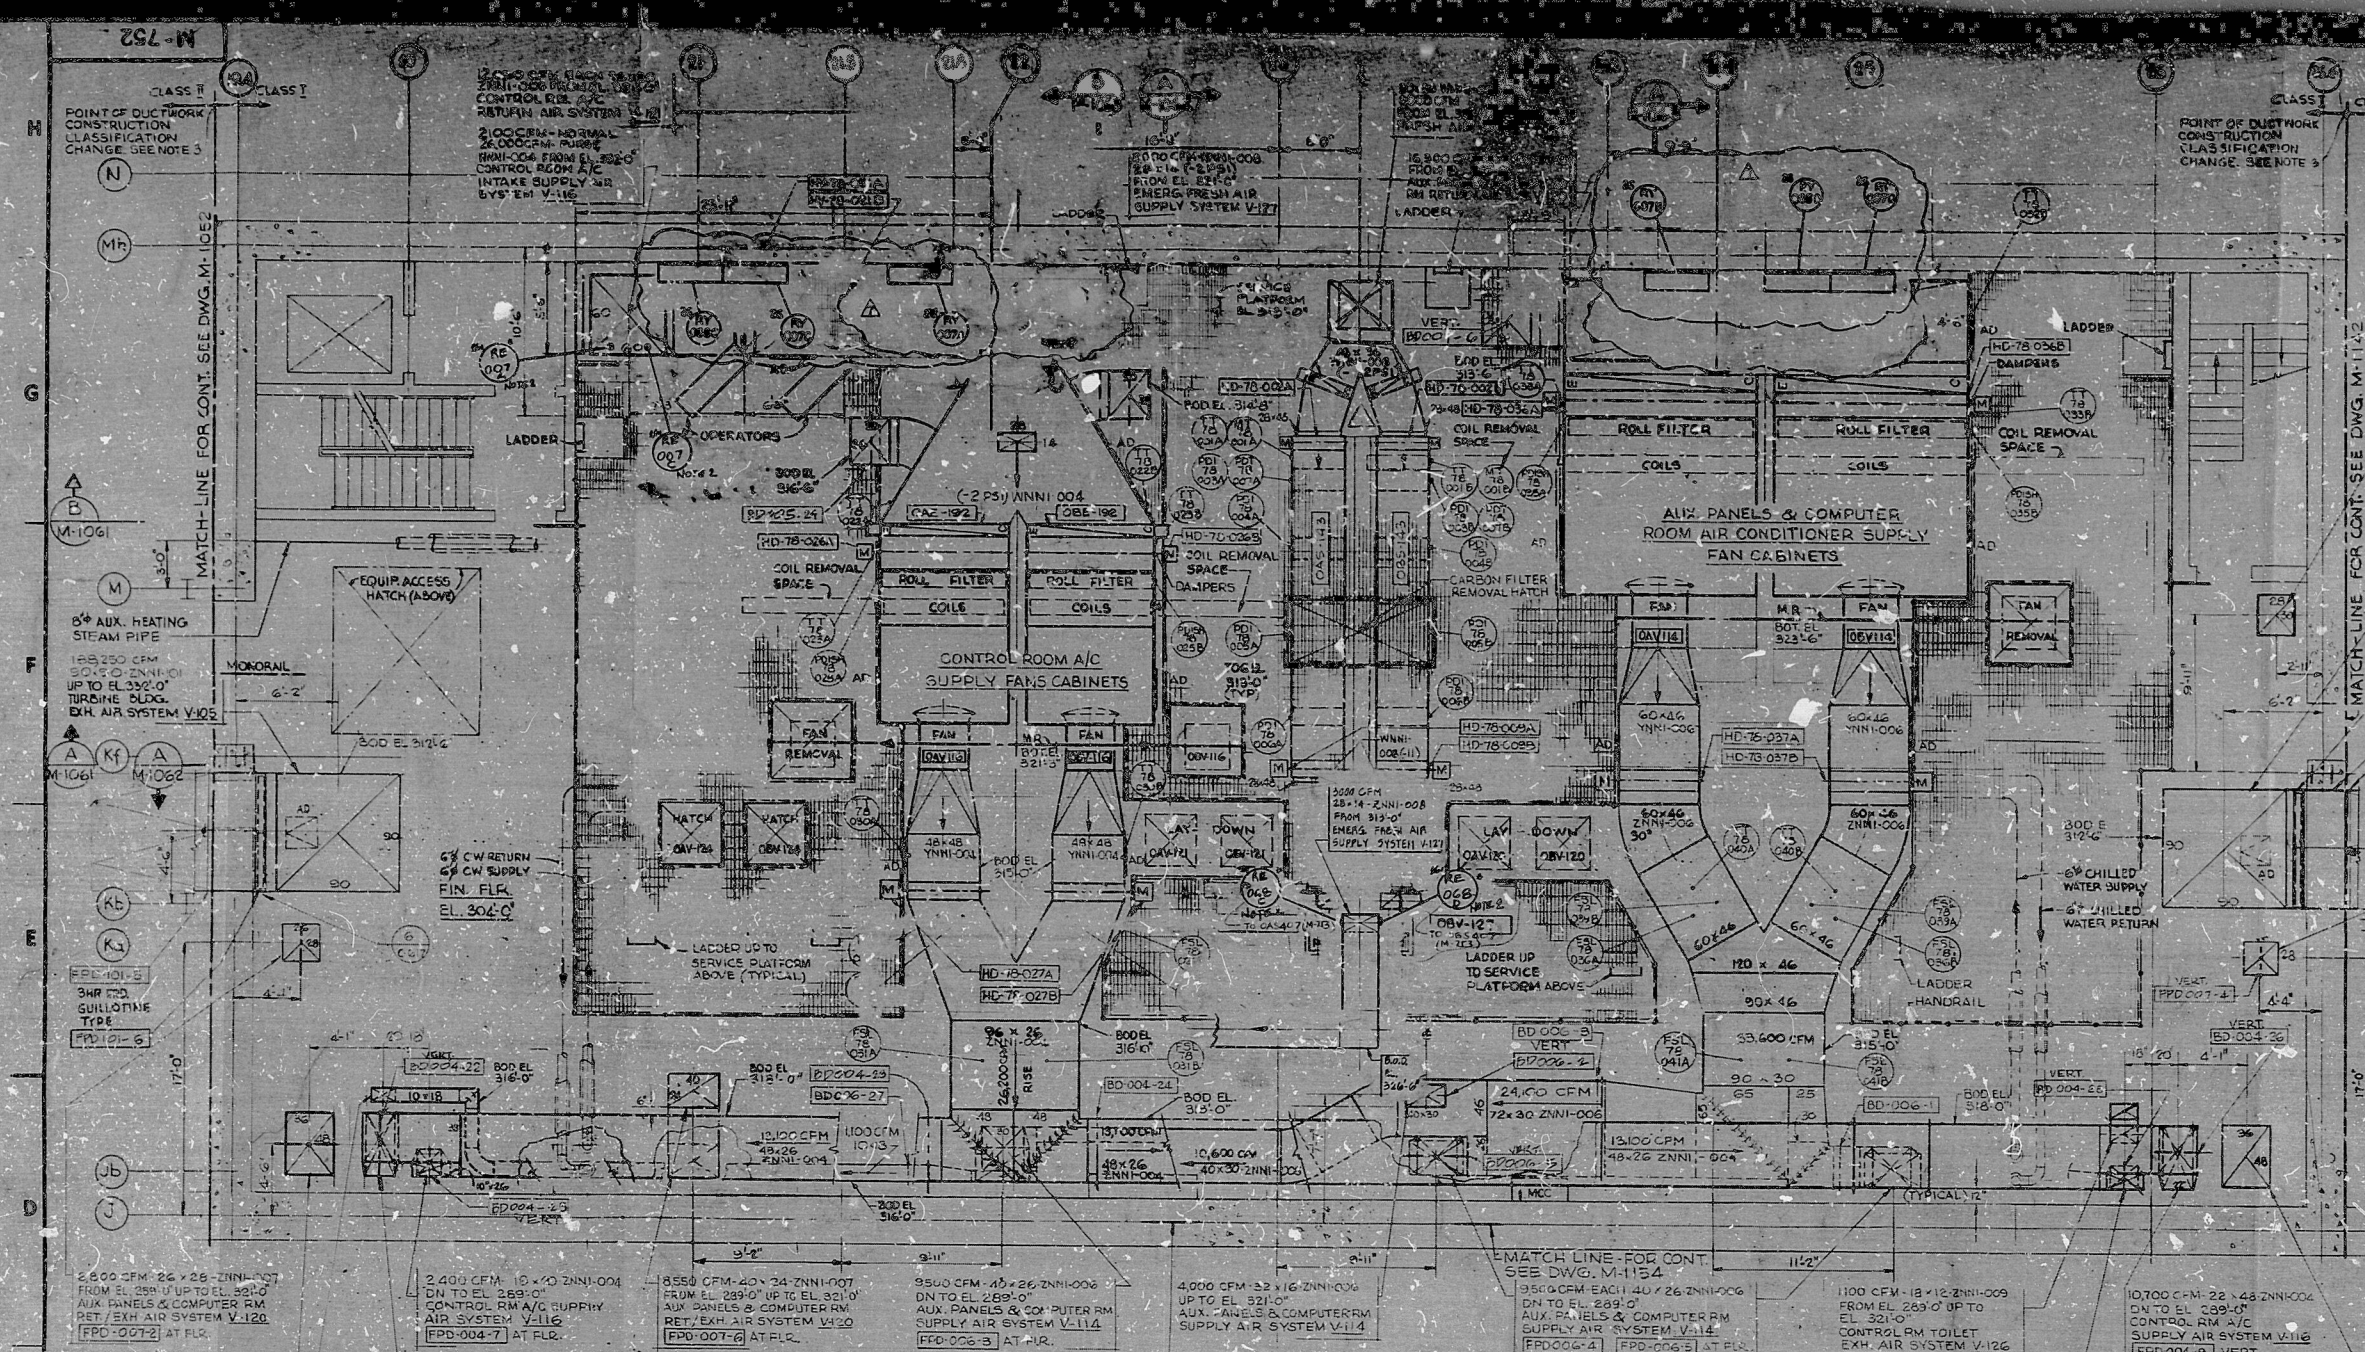


PLAN AT EL. 313'-0"
(FOR OTHER EQUIPMENT & DUCTWORK LAYOUT
SEE UPPER PLAN AT EL. 321'-0" DWG. M-1058)

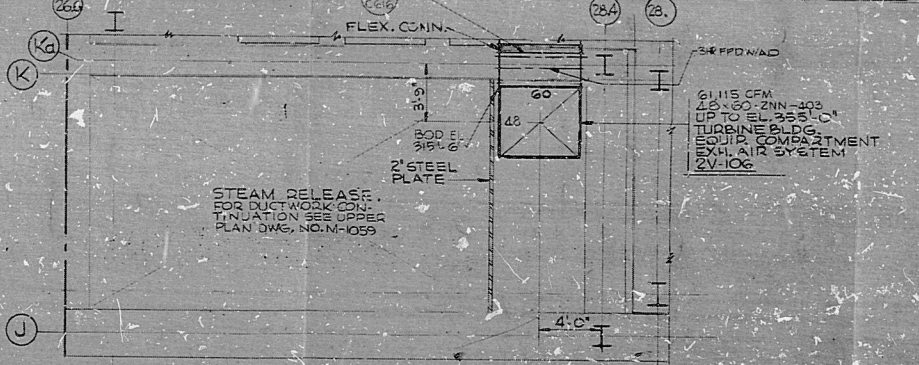

PARTIAL PLAN AT EL. 302'-0"

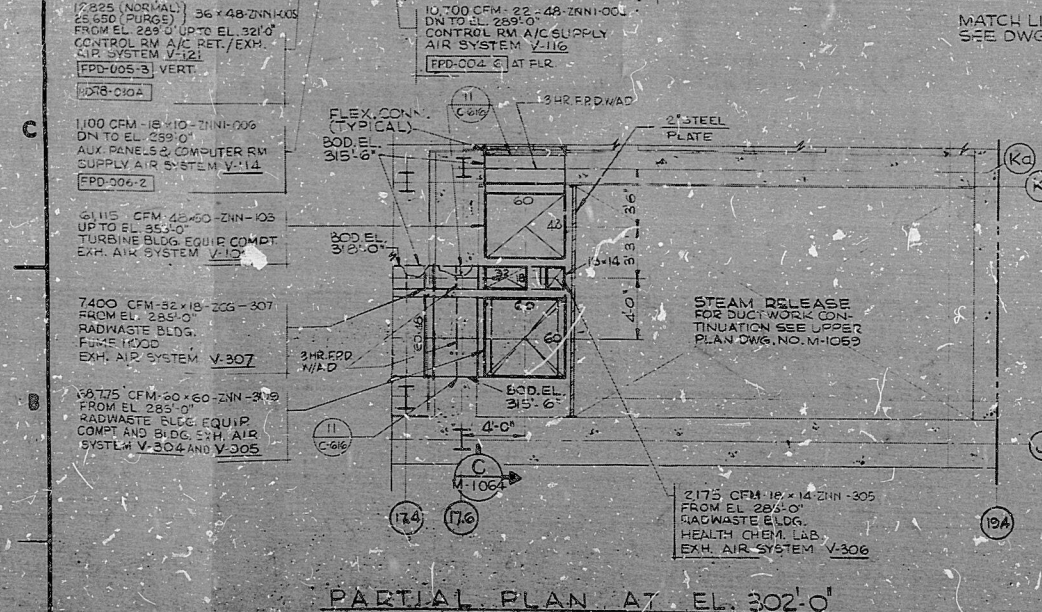

PARTIAL PLAN AT EL. 302'-0"

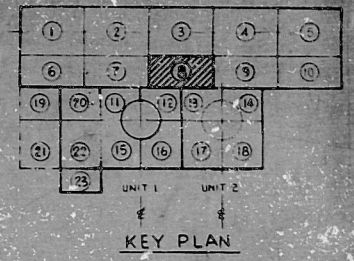

KEY PLAN

5550 CFM - 20" x 28" ZNN-007
FROM EL. 289'-0" UP TO EL. 321'-0"
AUX. PANELS & COMPUTER RM
RETURN/EXHAUST AIR SYSTEM V-120
[FDD-007-5] VERT.

18,250 CFM - 30" x 48" ZNN-005
UP TO EL. 321'-0"
TURBINE BLDG. EXHAUST
AIR SYSTEM V-105
[FDD-005-5] 3HR FPD
GULLOTTINE TYPE

5700 CFM - 28" x 36" ZNN-007
FROM EL. 289'-0" UP TO EL. 321'-0"
AUX. PANELS & COMPUTER RM
RETURN/EXHAUST AIR SYSTEM V-120

NOTES:
1. FOR LEGEND AND GENERAL NOTES SEE DWG. M-675
2. FOR LOCATION OF RAD MONITOR DETECTORS ON
DUCTS, SEE HEATING & VENTILATION DWGS.

DWG NO.	DESCRIPTION
M-753	INST. LOC. DWG. PLAN EL. 313' AREA B
M-753-3-4	OUTLINE DWG. FOR RAD MONITORS V-105, V-120, V-122, V-123

PRO
APERTURE
CARD

NO.	REVISION	DATE	BY	CHKD.
1	REVISED PER M-1058	11/1/58	J. H. H.	J. H. H.
2	REVISED PER M-1058	11/1/58	J. H. H.	J. H. H.
3	REVISED PER M-1058	11/1/58	J. H. H.	J. H. H.
4	REVISED PER M-1058	11/1/58	J. H. H.	J. H. H.
5	REVISED PER M-1058	11/1/58	J. H. H.	J. H. H.
6	REVISED PER M-1058	11/1/58	J. H. H.	J. H. H.
7	REVISED PER M-1058	11/1/58	J. H. H.	J. H. H.
8	REVISED PER M-1058	11/1/58	J. H. H.	J. H. H.
9	REVISED PER M-1058	11/1/58	J. H. H.	J. H. H.
10	REVISED PER M-1058	11/1/58	J. H. H.	J. H. H.

DECTEL
SAN FRANCISCO

USARMC GENERATING STATION UNIT 1 & 2
72-000000-000000

INSTRUMENT LOCATION
CONTROL AREA, UNIT 1 & 2
FAN ROOM FLOOR PLAN EL. 313' AREA B

8031	M-752	7
------	-------	---

BACKGROUND OF THIS DRAWING REPRODUCED
FROM HEATING, VENTILATING AND AIR
CONDITIONING CONTROL AREA FAN ROOM
DRAWING NO. M-1171 SHEET 1 REV. 2

BACKGROUND OF THIS DRAWING
REPRODUCED FROM HEATING, VENTILATING AND AIR
CONDITIONING CONTROL AREA FAN ROOM
DRAWING NO. M-1171 SHEET 1 REV. 2

RIDS

8301200143

