


17"


11"

8.5"


Vertical text on the left margin: "This drawing and any other drawings on which it is based are the property of the contractor. It is to be used only for the project for which it is prepared. It is not to be reproduced, copied, or distributed in any form without the written consent of the contractor."

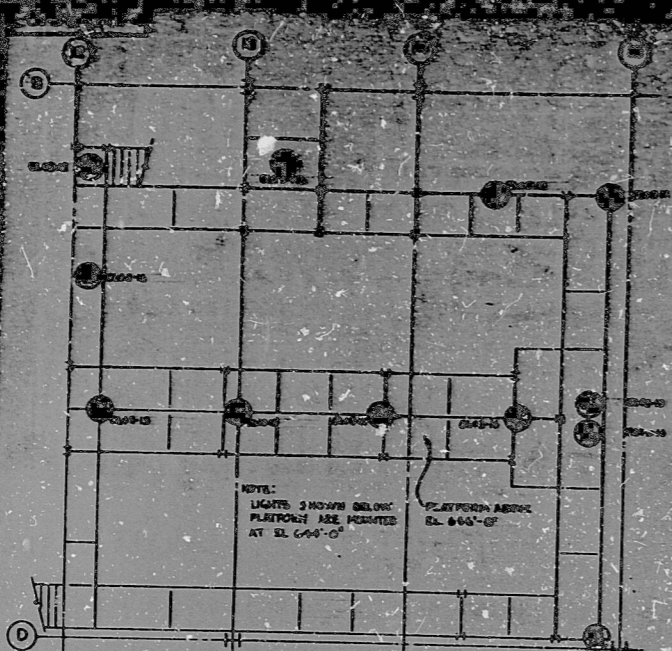


AUX-BOILER AREA-EL. 634'-6"
SCALE 1/4"=1'-0"

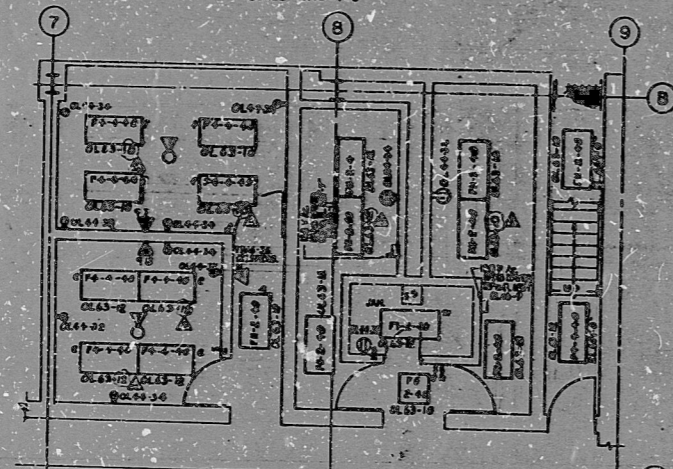


OFFICE & LAVATORY
SCALE 1/4"=1'-0"

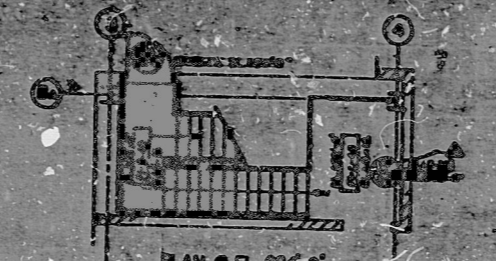


PLAN @ EL. 654'-0"

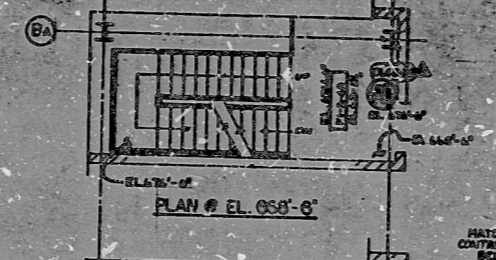


PLAN @ EL. 658'-6"

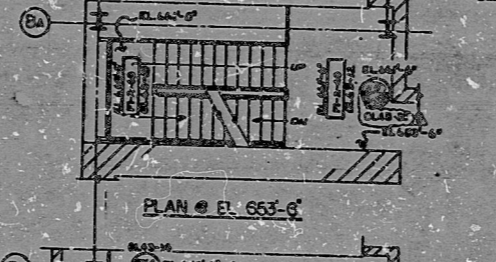


PLAN @ EL. 653'-6"

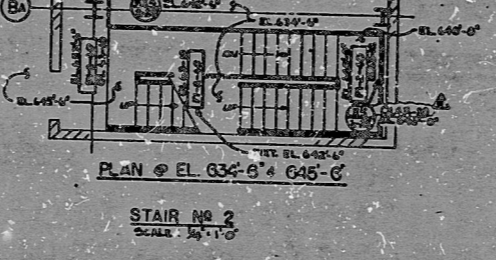


STAIR NO. 2
SCALE 1/4"=1'-0"

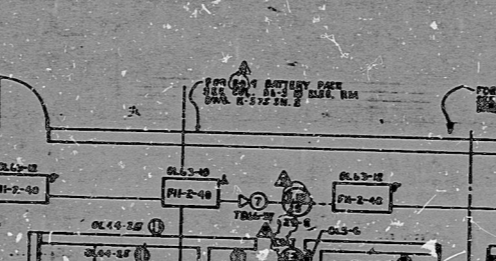

CONTROL AREA EL. 653'-6"
SCALE 1/4"=1'-0"

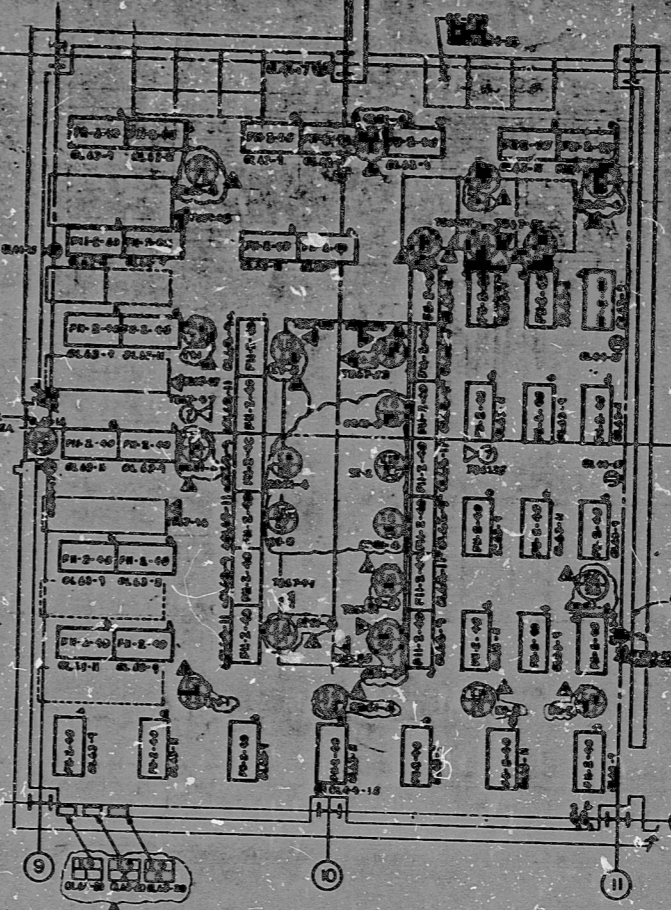

CONTROL ROOM EL. 653'-6"
SCALE 1/4"=1'-0"

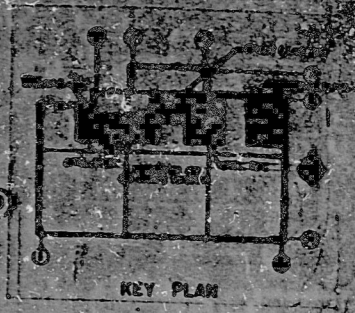


KEY PLAN

REFERENCE DRAWINGS

- E-2001 SIGNAL DISTRIBUTION PANELS UNIT & CONTROL
- E-43 COMMUNICATION NETWORK SYSTEMS (DETAILS)
- E-44 ERG & ODTZ SYSTEMS (DETAILS)
- E-45 LPS P-WALL SCHEDULE
- E-554 S&Z COMMUNICATION RISER DIA. PUBLIC ADDRESS/EMERG. ENR. ALARM SYSTEM.

30X

NOTED: THIS DRAWING IS TO BE USED IN CONJUNCTION WITH THE OTHER DRAWINGS OF THIS PROJECT. IT IS NOT TO BE USED IN ISOLATION. THE CONTRACTOR SHALL BE RESPONSIBLE FOR OBTAINING ALL NECESSARY PERMITS AND APPROVALS PRIOR TO CONSTRUCTION.

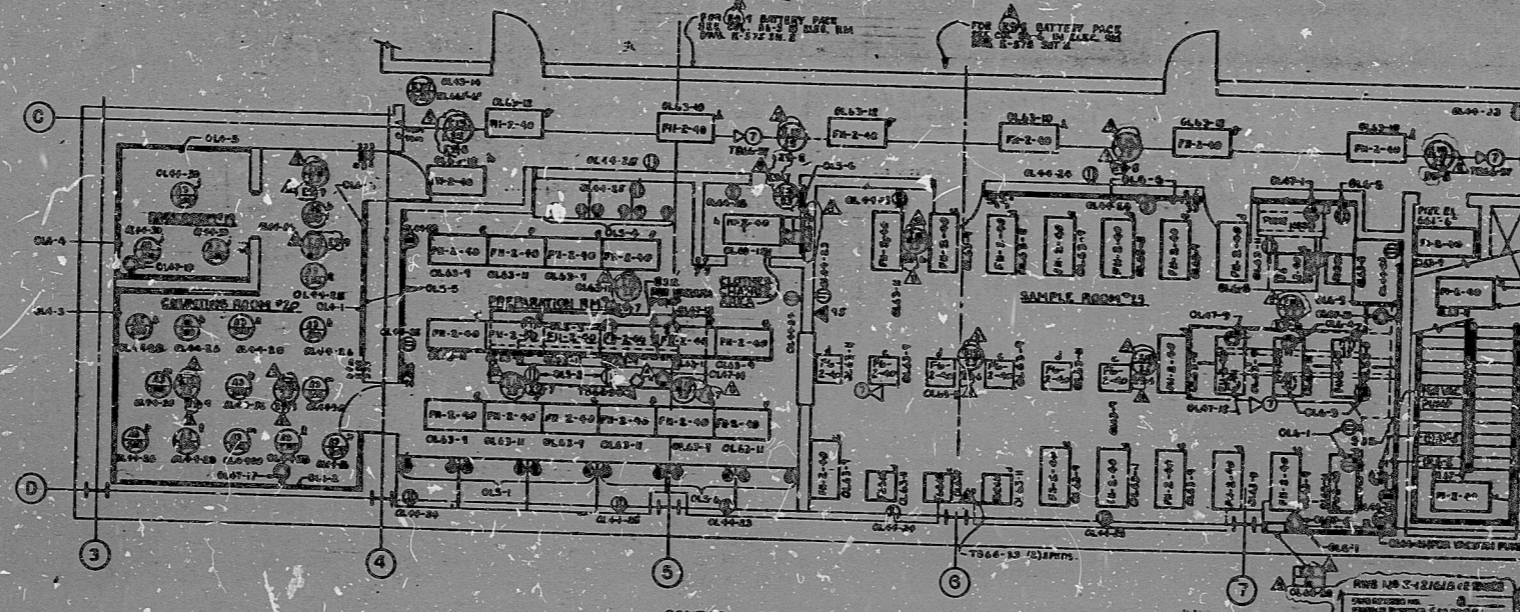

CONTROL AREA EL. 653'-6"
SCALE 1/4"=1'-0"

REFERENCE DRAWING

E-2001
FUT. EL. 642'-6"

PRC
PERTUR
CARD

1	2	3	4	5	6	7	8	9	10	11	12
1	2	3	4	5	6	7	8	9	10	11	12

RECDTEL
300 HARRIS BLVD.
NEW YORK, N.Y. 10014

REPLAS PLASTY UNITS : 6 2
COMMERCIAL POWER COMPANY

LIGHTING & COMMUNICATION
EVAPORATOR & AUX. BOILER BLDG.
EL. 634'-6" & EL. 653'-6"

7230 E-575 3H3CF4 B

17"

11"

8.5"

8.5"

11"

17"

RIDS

8302030594

