


E-576SH10F1

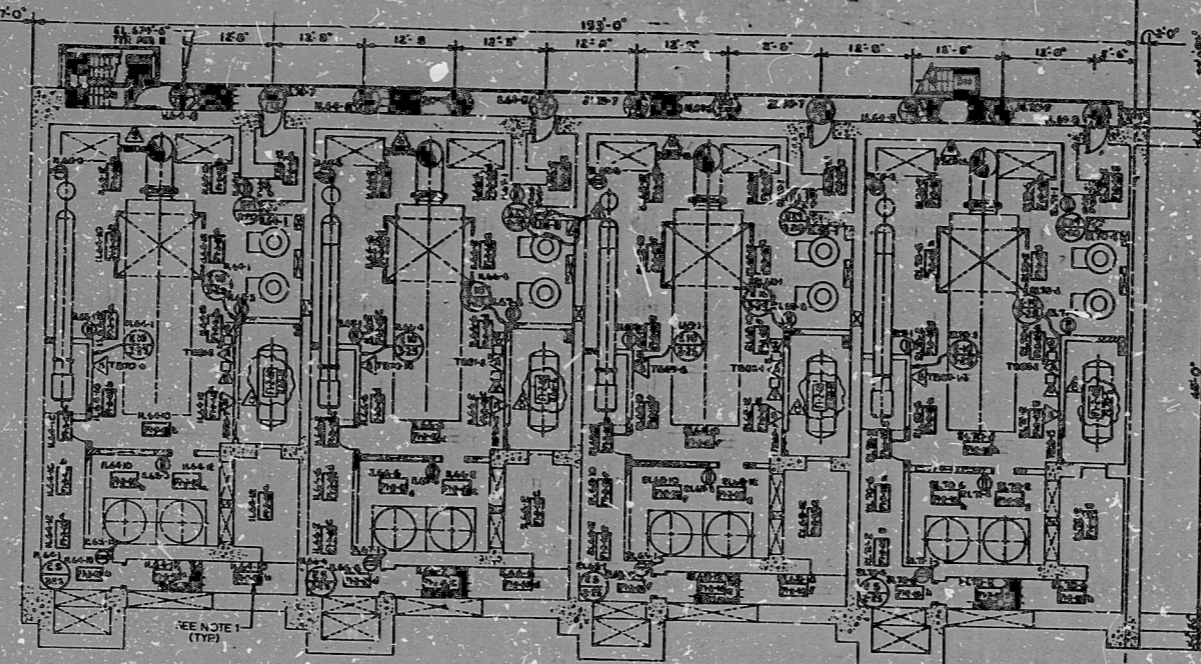

PLAN AT ELEV 664'-0"
SCALE 1/8"=1'-0"




PLAN AT EL 664'-0"
SCALE 1/8"=1'-0"



PLAN AT EL 649'-6"
SCALE 1/8"=1'-0"




PLAN AT EL 637'-9"
SCALE 1/8"=1'-0"

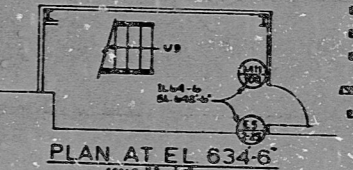


PLAN AT EL 634'-6"
SCALE 1/8"=1'-0"



PLAN AT EL 645'-7"
SCALE 1/8"=1'-0"

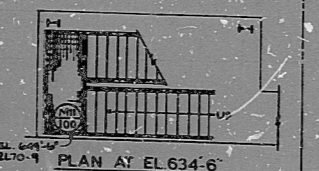


PLAN AT EL 634'-6"
SCALE 1/8"=1'-0"

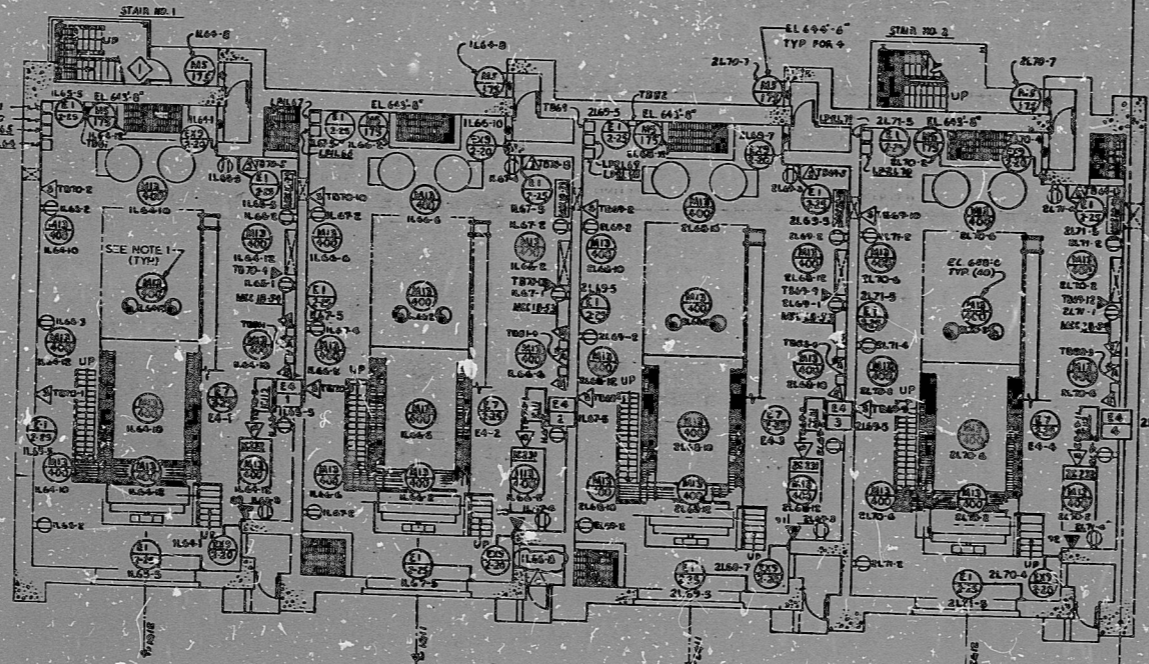

PLAN AT ELEV 634'-6"
SCALE 1/8"=1'-0"

STAIR NO. 2

STAIR NO. 1

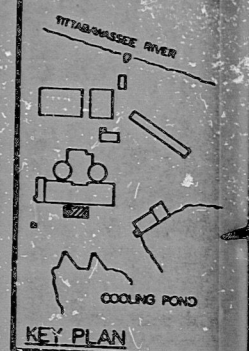

KEY PLAN



NOTES

1. FOR SAFETY CHAIR INSTALLATION ON THE FLUORESCENT AND MERCURY LIGHTING FIXTURES REFER TO E-4-314448 SHDS RESPECTIVELY.

REFERENCE DRAWINGS

- E-4-3 COMMUNICATION SYSTEM NOTES, SYMBOLS & DETAILS.
- E-4-4 LIGHTING NOTES, SYMBOLS & DETAILS.
- E-4-5 LIGHTING PANEL SCHEDULE.
- E-4-6, E-4-7 COMMUNICATIONS SYSTEM CAPACITY, PUBLIC ADDRESS/EMERGENCY EVAC ALARM SYSTEM.
- E-4-8 COMMUNICATION RIBER DIAGRAM, PWS TELEPHONES.
- E-4-9, E-4-10 COMMUNICATION RIBER DIAGRAM, INTERCOM & SOUND POWERED PHONE.

NO.	DESCRIPTION	DATE	BY	CHKD.
1	ISSUED FOR PERMIT	10/1/78	J. J. [unclear]	[unclear]
2	ISSUED FOR PERMIT	10/1/78	J. J. [unclear]	[unclear]
3	ISSUED FOR PERMIT	10/1/78	J. J. [unclear]	[unclear]
4	ISSUED FOR PERMIT	10/1/78	J. J. [unclear]	[unclear]
5	ISSUED FOR PERMIT	10/1/78	J. J. [unclear]	[unclear]
6	ISSUED FOR PERMIT	10/1/78	J. J. [unclear]	[unclear]
7	ISSUED FOR PERMIT	10/1/78	J. J. [unclear]	[unclear]
8	ISSUED FOR PERMIT	10/1/78	J. J. [unclear]	[unclear]
9	ISSUED FOR PERMIT	10/1/78	J. J. [unclear]	[unclear]
10	ISSUED FOR PERMIT	10/1/78	J. J. [unclear]	[unclear]

PRO APERTURE CARD

30X

BECHTEL
AND ASSOCIATES
DISCLAIMER PLANT UNIT 1 & 2
COMMERCIAL POWER COMPANY
DIESEL GENERATOR BUILDING
LIGHTING & COMMUNICATION

JOB NO. 7220
DRAWING NO. E-576SH10F1
REV. 8

17

11

8.5

8.5

11

17

17

11

8.5

8.5

11

17

RIDS

8302030596

