



E-587 SH1OF2

17
11
8.5
8.5
11
17

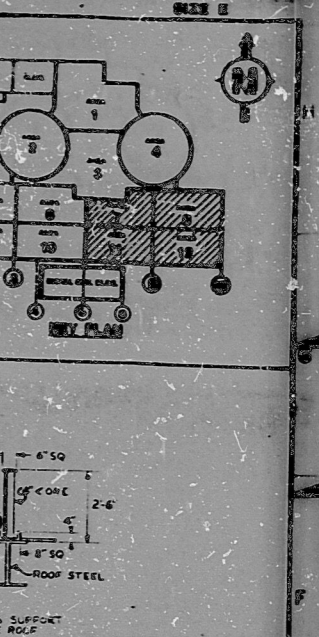

PITCH POLE DETAIL
TYP LTD SUPPORT TURBINE ROOF

PARTIAL PLAN - ELEVATION 655'-03"

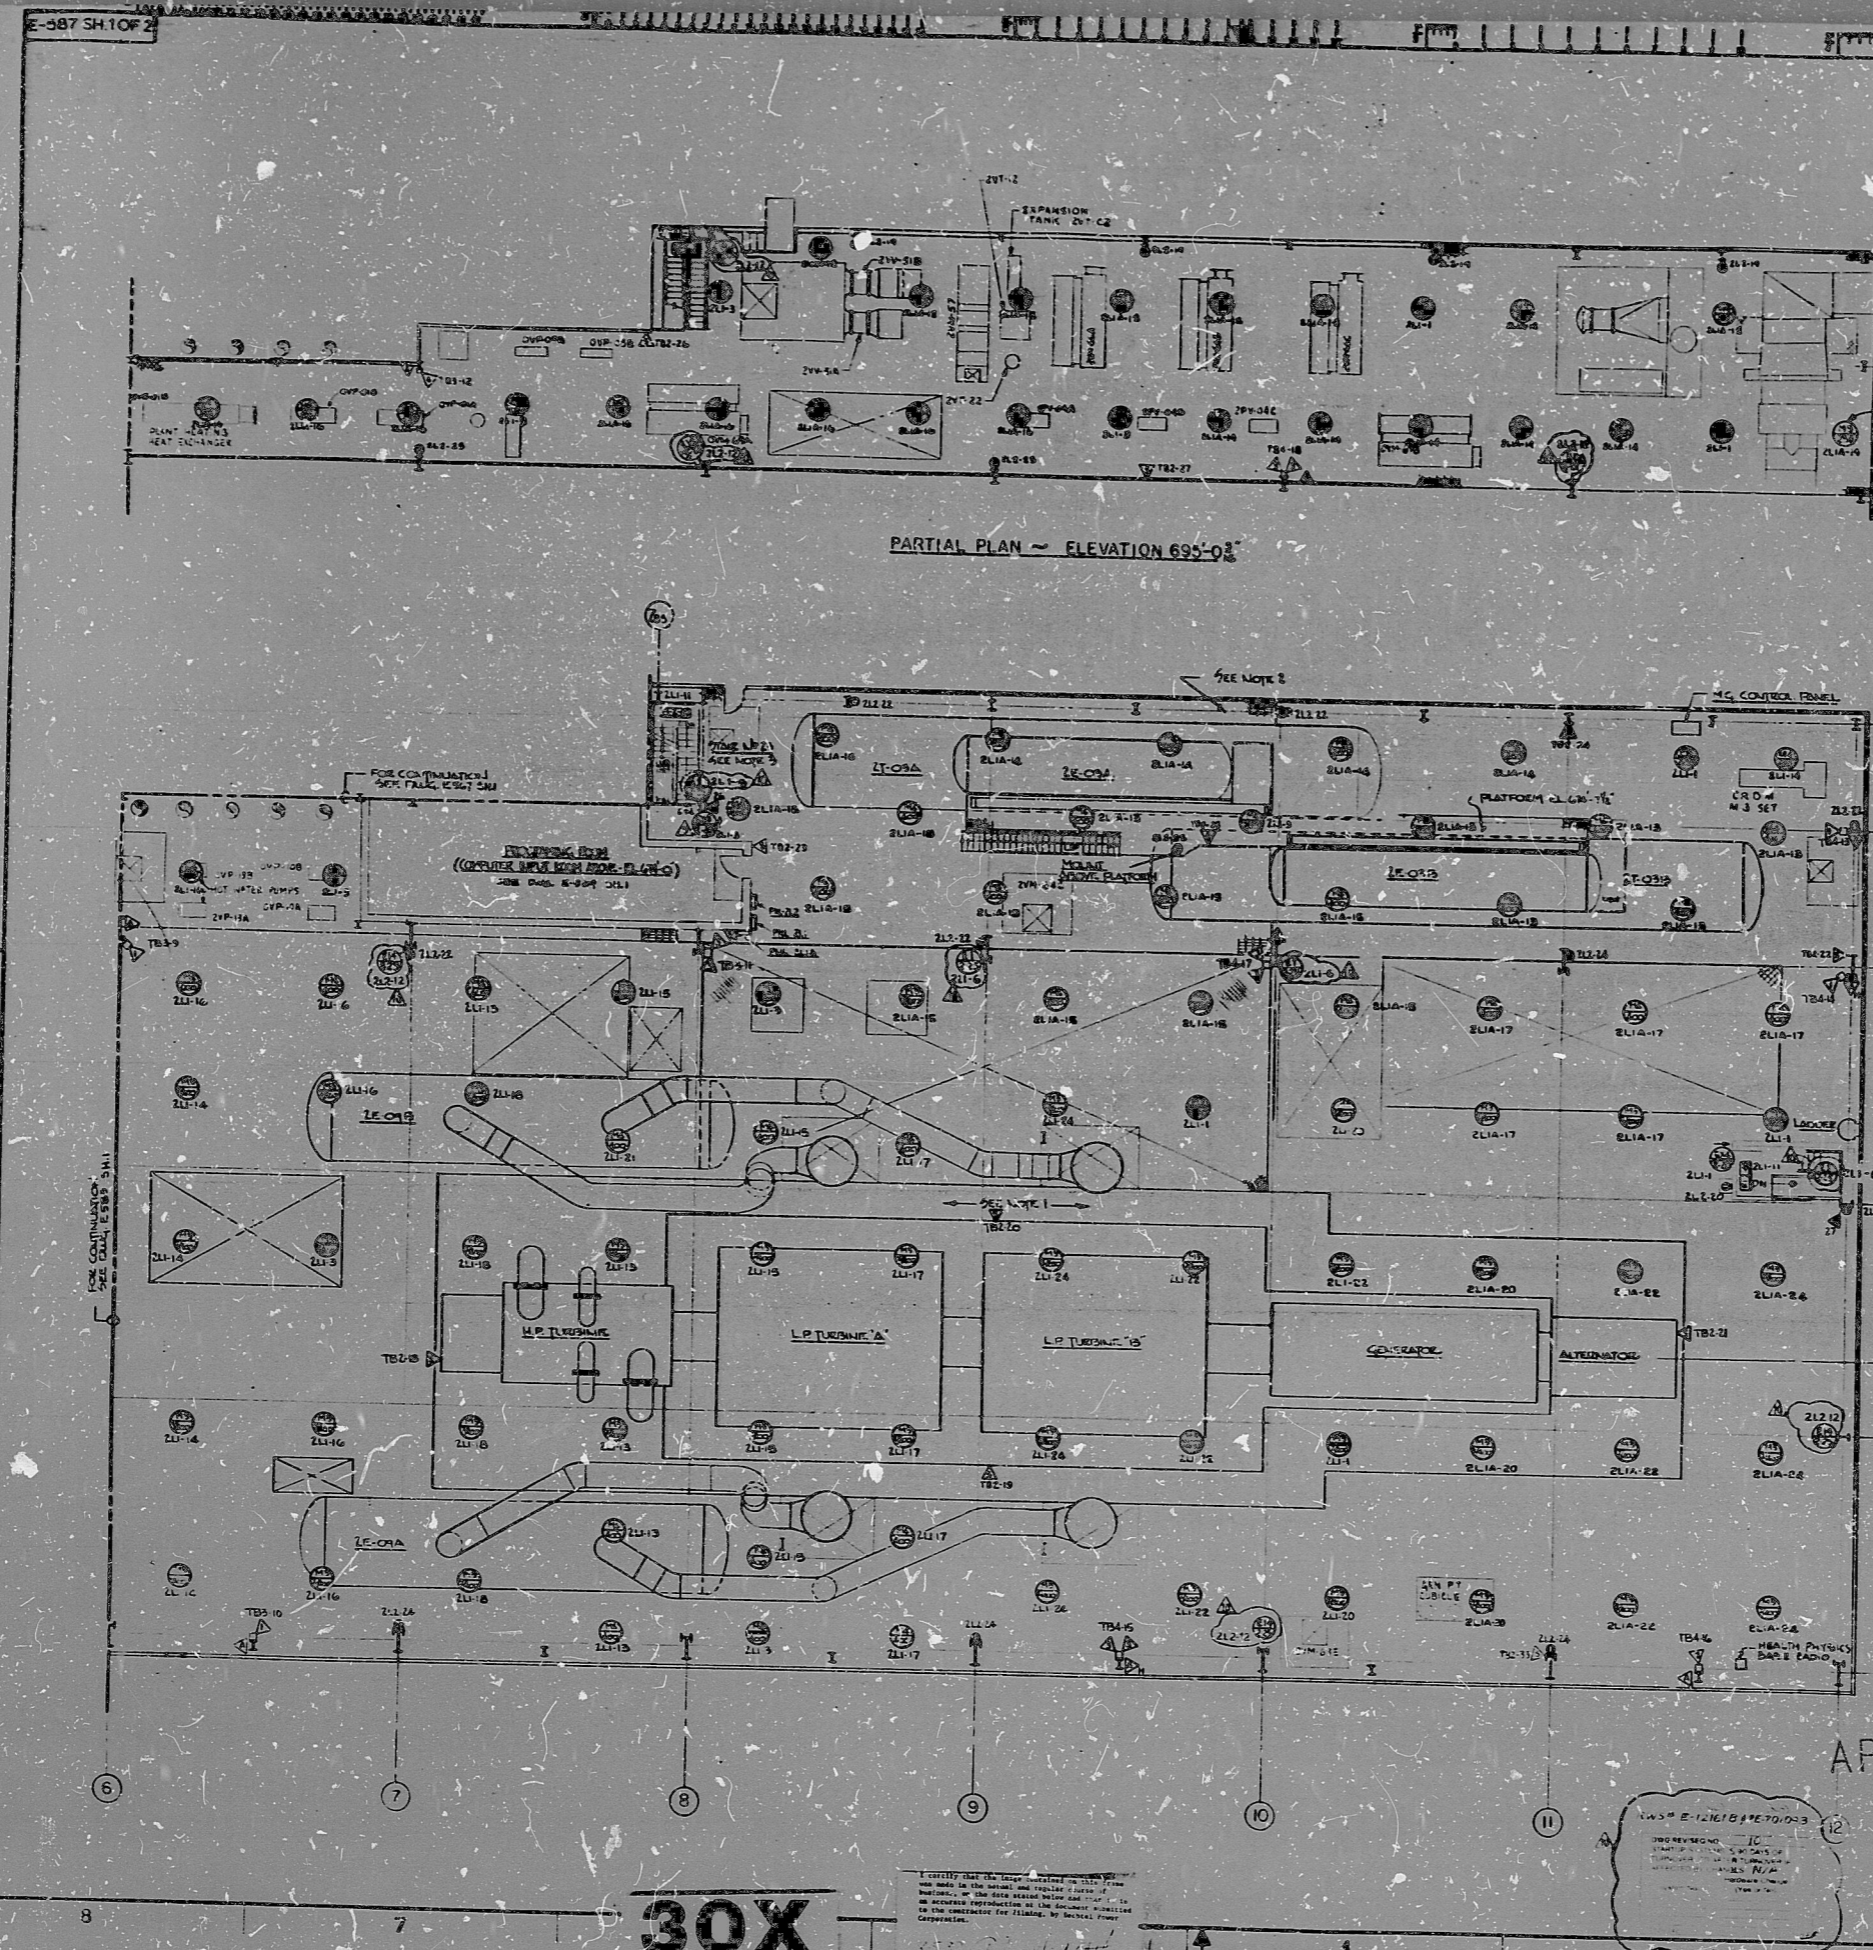

- NOTES**
1. MOUNTING HEIGHT OF VESSEL'S CENTER LOCATED BETWEEN COLUMN LINES L TO Q & 6 TO 12 IS 20'-00"
 2. MOUNTING HEIGHT OF VESSEL'S CENTER LOCATED BETWEEN COLUMN LINES R TO S & 1 TO 12 IS 20'-00"
 3. SEE Dwg. E-587 SH1 FOR INTERMEDIATE MOUNTING LIGHTING.

- REFERENCE DRAWINGS**
- E-43 COMMUNICATION PARTITION NOTES & DETAILS
 - E-44 LIGHTING NOTES, PANELS & DETAILS
 - E-45 LIGHTING PANEL SCHEDULES
 - E-554, 24-1 COMMUNICATIONS SYSTEM PUBLIC ACCESS AND EMERGENCY EVACUATION ALARM SYSTEMS
 - E-555, 24-1 COMMUNICATIONS SYSTEM PUBLIC ACCESS AND EMERGENCY EVACUATION ALARM SYSTEMS
 - E-556, 24-1 COMMUNICATIONS SYSTEM PUBLIC ACCESS AND EMERGENCY EVACUATION ALARM SYSTEMS

NEW EMERGENCY LIGHTING

SYMBOL	DESCRIPTION	QUANTITY
ⓧ	NEW EMERGENCY LIGHTING PER Dwg. E-587 SH1	
ⓧ	NEW EMERGENCY LIGHTING PER Dwg. E-587 SH1	
BEGTEL	
MIDLAND PLANT UNITS 1 & 2 CONSUMERS POWER COMPANY	
LIGHTING AND COMMUNICATION TURBINE BUILDING UNIT 2 ELEVATION 655'-03"	
JOB NO. 7220	DWG. DESIG. NO. E-587 SH1OF2 10

PRC APERTURE CARD

30X

DATE: 11/17/59

SCALE: 1/4" = 1'-0"

DESIGNER: J. H. M. (JHM)

DRAWN: J. H. M. (JHM)

CHECKED: J. H. M. (JHM)

DATE: 11/17/59

SCALE: 1/4" = 1'-0"

DESIGNER: J. H. M. (JHM)

DRAWN: J. H. M. (JHM)

CHECKED: J. H. M. (JHM)

17
11
8.5
8.5
11
17

RIDS

8302040075

