

17"

11"

8.5"

8.5"

11"

17"

17"

11"

8.5"


8.5"

11"

17"

This drawing and the design it covers are the property of BECHTEL. They are hereby loaned and on the borrower's express agreement that they will not be reproduced, copied, loaned, substituted, or used except in the limited way and for the purposes permitted by the lender to the borrower.

6	12/2/82	DELETED 120VAC SUPPLY TO BOX ITEM #29	APPROX
5	3/23/83	REVISED INTLK CONTACT & TML-SHIP #4	APPROX
4	12/1/78	ISSUED FOR WASHINGTON	APPROX

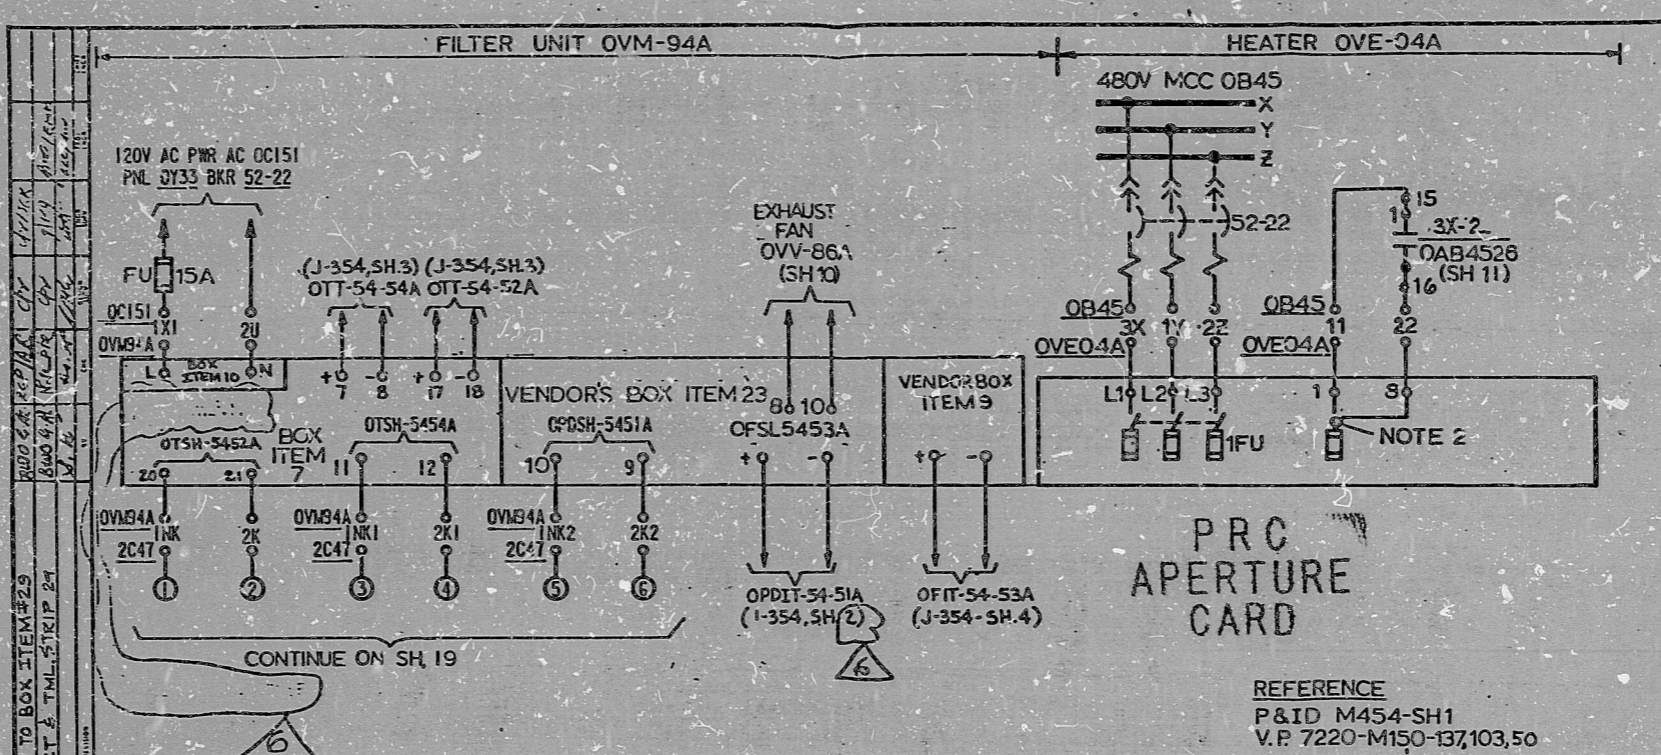

DEVICE TABLE:

OTSH-5452A & 5454A:	FILTER UNIT AIR TEMP SW.
OPDSH-5451A:	FILTER UNIT DIFF PRESS. SW.
FU:	FUSE (BUSS. MIN. 15A)
OTT-5452A & 5454A:	TEMP TRANSMITTER
IFU:	FUSE, A (BY VENDOR)

SPENT PLS HANDLING AREA
 EMERGENCY EXHAUST FILTER UNIT OVM-94A/
 HEATER OVE-04A
 SCHEME CAB4522
 SU.DESIG. 0-6LF

- NOTE**
- FIELD TO INSTALL JUMPER BETWEEN TERM. +8- AT VENDOR'S BOX ITEM 23
 - FIELD TO RELOCATE INTERNAL WIRE FROM TERM. NO.1 TO SPARE TERM. NO.8.

REFERENCE
 P&ID M454-SH1
 V.P. 7220-M150-137,103,50

BECHTEL ANN ARBOR, MICHIGAN		
MIDLAND PLANT UNITS 1 & 2 CONSUMERS POWER COMPANY		
SCHEMATIC DIAGRAM AUX. BLDG. HEATING & VENT. LATION		
JOB No.	DRAWING No.	REV.
7220	E-452(0) SH17	6

I certify that the image contained on this frame was made in the normal and regular course of business, on the date stated below and that it is an accurate reproduction of the document.

RIDS

8302090232

