


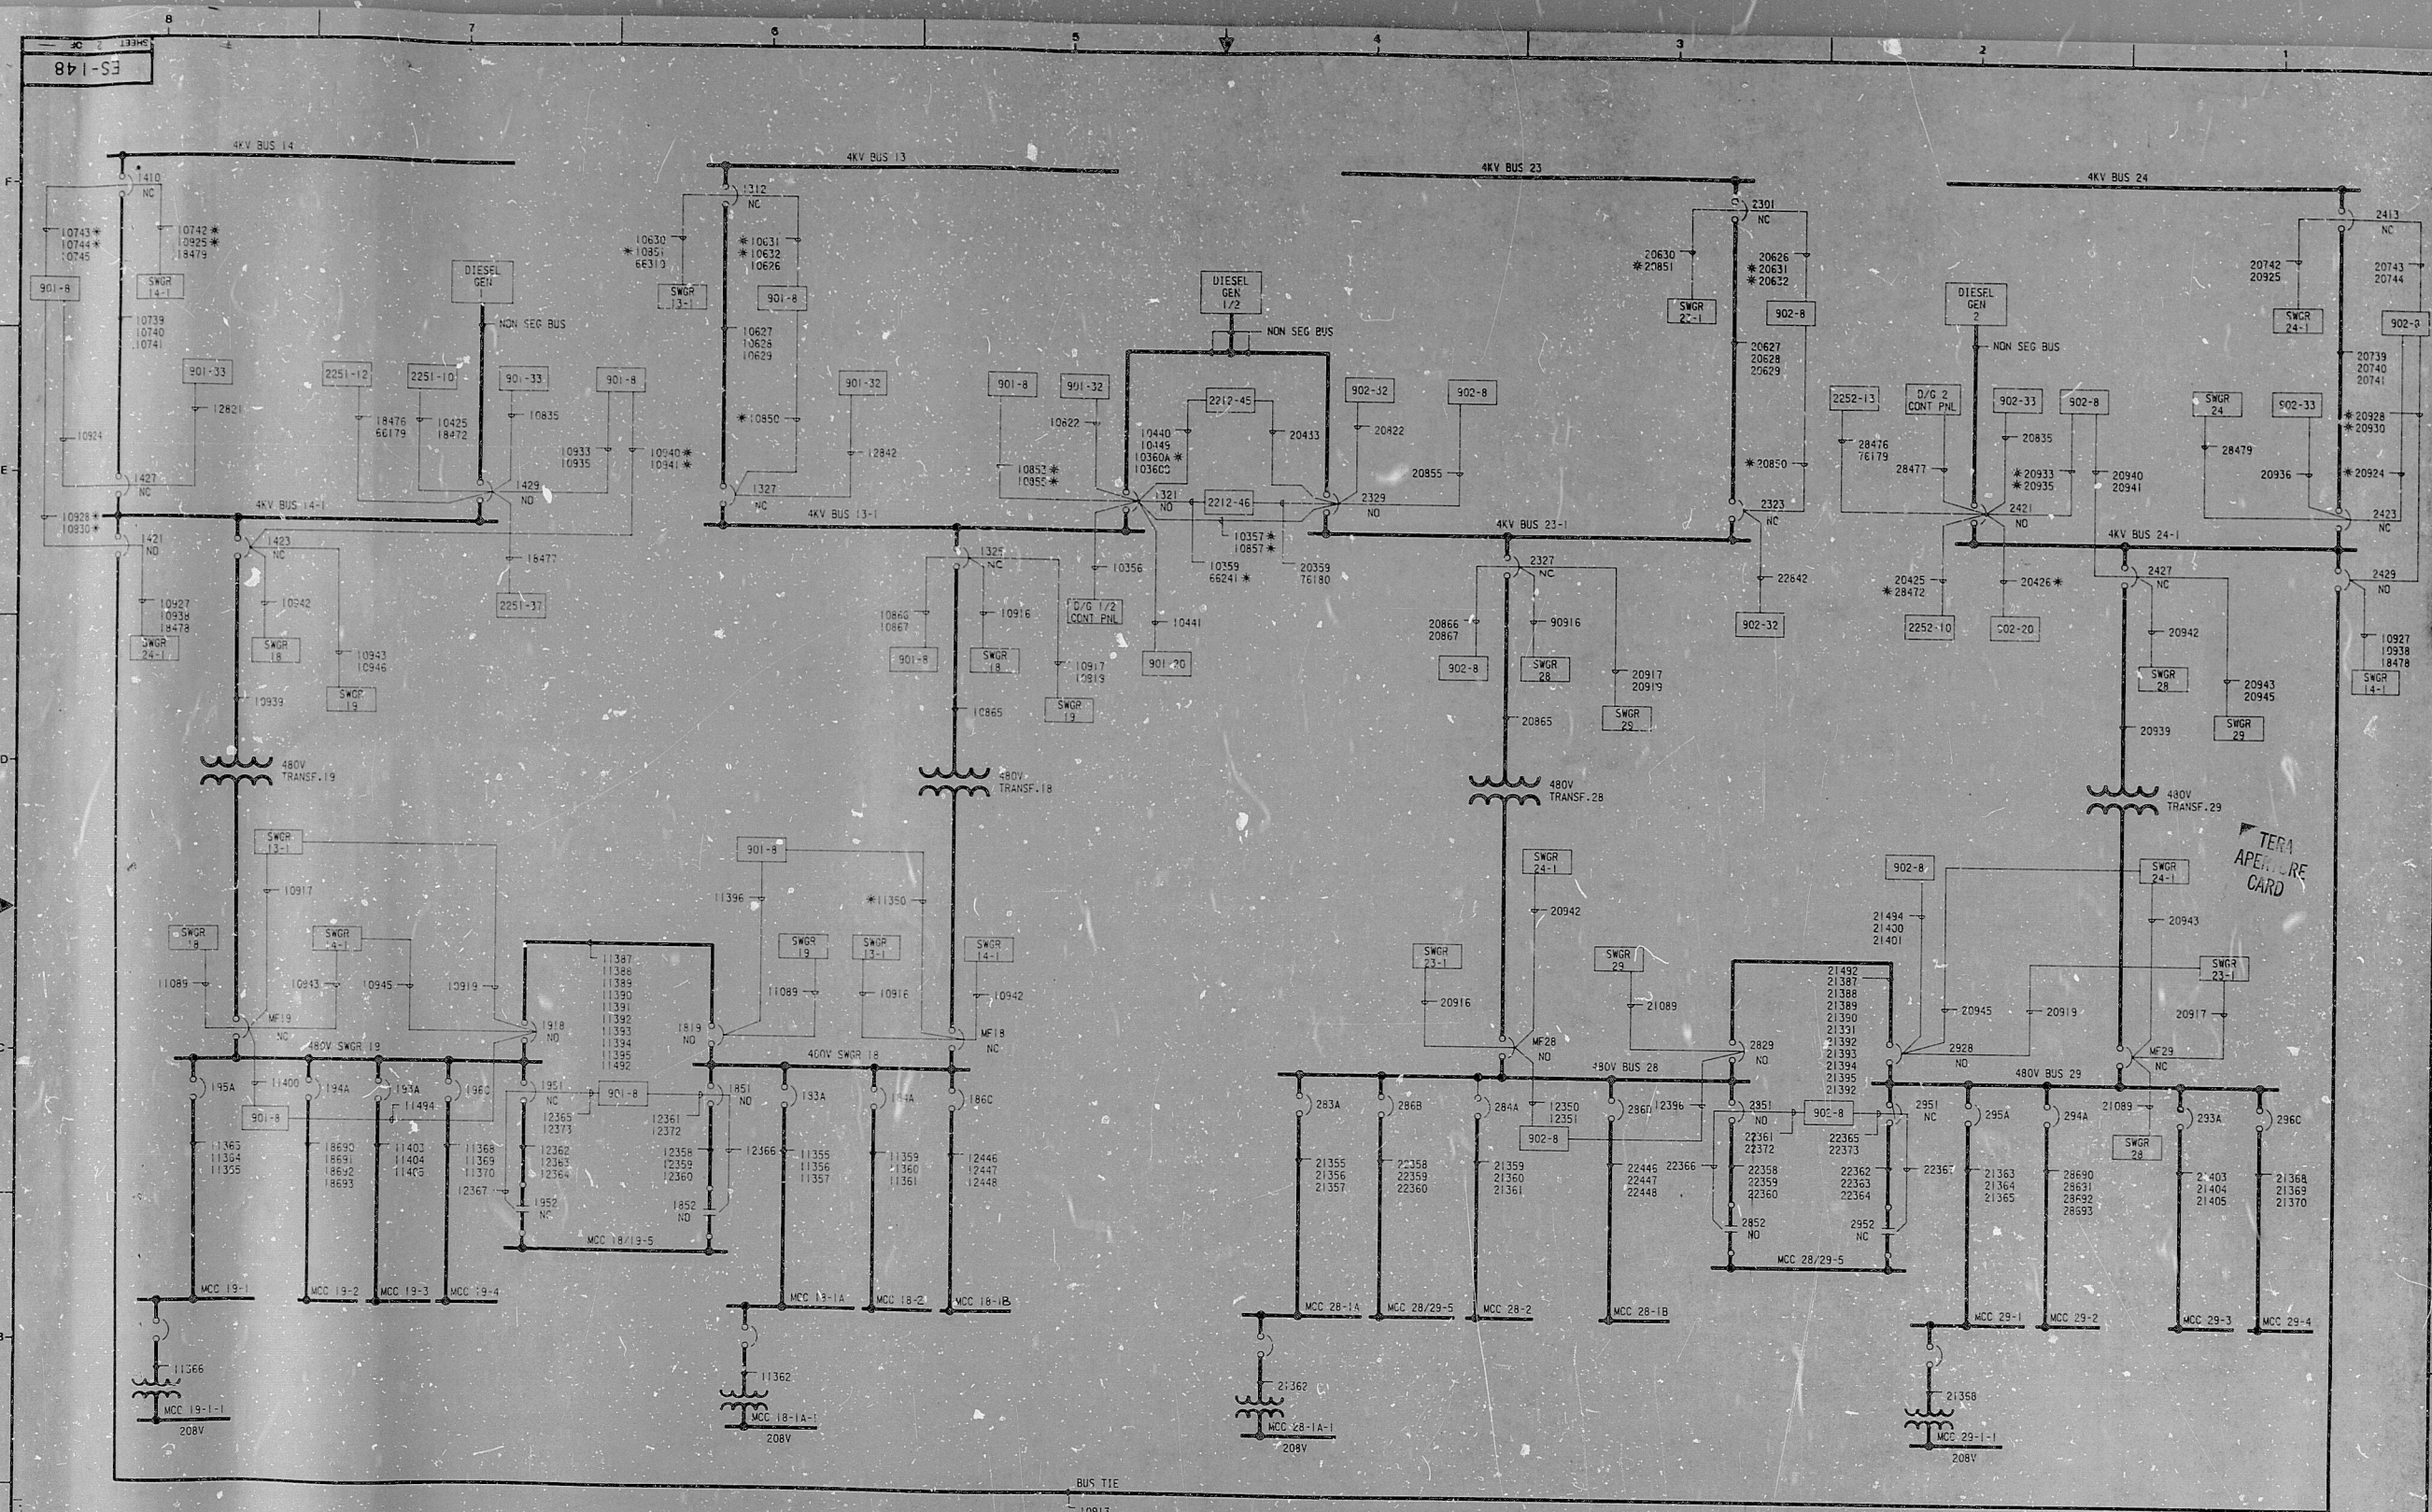

* ISOLATION SWITCHES

NUCLEAR SAFETY RELATED
EQUIPMENT IS SHOWN ON THIS DRAWING

DRAWING RELEASE RECORD					DRAWING RELEASE RECORD				
REV.	DATE RELD.	PREPARED	REVIEWED	APPROVED	PURPOSE	FILM	REV.	DATE RELD.	PREPARED

SCALE
NONE
PROJECT
NUMBER
6401-00

SINGLE LINE DIAGRAM
EMERGENCY POWER SHUTDOWN SYSTEM
QUAD CITIES NUCLEAR POWER STATION
UNIT 1 & 2
COMMONWEALTH EDISON CO.
CHICAGO, ILLINOIS

SARGENT & LUNDY ENGINEERS CHICAGO	
DRAWING NO.	REV.
ES-148	
SHEET	2 OF

DDAELE

RIPS

8109210126

