


PLAN AT EL 809+3 - UNITS 1 & 2
SCALE 1/8" = 1'-0"

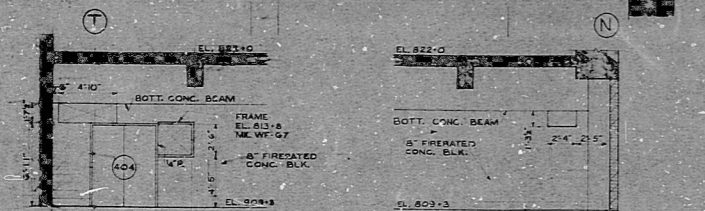

1 ELEVATION COL LINE 73
SCALE 3/16" = 1'-0"
2 ELEVATION COL LINE 73
SCALE 3/16" = 1'-0"

NOTES ON CONCRETE MASONRY

- 1. SEE DWG. O-304A FOR NOTES.
- 2. CONC. BRICK SHALL BE Laid IN TWO AT MINIMUM IN A COMMON RUNNING BOND WITH REINFORCING AND JOINT TREATMENT TO BE AS NOTED ON O-304A.

GENERAL NOTES

- 1. SEE DWG. O-304A AND DOOR SCHEDULE O-304A THRU O-304B FOR ALL DOOR CONSTRUCTION DETAILS.
- 2. SMALL THIS: (C) NOTATES BLOCK WALL TYPES, REFER TO DWG. O-304D FOR WALL TYPE DESIGNATIONS.

ITEMS

SEE DWG. O-304A.

SYMBOLS

- CONCRETE BLOCK
- FIRE-RATED CONCRETE BLOCK
- STEEL STUD AND PLASTER PARTITION
- CONCRETE BRICK

MANUFACTURERS DWG. REFERENCE

- HARDWARE SCHEDULE DM-11-11
- KEYWAY SCHEDULE DM-11-12
- DOOR AND FRAME SCHEDULE DM-11-12
- FREIGHT ELEVATOR DM-11-13
- PASSENGER ELEVATOR DM-11-12

QA CONDITION 1
BLOCK WALL TYPES C & D ONLY
QA CONDITION 3
BLOCK WALL TYPES B & D ONLY

REFERENCE DWGS.

- GENERAL ARRANGEMENT - EL. 809+3 O-304A
- ARCHITECTURAL-AUXILIARY BLDG. EL. 809+3 O-304B
- ARCHITECTURAL DOOR TYPES & DETAILS O-304C
- ARCHITECTURAL DOOR SCHEDULE O-304A THRU O-304B
- CONCRETE PLAN AT EL. 809+3 O-304D
- CABLE ROOM PLAN AT EL. 809+3 O-710A THRU O-710D
- LIGHTING PLAN AT EL. 809+3 O-542
- FIRE SLEEVES-AUX. BLDG. EL. 709+3 (809+3) O-304E

NOTE: WORK THIS DWG. WITH O-304A.

FINISH SCHEDULE - EL. 809+3 - AUXILIARY BUILDING

ROOM NUMBER	ROOM	FLOOR	BASE	WALLS	WALL FINISH AND PAINT	CEILING	CEILING HEIGHT	REMARKS
400	BATTERY ROOM		TERRAZZO	CONCRETE	PAINT	CONCRETE	8'-0"	
401A	STAIR		CONCRETE	CONCRETE	PAINT	CONCRETE	8'-0"	
401B	STAIR		CONCRETE	CONCRETE	PAINT	CONCRETE	8'-0"	
402	EAST PENETRATION ROOM-UNIT 1		CONCRETE	CONCRETE	PAINT	CONCRETE	8'-0"	
403	CONTROL ROOM-UNIT 1		CONCRETE	CONCRETE	PAINT	CONCRETE	8'-0"	
404	CABLE ROOM-UNIT 2		CONCRETE	CONCRETE	PAINT	CONCRETE	8'-0"	
405	STAIR		CONCRETE	CONCRETE	PAINT	CONCRETE	8'-0"	
406	STORAGE		CONCRETE	CONCRETE	PAINT	CONCRETE	8'-0"	
407	LOBBY		CONCRETE	CONCRETE	PAINT	CONCRETE	8'-0"	
408	STAIR		CONCRETE	CONCRETE	PAINT	CONCRETE	8'-0"	
409	STAIR		CONCRETE	CONCRETE	PAINT	CONCRETE	8'-0"	
410	STAIR		CONCRETE	CONCRETE	PAINT	CONCRETE	8'-0"	

PAINTING SCHEDULE - AUXILIARY BLDG. - EL. 809+3

MATERIAL OR EQUIPMENT TO BE PAINTED	SHERWIN-WILLIAMS COLOR & NO.	DPCO COATING SYSTEM CODE	REMARKS
1. STEEL HANDRAIL (AT ALL STAIRS, PLATFORMS, ETC.)	REDUCED ALLEGATOR ACCENT 1736	1A	
2. CHANNEL FRAMES FOR EXTERIOR PERSONNEL DOORS	BLACK	2B	
3. CHANNEL FRAMES FOR INTERIOR PERSONNEL DOORS	HIGH VISIBILITY YELLOW 88733	5A	
4. HOLLOW METAL DOOR FRAMES	HIGH VISIBILITY YELLOW 88733	7A	
5. HOLLOW METAL DOORS - EXTERIOR	HIGH VISIBILITY YELLOW 88733	7A	
6. HOLLOW METAL DOORS - INTERIOR	HIGH VISIBILITY YELLOW 88733	7A	
7. ELEVATOR DOORS - (EL. 809+3 ONLY)	HIGH VISIBILITY YELLOW 88733	7A	

DUKE POWER COMPANY
OCONEE NUCLEAR STATION UNITS 1-3
GENERAL ARRANGEMENT
AUXILIARY BUILDING
PLAN AT EL 809+3
SAFE LOAD PATHS

NO.	REVISIONS	CHKD	APPR	DATE	BY	DATE

DESIGNED BY: DATE: 11/11/57
DRAWN BY: DATE: 11/11/57
CHECKED BY: DATE: 11/11/57
SCALE: 1/8" = 1'-0"

RIDS

8109220580

