


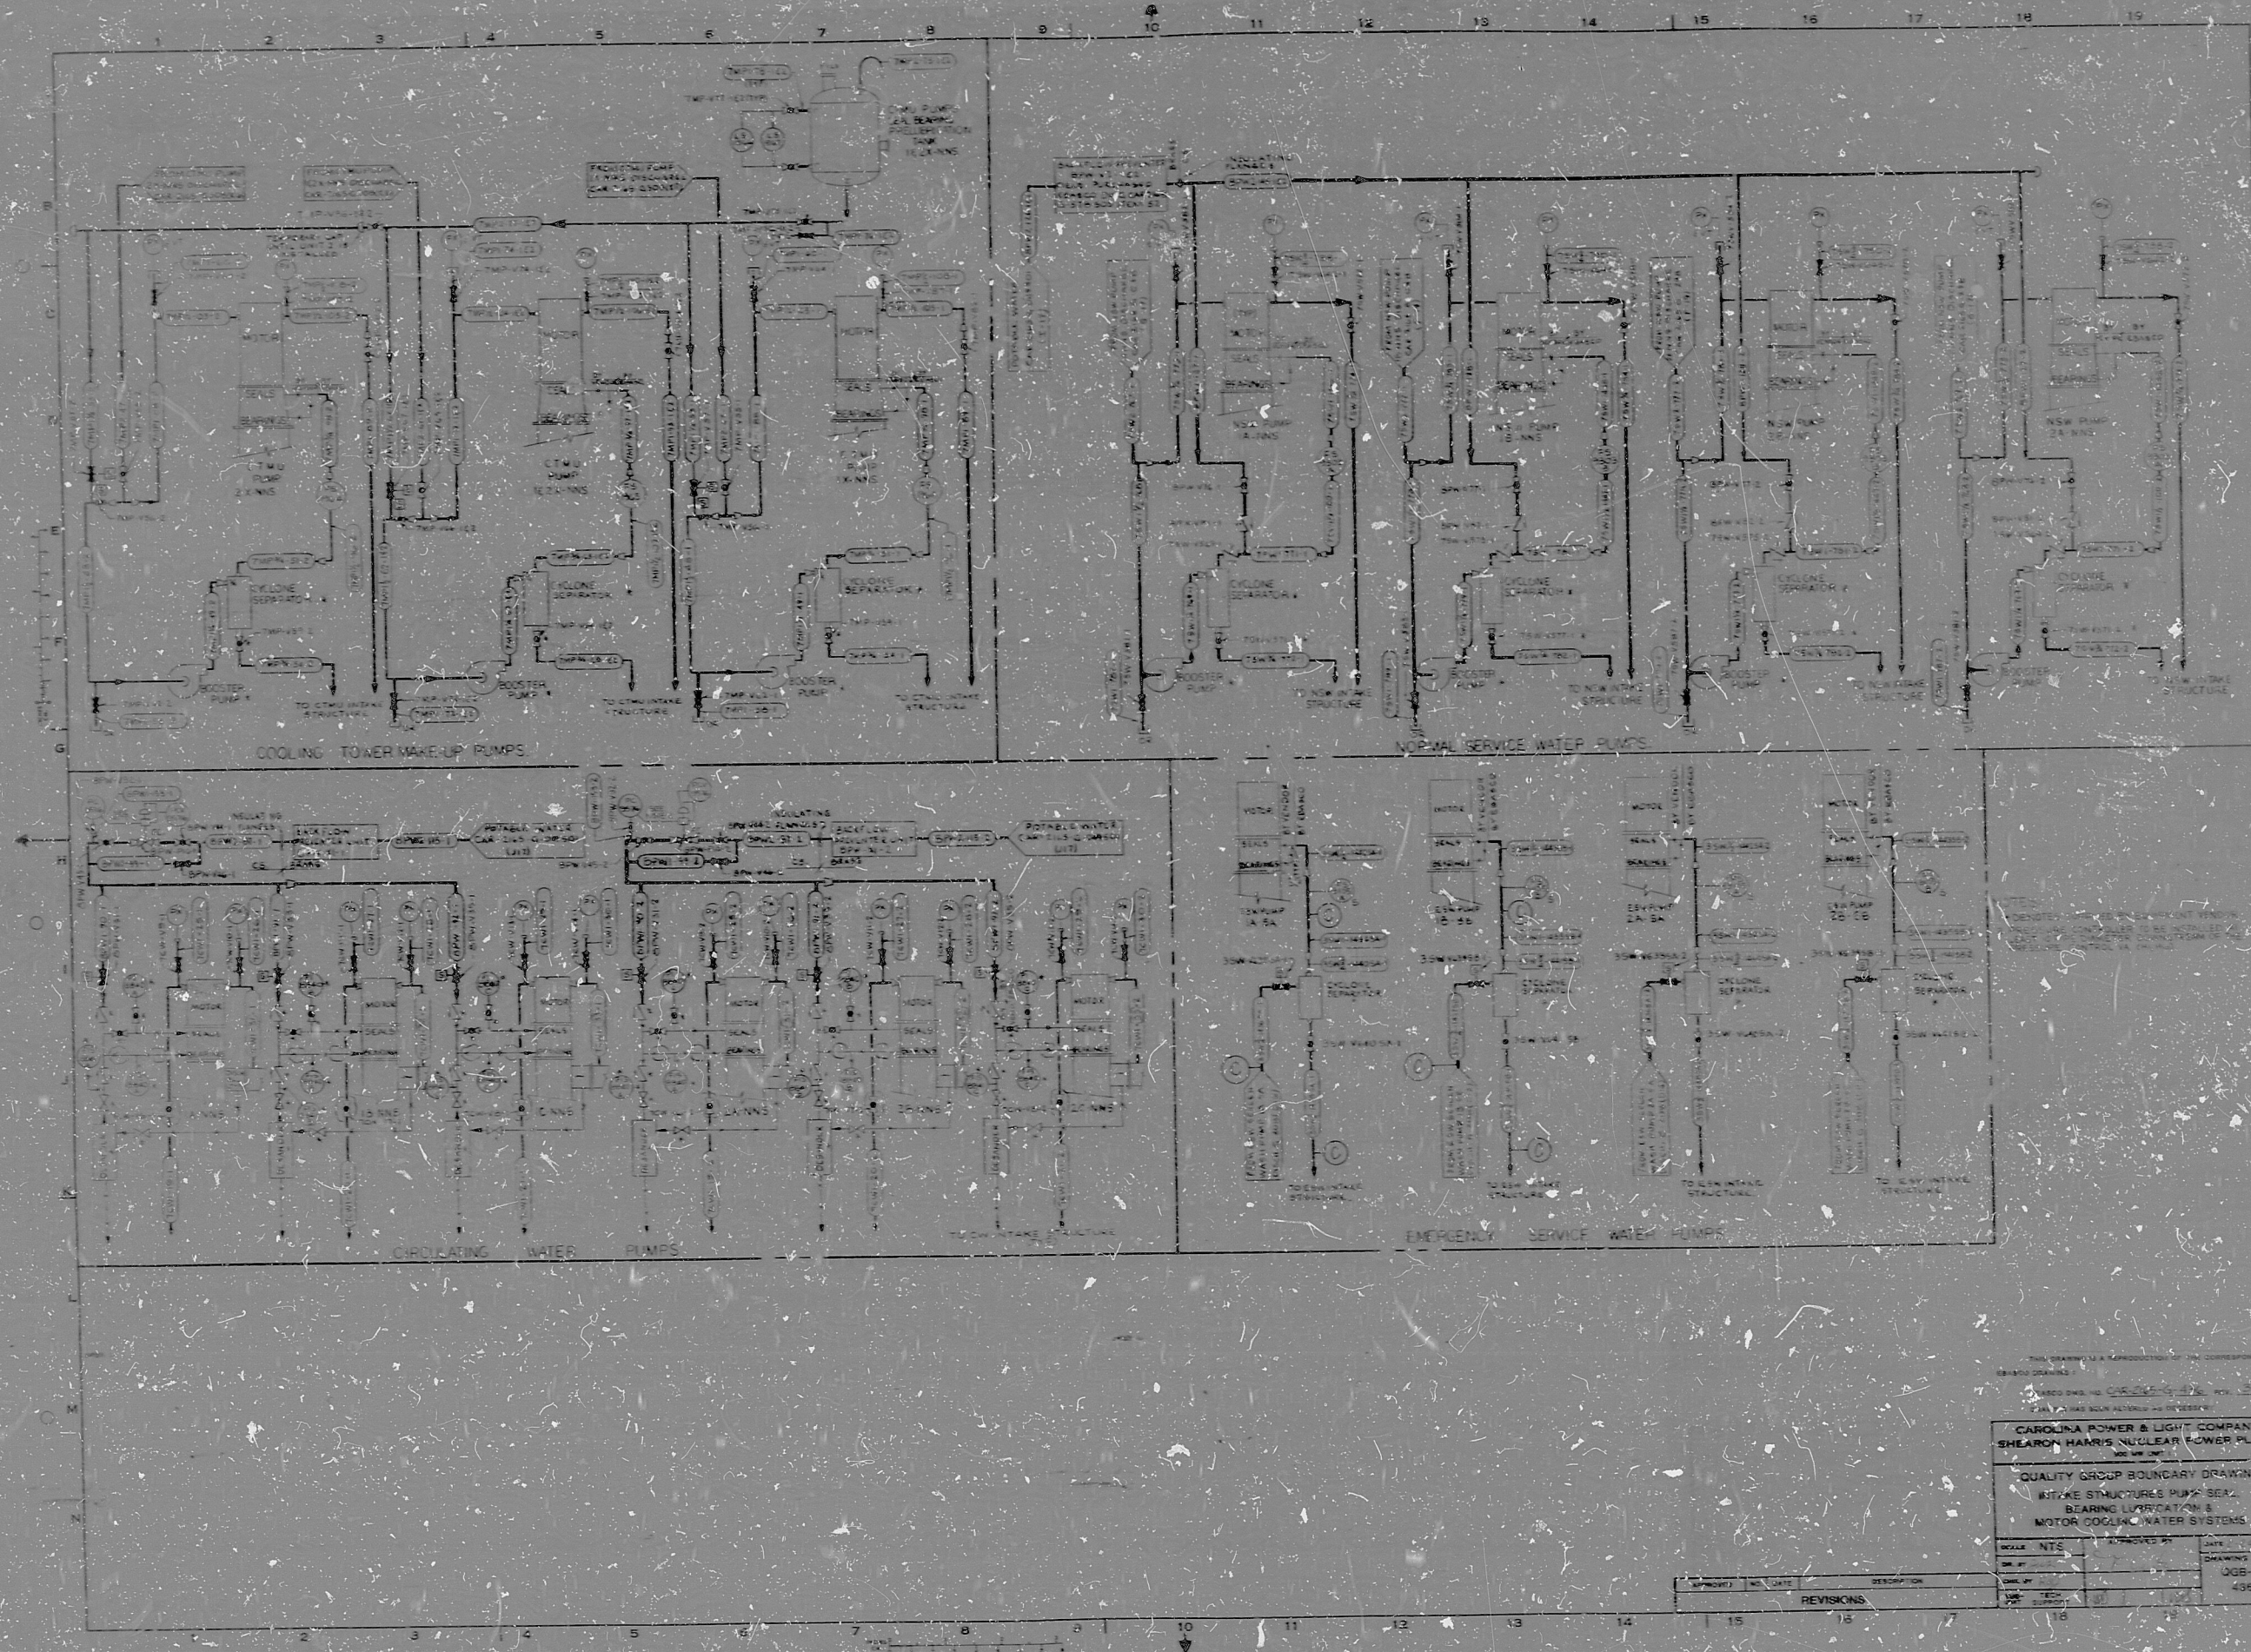

THIS DRAWING IS A REPRESENTATION OF THE CORRESPONDING
PHOTO DRAWING.
THIS DRAWING IS A REPRESENTATION OF THE CORRESPONDING
PHOTO DRAWING.
CAROLINA POWER & LIGHT COMPANY
SHEARON HARRIS NUCLEAR POWER PLANT
NO. 1 UNIT
QUALITY GROUP BOUNDARY DRAWING
INTAKE STRUCTURES PUMP SEAL
BEARING LUBRICATION &
MOTOR COOLING WATER SYSTEMS
SCALE: NTS
DATE: 11-1-68
DRAWING NO.: UGB-S-496
REVISIONS
NO. DATE DESCRIPTION
1 11-1-68 1.00

84 03229 186

DOCKET
NUMBER

ACCESSION
NUMBER

DRAWING NUMBER

SHEET REV.

ORIGINAL

