


THIS DOCUMENT IS NOT TO BE USED FOR CONSTRUCTION

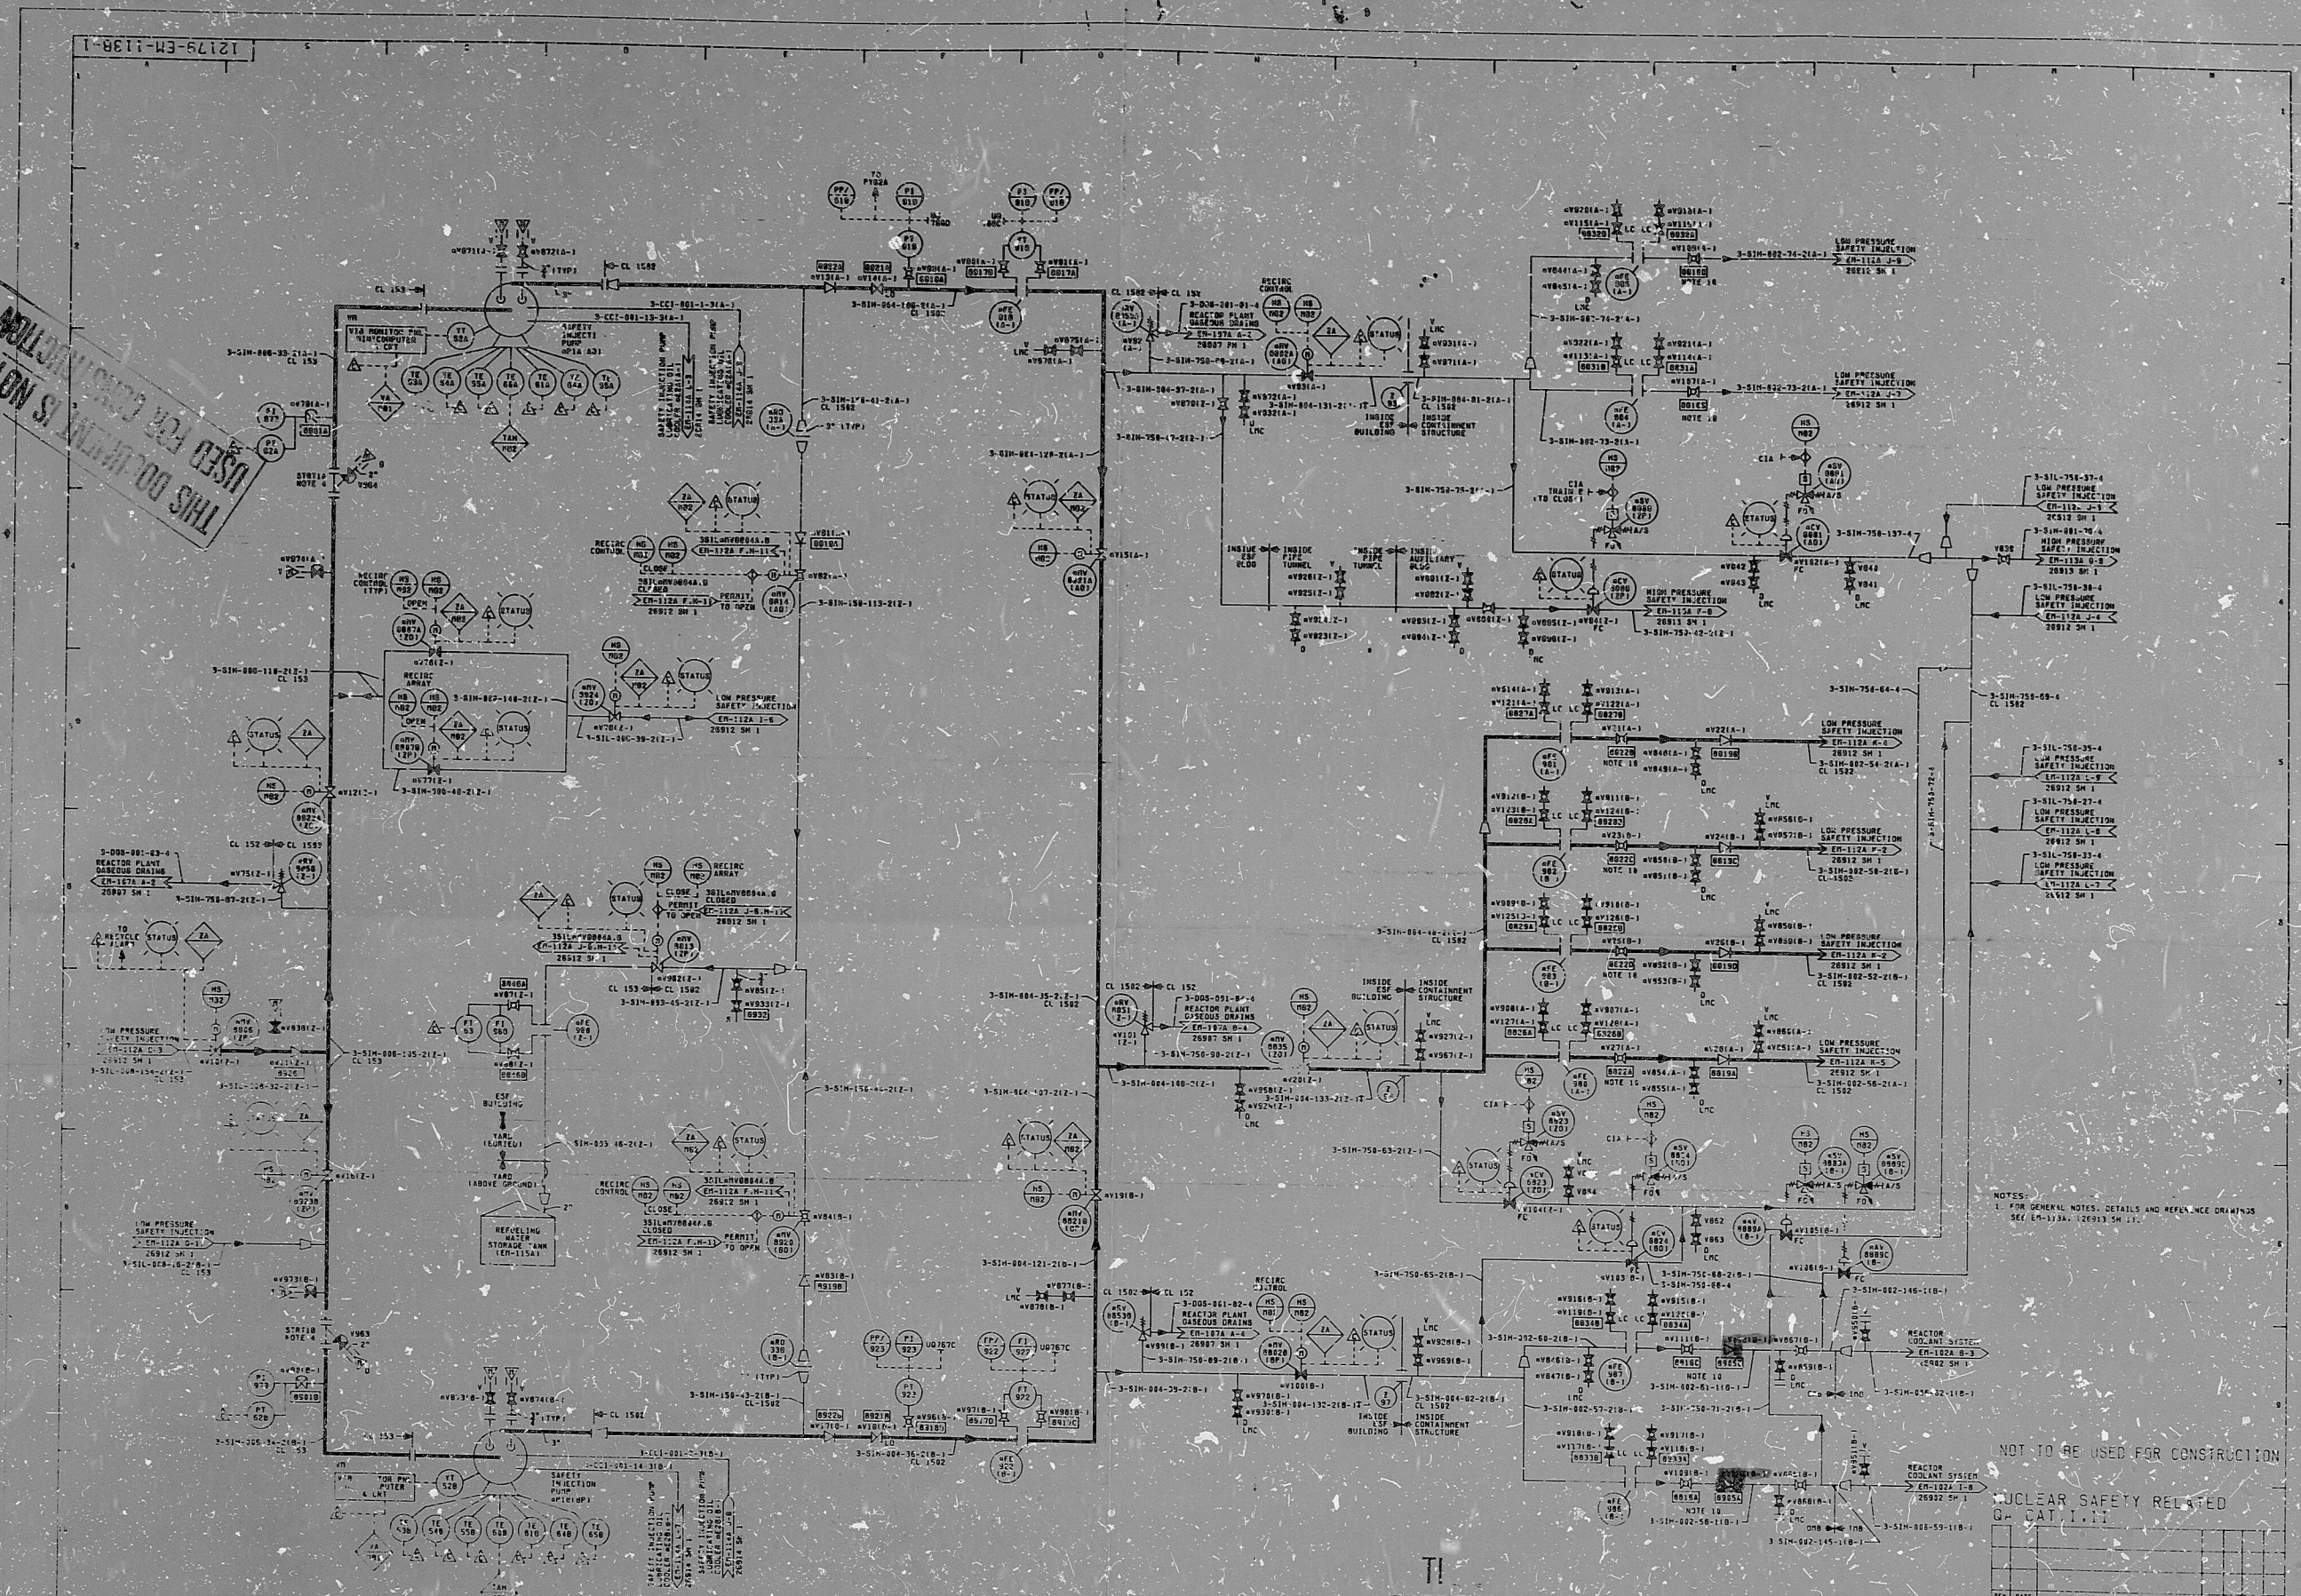

TI
APERTURE
CARD

NOT TO BE USED FOR CONSTRUCTION
NUCLEAR SAFETY RELATED
G. CAT. 1.1

REV.	DATE	DESCRIPTION	BY	CHK.	APP.
1	10/1/78	ISSUED FOR CONSTRUCTION	J. L. HARRIS	J. L. HARRIS	J. L. HARRIS

NORTHEAST NUCLEAR ENERGY COMPANY
SUBSIDIARY OF
NORTHEAST UTILITIES

TITLE: HILLSTONE NUCLEAR POWER STATION UNIT NO. 3
PIPING & INSTRUMENTATION DIAGRAM
HIGH PRESSURE SAFETY INJECTION

DATE: 10/1/78
DRAWN BY: J. L. HARRIS
CHECKED BY: J. L. HARRIS
APPROVED BY: J. L. HARRIS

SCALE: 1/4" = 1'-0"

25212-20013-SH-1 OF 2

8403260193

8403260193

PDR RIDS

8403260193

