


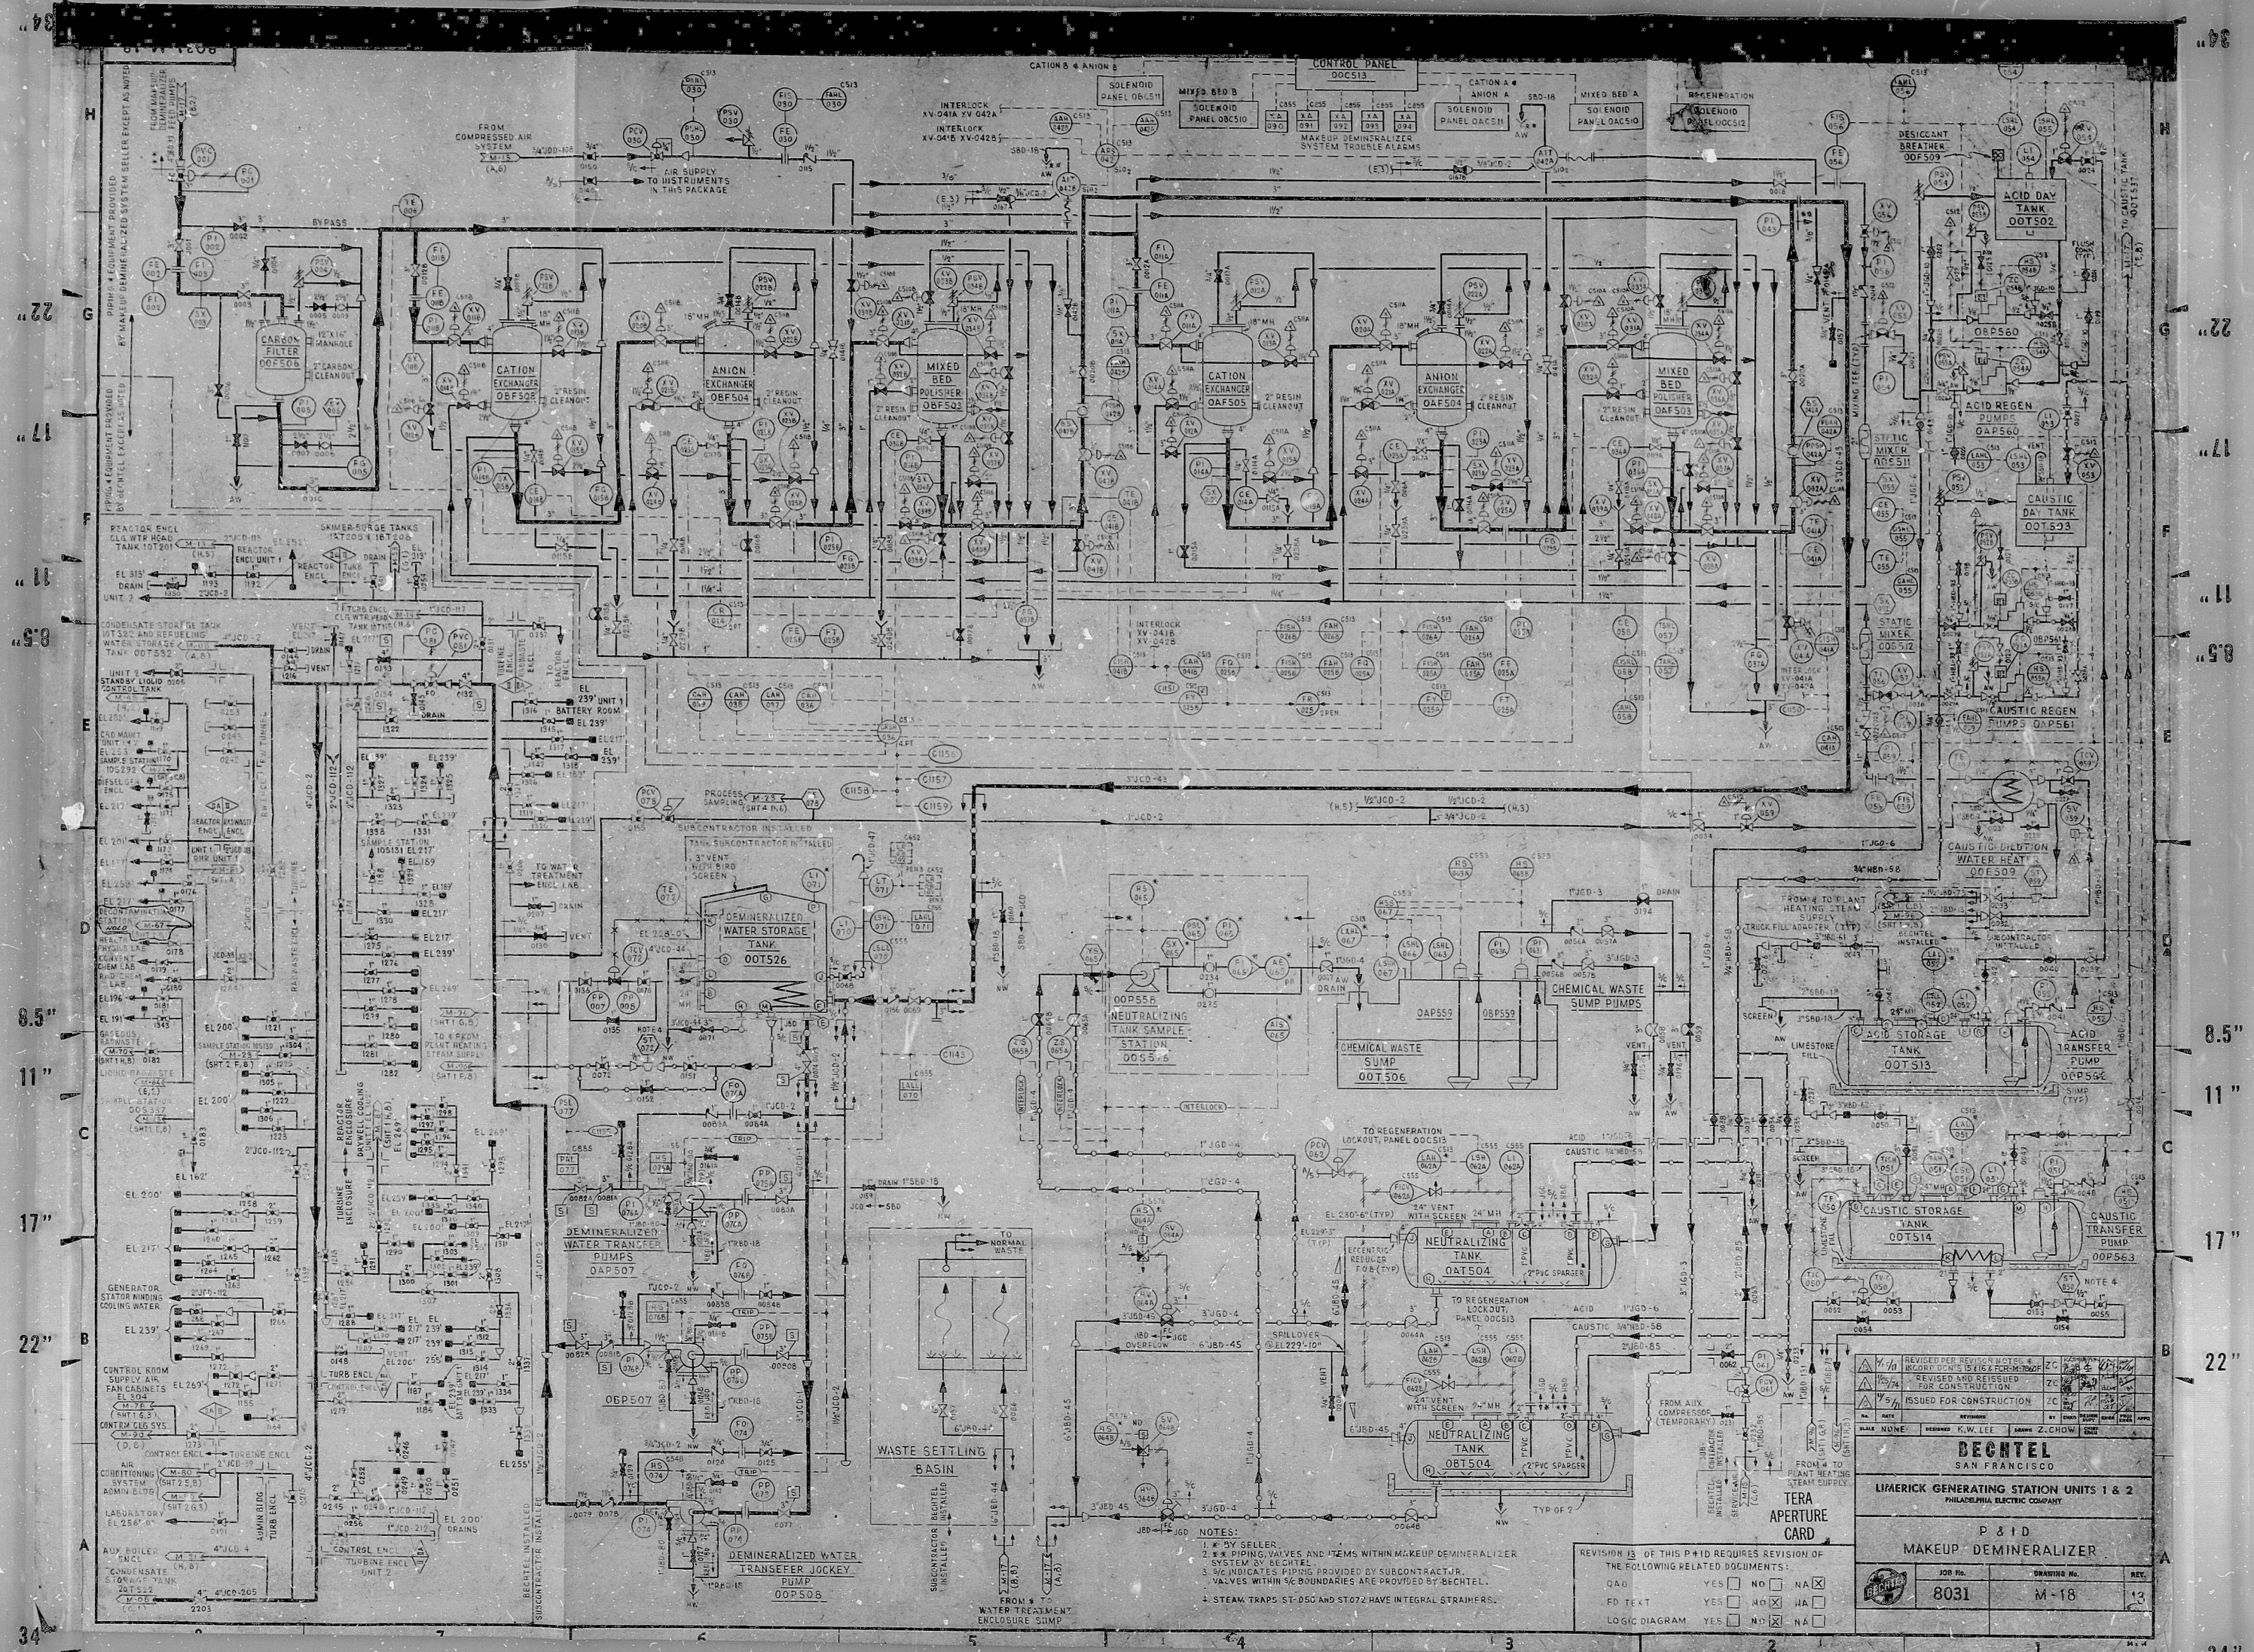

REVISION 13 OF THIS P&ID REQUIRES REVISION OF THE FOLLOWING RELATED DOCUMENTS:

DOC NO	YES	NO	NA
QAD	☐	☐	☒
FD TEXT	☐	☐	☒
LOGIC DIAGRAM	☐	☐	☒

TERA APERTURE CARD

DECHTEL
SAN FRANCISCO

LIMERICK GENERATING STATION UNITS 1 & 2
PHILADELPHIA ELECTRIC COMPANY

P & I D
MAKEUP: DEMINERALIZER

JOB NO.	DRAWING NO.	REV.
8031	M-18	13

- NOTES:
- 1. BY SELLER
 - 2. PIPING, VALVES AND ITEMS WITHIN MAKEUP DEMINERALIZER SYSTEM BY BECHTEL
 - 3. 3/4" INDICATES PIPING PROVIDED BY SUBCONTRACTOR. VALVES WITHIN 5' BOUNDARIES ARE PROVIDED BY BECHTEL.
 - 4. STEAM TRAPS ST-050 AND ST-072 HAVE INTEGRAL STRAINERS.

RIDS

8110070503

