



REF
H
(82-07)

ADMINISTRATION BUILDING HOT MAINTENANCE SHOP - EVAPORATIVE CONDENSER 00E967, SUMP WATER LEVEL CONTROL & SUMP WATER HEATER 00E966.

- NOTES:
1. MOTORIZED BALL VALVE HAS 120 VAC, 1-PHASE UNIT-DIRECTIONAL MOTOR.
 2. LOGIC DIAGRAM TO BE REVISED TO AGREE WITH VENDOR'S SCHEME.

NOTES:

1. THIS FUNCTIONAL DESCRIPTION DRAWING IS BASED ON P & ID N-82, SH-1, T-1, O, SH-2, REV. 0 AND WRITTEN FUNCTIONAL DESCRIPTION REV. B.

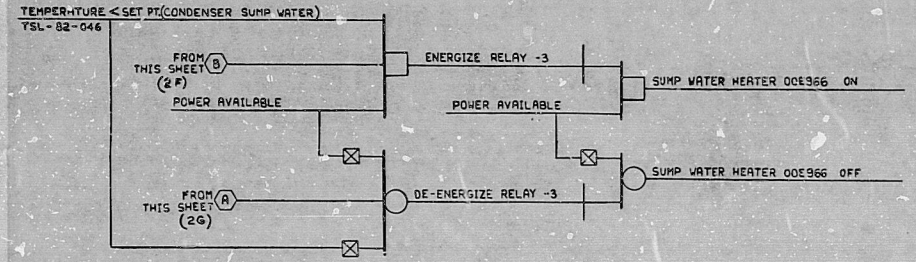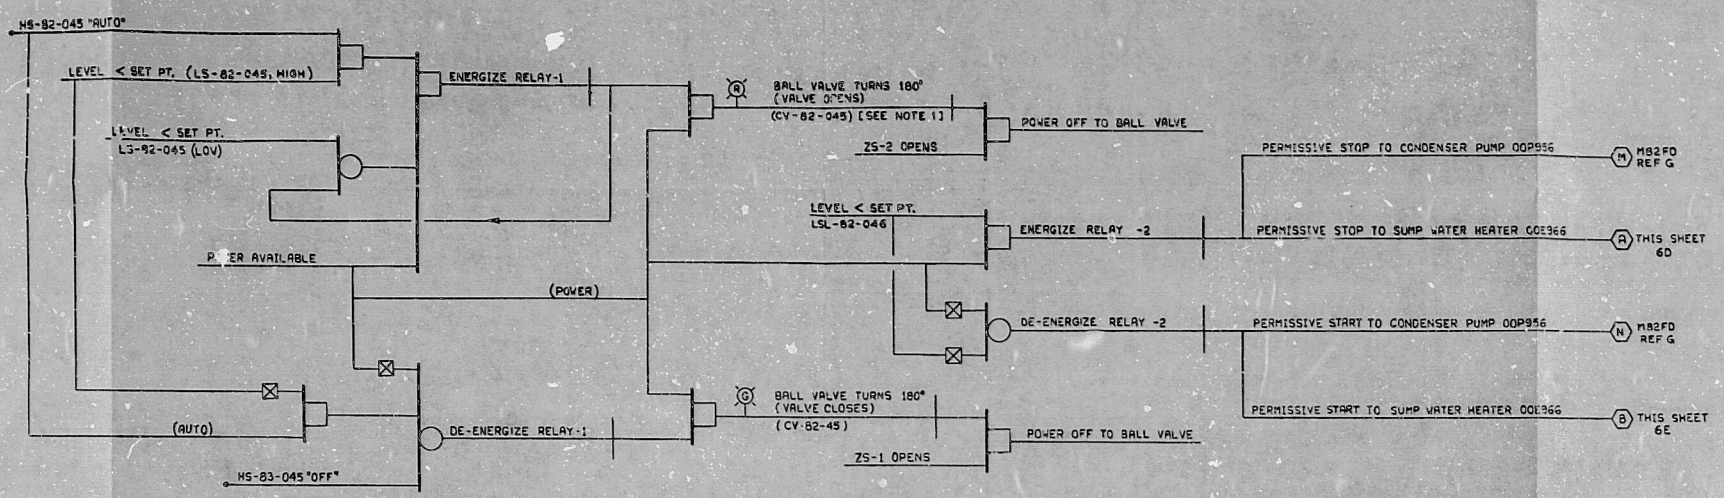


00C573
HS-82-045
MAINT. CONTACTS

REFERENCE SCHEMATIC DRAWINGS		
REF NO.	DWG NO.	TITLE
H	E-542	ADMINISTRATION COMPLEX, OFFICES & SHOPS EVAPORATIVE CONDENSER, SUMP WATER LEVEL CONTROL, SUMP WATER HEATER & WATER TREATMENT SYSTEM - COMMON.
J	E-1425	LIGHTING, POWER AND FIRE ALARM PANEL.

REF
J
(82-11)

ADMINISTRATION BUILDING HOT MAINTENANCE SHOP - DECONTAMINATION SHOWER ELECTRIC WALL HEATER 00E969.

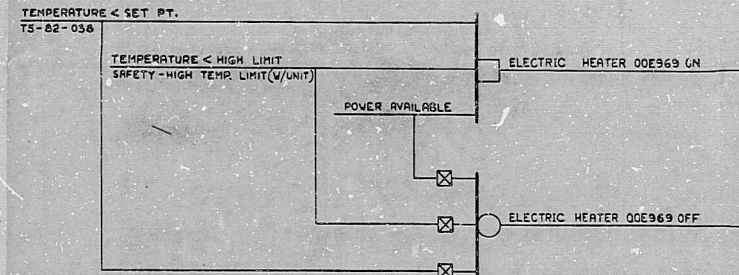

TERA
APERTURE
CARD

ISSUED FOR APPROVAL		4 25 82	
DATE	DESIGNED BY	CHECKED BY	DATE
	V.C. JOSTICO	V. JOSTICO	4 25 82
BECHTEL SAN FRANCISCO			
LIMERICK GENERATING STATION UNITS 1 & 2 PHILADELPHIA ELECTRIC COMPANY			
FUNCTIONAL DESCRIPTION ADMINISTRATION BUILDING HOT MAINTENANCE SHOP-HVAC			
JOB NO.	DESIGNING NO.	SHEET	
8031	M-82FD	SHEET 8 OF 8	
REF. NO. J		SHEET 8 OF 8	

R105

8110140068

