

22

22

22

22

22



22

22

22

22

22

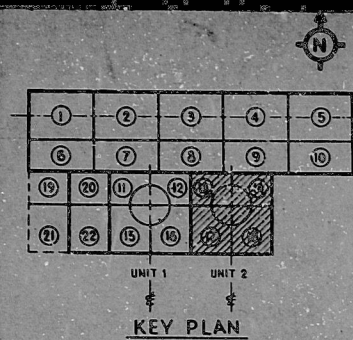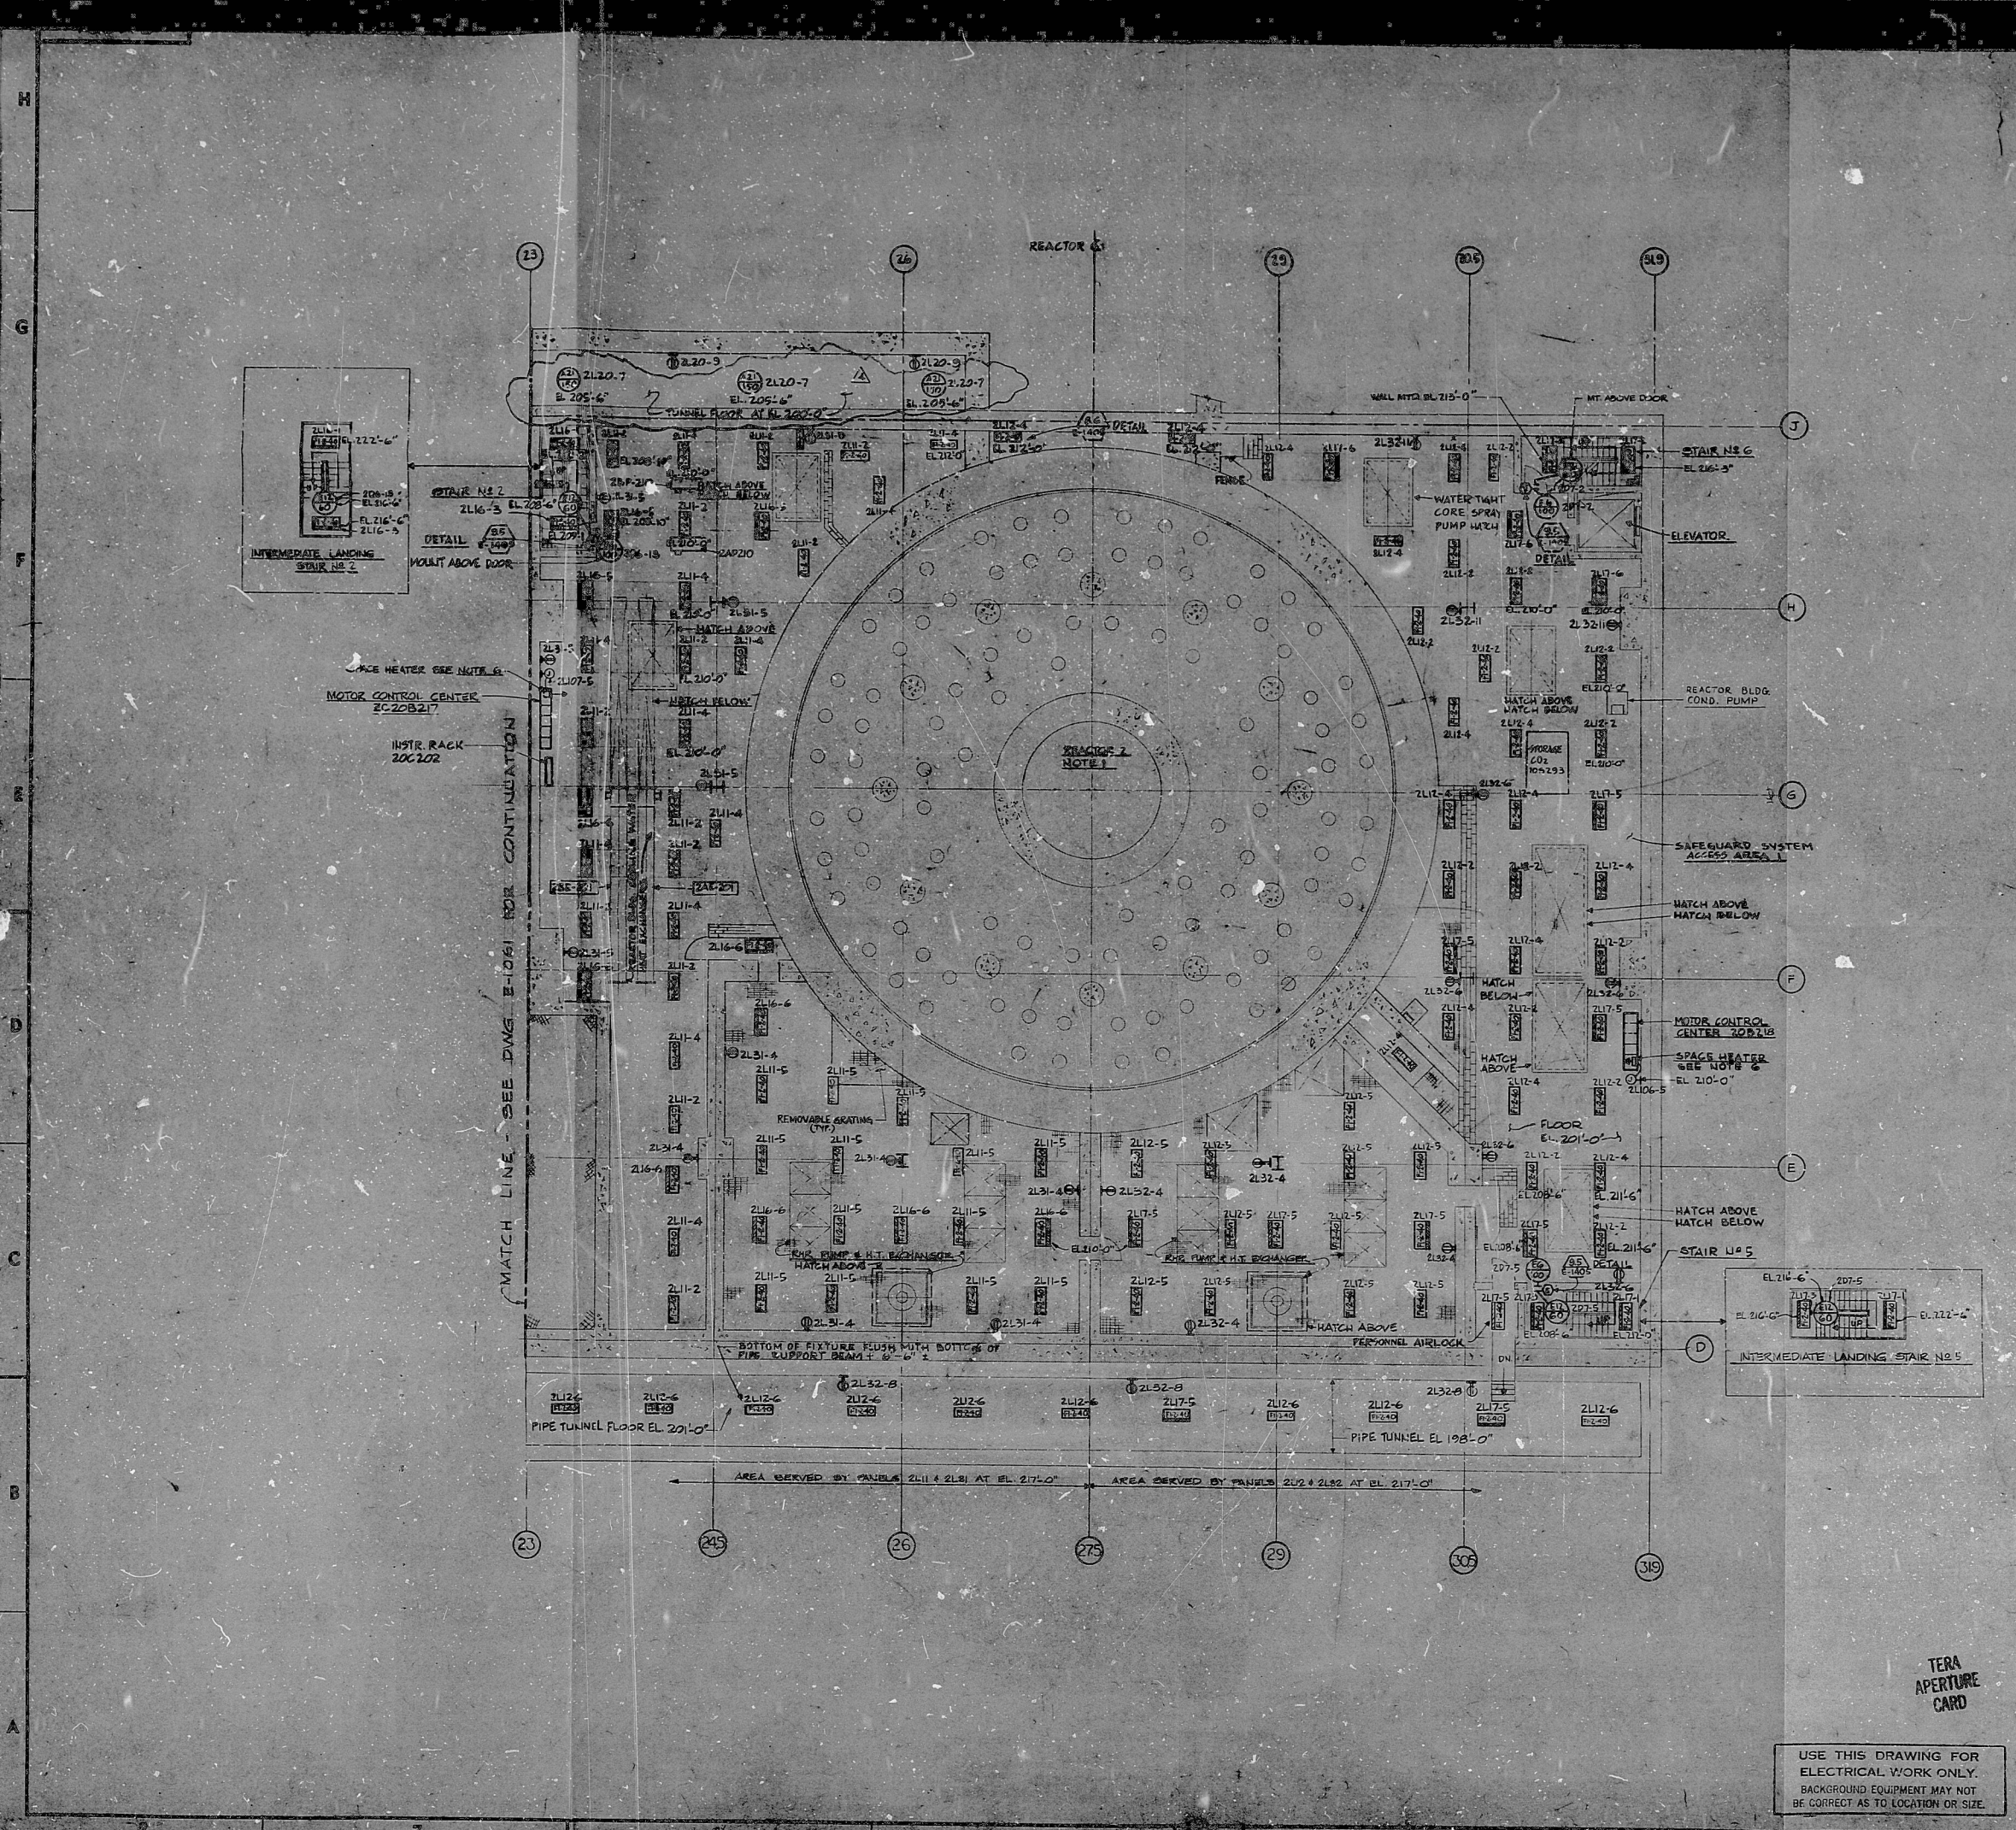

NOTES

1. LIGHTING & RECEPTACLE BRANCH CIRCUIT CONDUITS IN ROOMS NEXT TO REACTOR DRYWALL WALL SHALL NOT PENETRATE INTO ANY OTHER ADJACENT ROOM. INSTALL BRANCH CIRCUITS IN CONTINUOUS RACEWAY UP TO MINIMUM ELEVATION OF 206'-0".
2. BRANCH CIRCUIT WIRING FOR NORMAL AC/DC EMERGENCY LIGHTS SHALL BE INSTALLED IN SEPARATE CONDUIT. SEE ITEM 1-19, DWG. E-1405.
3. MOUNT ALL FIXTURES 12'-0" ABOVE FLOOR EXCEPT WHERE NOTED OTHERWISE.
4. MOUNT FIXTURE ON SURFACE MOUNTED BOX AT EL. 196'-0" OR OTHERWISE AS NOTED.
5. CONNECT TO PREWIRED SPACE HEATER FURNISHED IN EACH MOTOR CONTROL CENTER CUBICLE. EACH CUBICLE HEATER 1500 WATTS (8500 BTU/H).
6. AC/DC LIGHTING BRANCH CIRCUIT WIRING SHALL BE INSTALLED IN SEPARATE CONDUIT. SEE ITEM 1-21, DWG. E-1405.

REFERENCE DRAWINGS

- E-1405 LIGHTING NOTES, SYMBOLS & DETAILS
- E-1374 REFR. DIAGRAM, LIGHTING & POWER PANELS, BOARDS-UNIT 2 TURBINE AND REACTOR BUILDINGS
- E-1425 LIGHTING, POWER & FIRE ALARM PANEL SCHEDULES

1/1/76	INCORPORATED PER E-518	KA	9/1/76	1/1/76
1/1/76	INCORPORATED PER E-314	KA	9/1/76	1/1/76
1/1/76	REVISED CTS. 2L12-3	KA	9/1/76	1/1/76
1/1/76	2L12-116 NOTE 6	KA	9/1/76	1/1/76
1/1/76	GENERAL ELEVATION UPATED BACK GROUND REVISED TO LAYOUT & CIRCUMSTANCES ADDED LIT. EXT. PANEL BOARD FOR EMERGENCY LIGHTS & WATER-RESISTANT TRANSFORMER	KA	9/1/76	1/1/76
1/1/76	PERIOD FOR CONSTRUCTION	SD	1/1/76	1/1/76

BECHTEL SAN FRANCISCO		
LIMERICK GENERATING STATION UNITS 1 & 2 PHILADELPHIA ELECTRIC COMPANY		
LIGHTING REACTOR BUILDING UNIT 2 ABOVE EL. 201'-0"		
FOR NO.	DRAWING NO.	REV.
8031	E-1081	4

USE THIS DRAWING FOR ELECTRICAL WORK ONLY. BACKGROUND EQUIPMENT MAY NOT BE CORRECT AS TO LOCATION OR SIZE.

RIDS

8110190429

