


11825-FE-IN

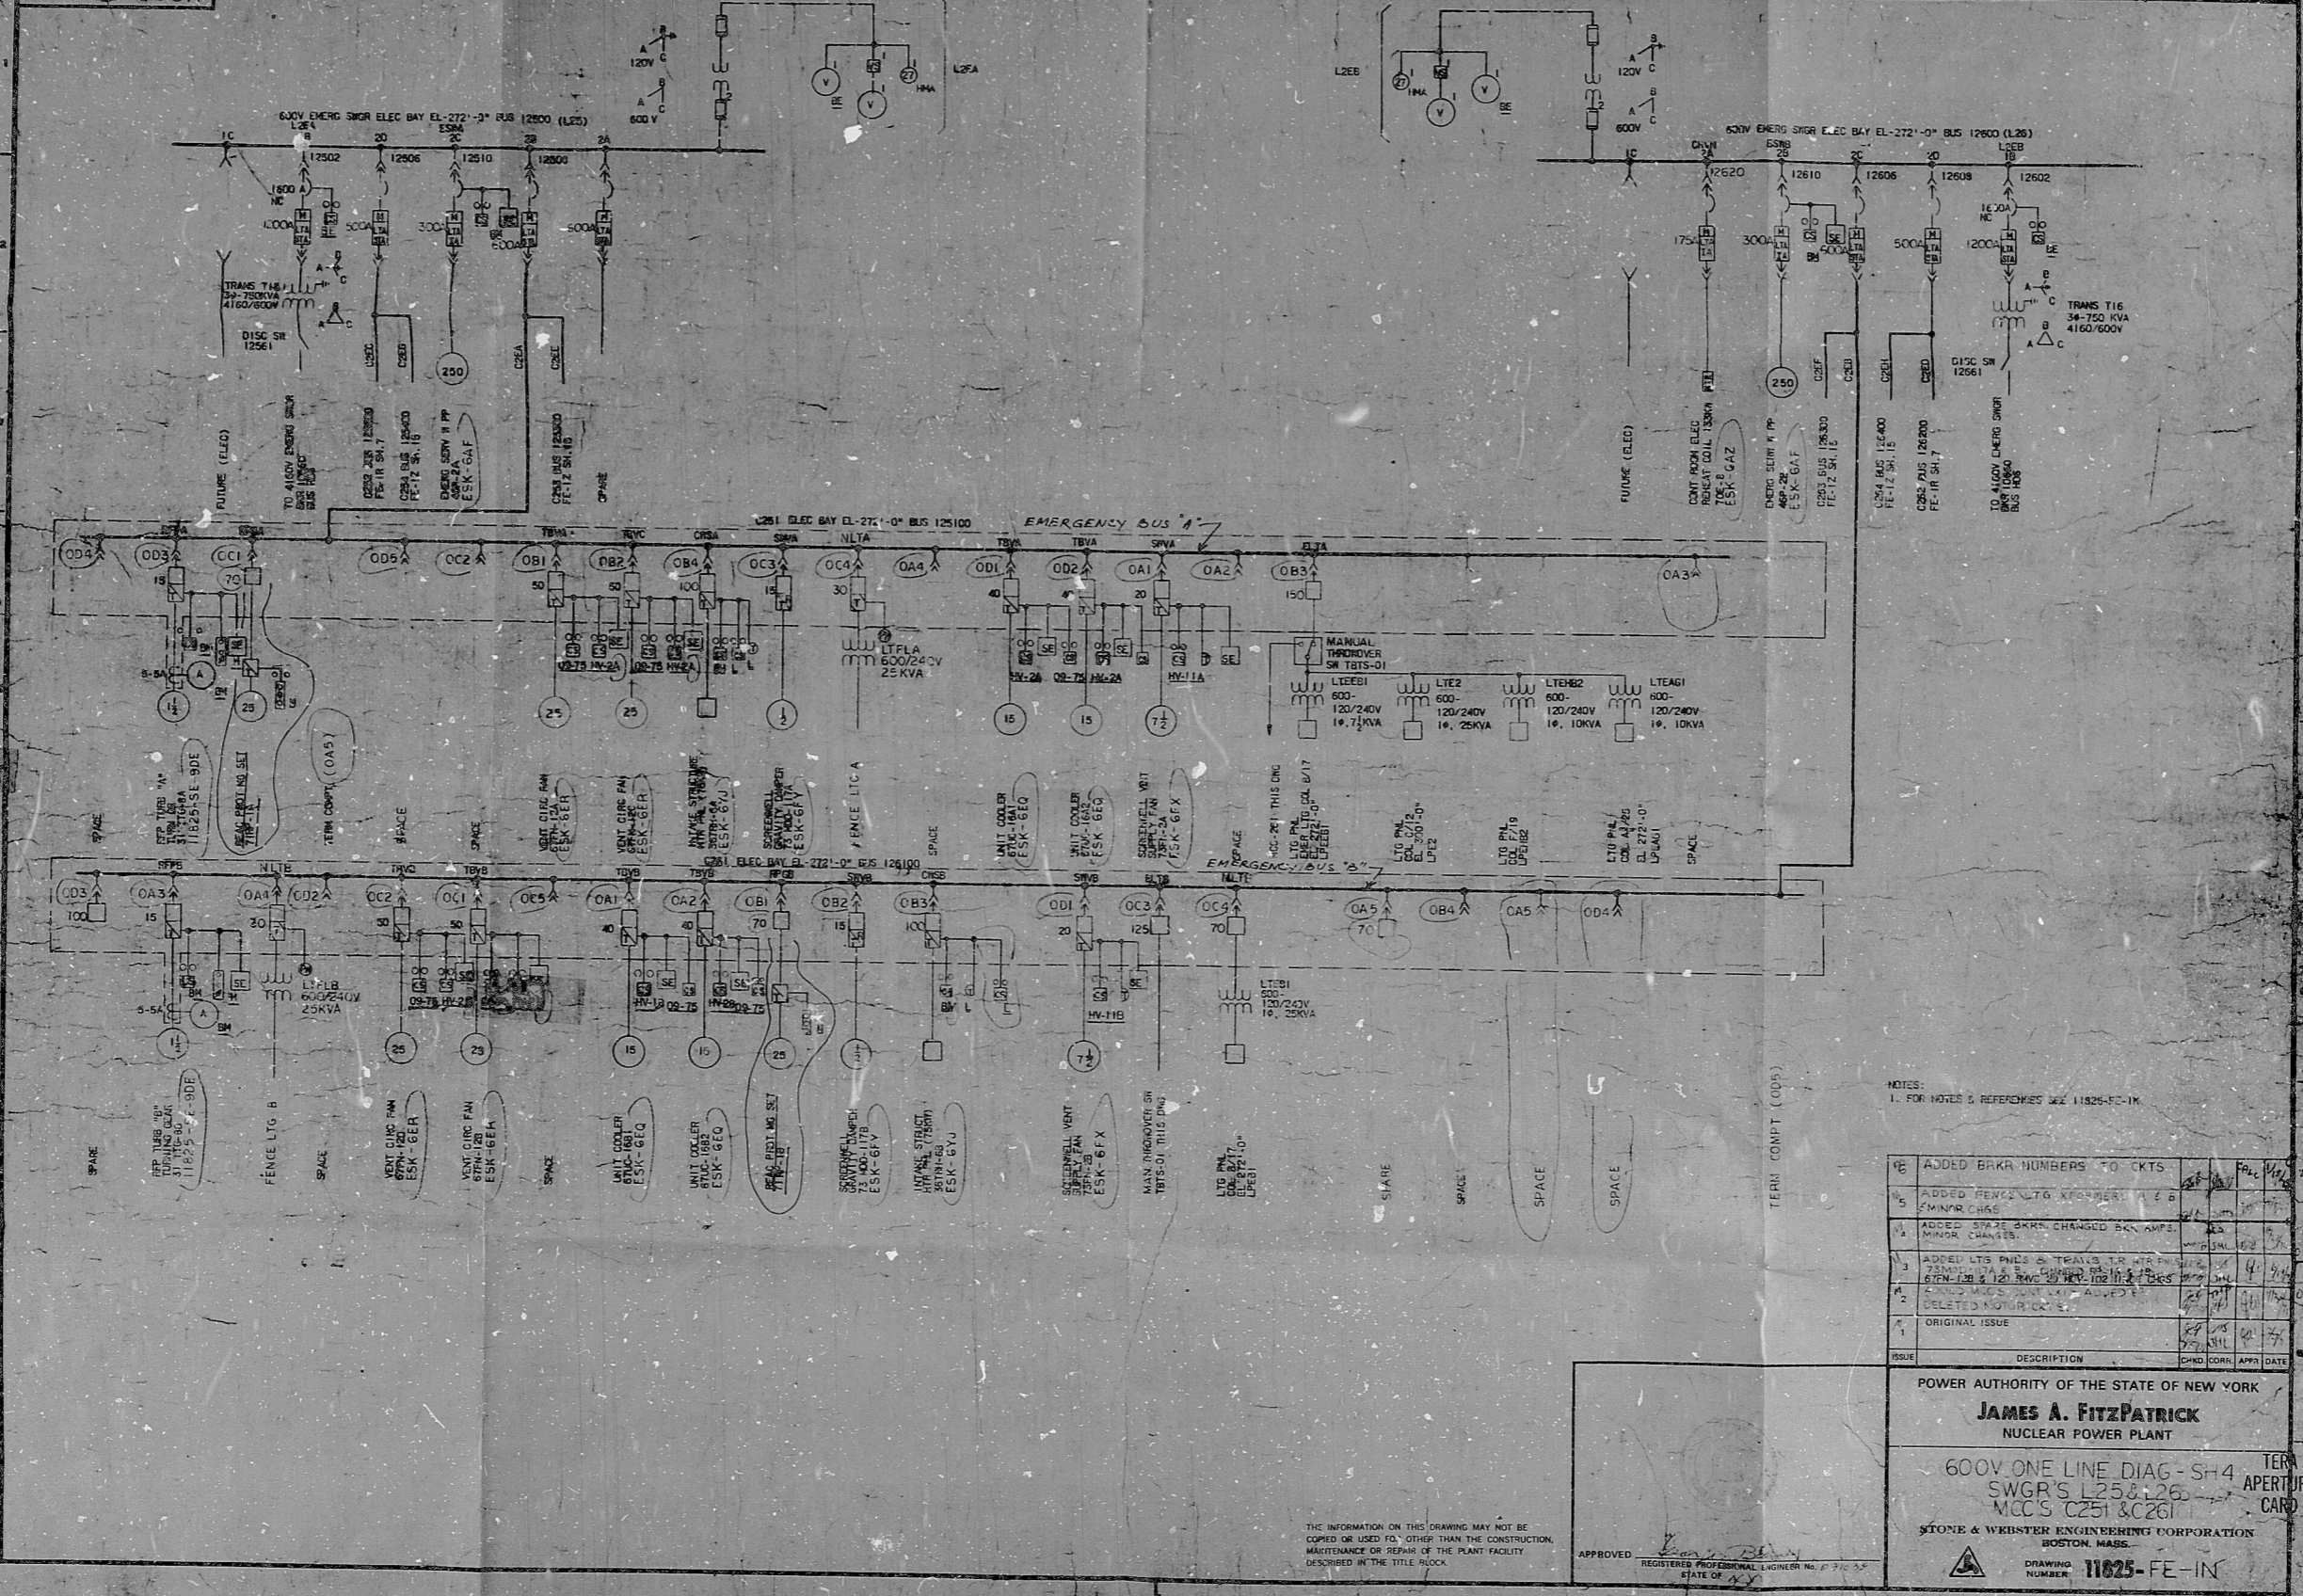

NOTES:
 1. FOR NOTES & REFERENCES SEE 11825-FE-IN

NO.	DESCRIPTION	CHKD	DATE
16	ADDED BRKR NUMBERS TO CKTS		
15	ADDED FENCE LTG. TRANSFORMER T-1 & CHANFR CHAS		
14	ADDED 5742 BRKR CHANGED BRK AMPS MINOR CHANGES		
13	ADDED LTS PHCS & TRAVLS TO APPR 12/1/68		
12	ADDED MISC. JUNK LINES ADDED & DELETED MOTOR CKTS		
11	ORIGINAL ISSUE		

POWER AUTHORITY OF THE STATE OF NEW YORK
JAMES A. FITZPATRICK
 NUCLEAR POWER PLANT
 600V ONE LINE DIAG - SH4
 SWGR'S L25 & L26
 MCC'S C251 & C261
 TEM APERTURE CARD
 STONE & WEBSTER ENGINEERING CORPORATION
 BOSTON, MASS.
 DRAWING NUMBER **11825-FE-IN**
 51109047

THE INFORMATION ON THIS DRAWING MAY NOT BE COPIED OR USED FOR OTHER THAN THE CONSTRUCTION, MAINTENANCE OR REPAIR OF THE PLANT FACILITY DESCRIBED IN THE TITLE BLOCK.

APPROVED
 REGISTERED PROFESSIONAL ENGINEER NO. 6770-3-A
 STATE OF N.Y.

NO.	NO.	NO.	NO.	NO.	NO.	NO.	NO.	NO.	NO.
1	2	3	4	5	6	7	8	9	10

RIDS

8111090471

