
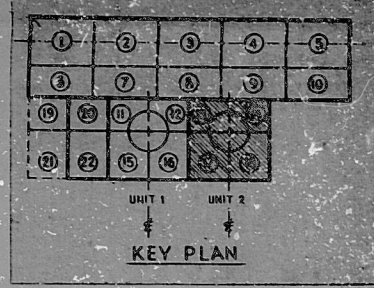


H
G
F
E
D
C
B
A

FOR CONSTRUCTION USE				
ADDED	REVISED	DELETED	DATE	BY
	218603-AT31 G-6	208603-1RS G-6		
		208603-1RS G-6		
# DWG. ONLY				

MATCH LINE FOR CONT. SEE DWG.

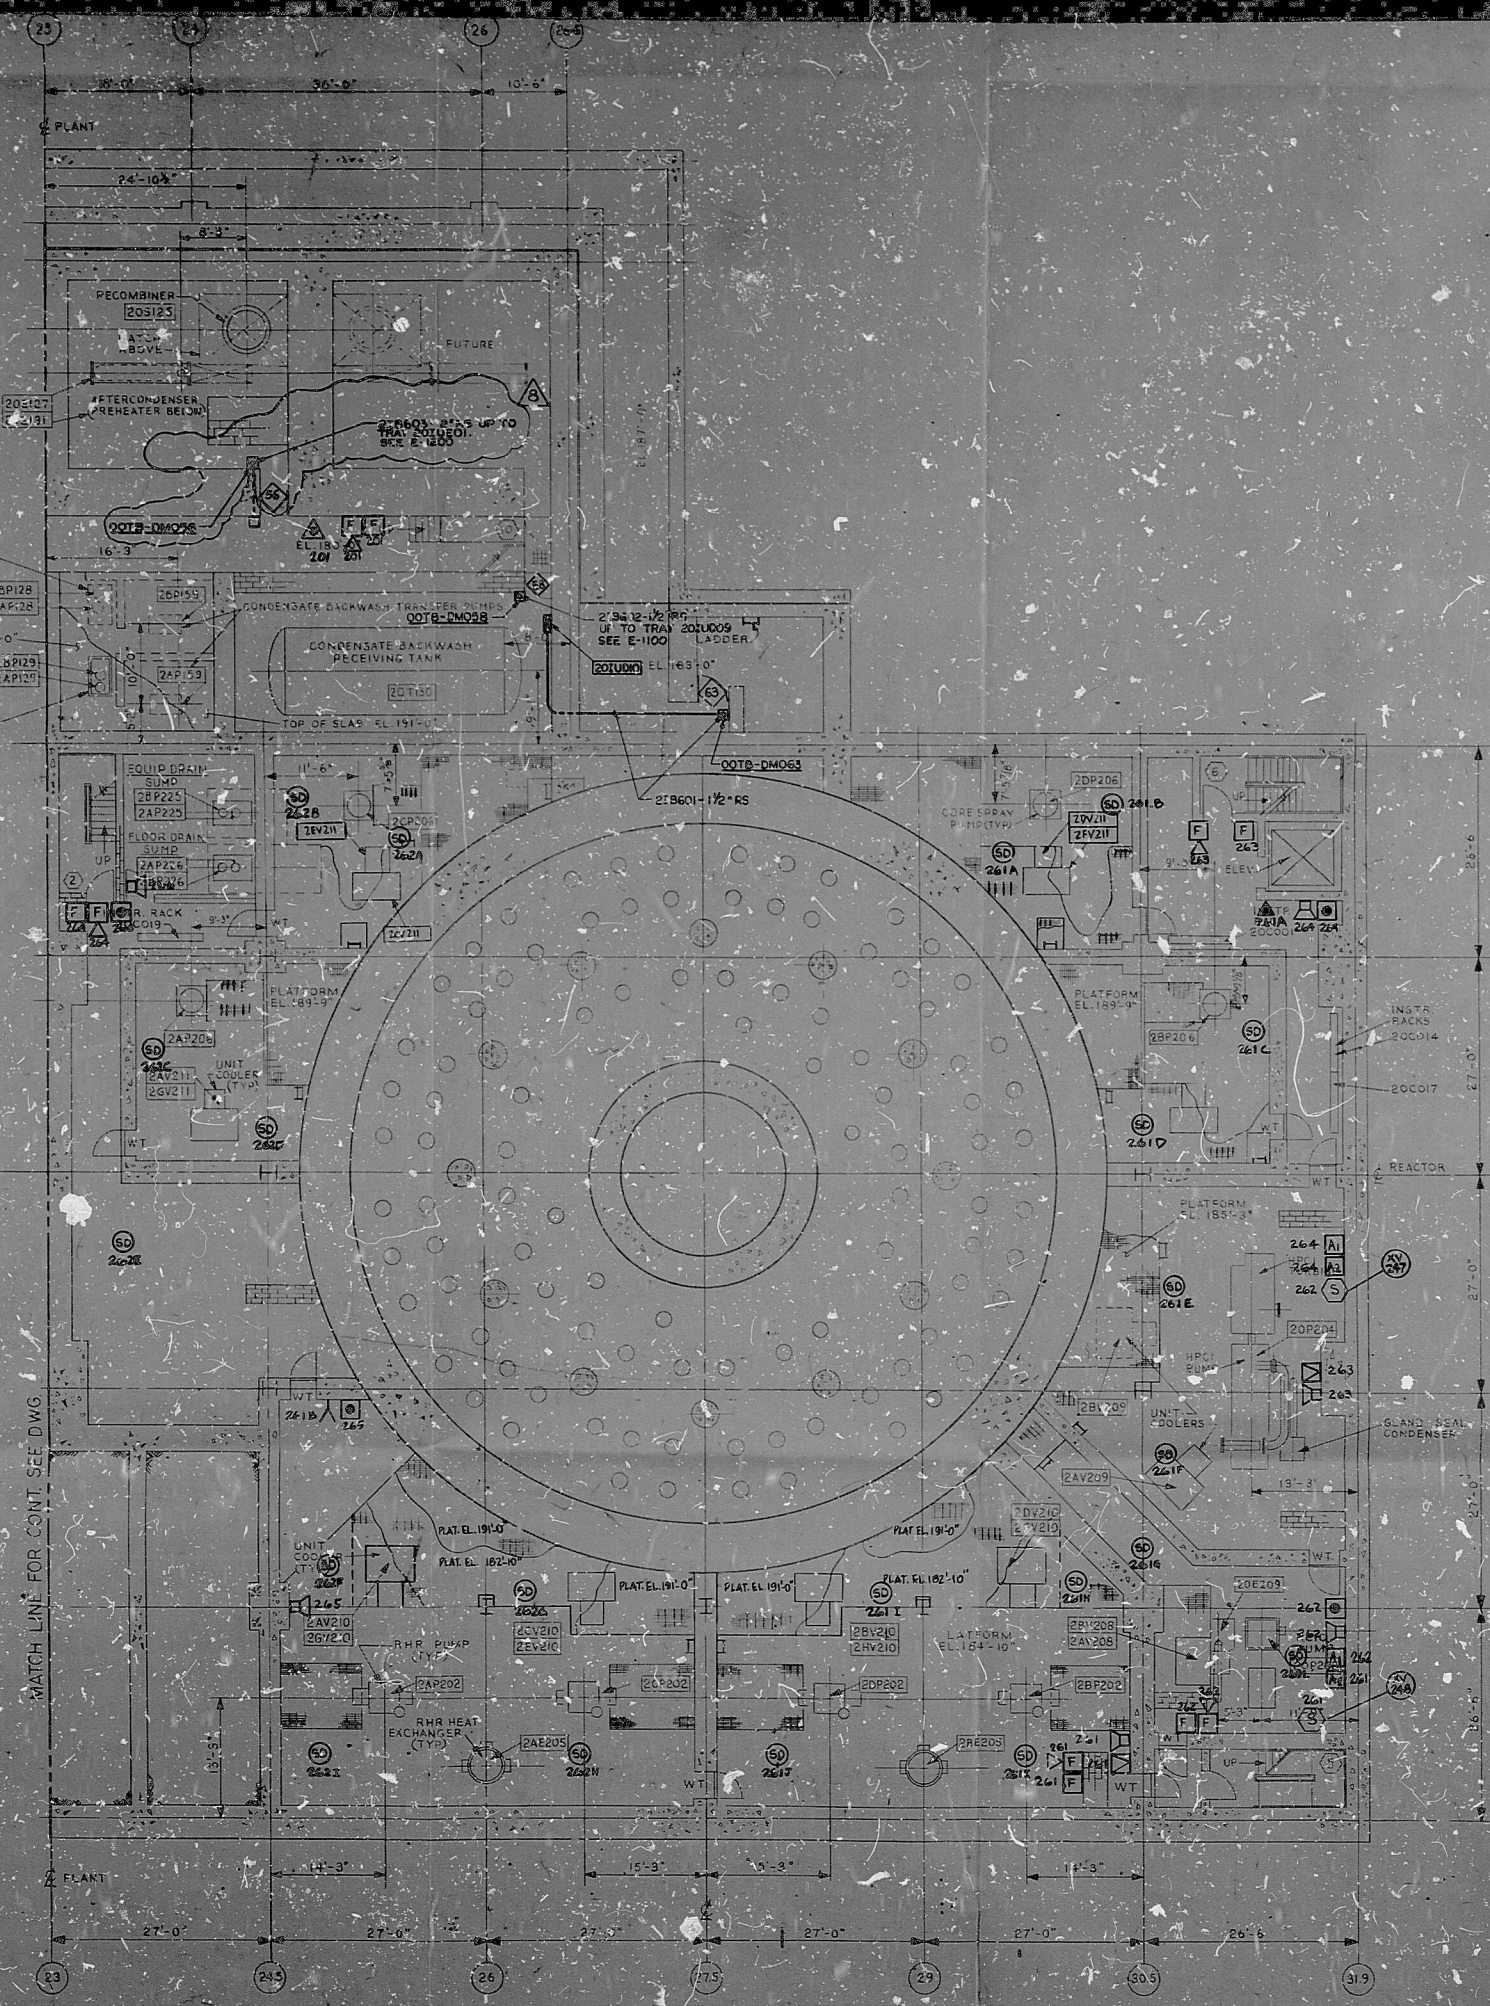

- NOTES
1. FOR FIRE ALARM RACEWAY SYSTEM SEE RISER DIAGRAM DWG. NO. E-1361
 2. FOR PUBLIC ADDRESS RACEWAY SYSTEM SEE RISER DIAGRAM DWG. NO. E-1370
 3. FOR PABX RACEWAY SYSTEM SEE RISER DIAGRAM DWG. NO. E-1370
 4. FOR TYPICAL INSTALLATION OF DOOR MONITOR SEE DWG. E-1407.
 5. $\diamond$ DENOTES "DOOR" MARK NO.

- REFERENCE DRAWINGS
- E-1408 FIRE ALARM SYSTEM - NOTES, SYMBOLS AND DETAILS
 - E-1361 RISER DIAGRAM FIRE ALARM SYSTEM - UNIT 2
 - E-1407 COMMUNICATION - NOTES, SYMBOLS & DETAILS
 - E-1367 RISER DIAGRAM PUBLIC ADDRESS SYSTEM - UNIT 2
 - E-1370 RISER DIAGRAM TELEPHONE SYSTEM (PABX) - UNIT 2

1/2" = 1'-0"	AS COR. FOR 2731E.	1/2" = 1'-0"	1/2" = 1'-0"
1/4" = 1'-0"	MODIFIED FROM NO. 1	1/4" = 1'-0"	1/4" = 1'-0"
1/8" = 1'-0"	NOTES 1 & 2	1/8" = 1'-0"	1/8" = 1'-0"
1/16" = 1'-0"	1/16" = 1'-0"	1/16" = 1'-0"	1/16" = 1'-0"
1/32" = 1'-0"	1/32" = 1'-0"	1/32" = 1'-0"	1/32" = 1'-0"
1/64" = 1'-0"	1/64" = 1'-0"	1/64" = 1'-0"	1/64" = 1'-0"
1/128" = 1'-0"	1/128" = 1'-0"	1/128" = 1'-0"	1/128" = 1'-0"
1/256" = 1'-0"	1/256" = 1'-0"	1/256" = 1'-0"	1/256" = 1'-0"
1/512" = 1'-0"	1/512" = 1'-0"	1/512" = 1'-0"	1/512" = 1'-0"
1/1024" = 1'-0"	1/1024" = 1'-0"	1/1024" = 1'-0"	1/1024" = 1'-0"
1/2048" = 1'-0"	1/2048" = 1'-0"	1/2048" = 1'-0"	1/2048" = 1'-0"
1/4096" = 1'-0"	1/4096" = 1'-0"	1/4096" = 1'-0"	1/4096" = 1'-0"
1/8192" = 1'-0"	1/8192" = 1'-0"	1/8192" = 1'-0"	1/8192" = 1'-0"
1/16384" = 1'-0"	1/16384" = 1'-0"	1/16384" = 1'-0"	1/16384" = 1'-0"
1/32768" = 1'-0"	1/32768" = 1'-0"	1/32768" = 1'-0"	1/32768" = 1'-0"
1/65536" = 1'-0"	1/65536" = 1'-0"	1/65536" = 1'-0"	1/65536" = 1'-0"
1/131072" = 1'-0"	1/131072" = 1'-0"	1/131072" = 1'-0"	1/131072" = 1'-0"
1/262144" = 1'-0"	1/262144" = 1'-0"	1/262144" = 1'-0"	1/262144" = 1'-0"
1/524288" = 1'-0"	1/524288" = 1'-0"	1/524288" = 1'-0"	1/524288" = 1'-0"
1/1048576" = 1'-0"	1/1048576" = 1'-0"	1/1048576" = 1'-0"	1/1048576" = 1'-0"
1/2097152" = 1'-0"	1/2097152" = 1'-0"	1/2097152" = 1'-0"	1/2097152" = 1'-0"
1/4194304" = 1'-0"	1/4194304" = 1'-0"	1/4194304" = 1'-0"	1/4194304" = 1'-0"
1/8388608" = 1'-0"	1/8388608" = 1'-0"	1/8388608" = 1'-0"	1/8388608" = 1'-0"
1/16777216" = 1'-0"	1/16777216" = 1'-0"	1/16777216" = 1'-0"	1/16777216" = 1'-0"
1/33554432" = 1'-0"	1/33554432" = 1'-0"	1/33554432" = 1'-0"	1/33554432" = 1'-0"
1/67108864" = 1'-0"	1/67108864" = 1'-0"	1/67108864" = 1'-0"	1/67108864" = 1'-0"
1/134217728" = 1'-0"	1/134217728" = 1'-0"	1/134217728" = 1'-0"	1/134217728" = 1'-0"
1/268435456" = 1'-0"	1/268435456" = 1'-0"	1/268435456" = 1'-0"	1/268435456" = 1'-0"
1/536870912" = 1'-0"	1/536870912" = 1'-0"	1/536870912" = 1'-0"	1/536870912" = 1'-0"
1/1073741824" = 1'-0"	1/1073741824" = 1'-0"	1/1073741824" = 1'-0"	1/1073741824" = 1'-0"
1/2147483648" = 1'-0"	1/2147483648" = 1'-0"	1/2147483648" = 1'-0"	1/2147483648" = 1'-0"
1/4294967296" = 1'-0"	1/4294967296" = 1'-0"	1/4294967296" = 1'-0"	1/4294967296" = 1'-0"
1/8589934592" = 1'-0"	1/8589934592" = 1'-0"	1/8589934592" = 1'-0"	1/8589934592" = 1'-0"
1/17179869184" = 1'-0"	1/17179869184" = 1'-0"	1/17179869184" = 1'-0"	1/17179869184" = 1'-0"
1/34359738368" = 1'-0"	1/34359738368" = 1'-0"	1/34359738368" = 1'-0"	1/34359738368" = 1'-0"
1/68719476736" = 1'-0"	1/68719476736" = 1'-0"	1/68719476736" = 1'-0"	1/68719476736" = 1'-0"
1/137438953472" = 1'-0"	1/137438953472" = 1'-0"	1/137438953472" = 1'-0"	1/137438953472" = 1'-0"
1/274877906944" = 1'-0"	1/274877906944" = 1'-0"	1/274877906944" = 1'-0"	1/274877906944" = 1'-0"
1/549755813888" = 1'-0"	1/549755813888" = 1'-0"	1/549755813888" = 1'-0"	1/549755813888" = 1'-0"
1/1099511627776" = 1'-0"	1/1099511627776" = 1'-0"	1/1099511627776" = 1'-0"	1/1099511627776" = 1'-0"
1/2199023255552" = 1'-0"	1/2199023255552" = 1'-0"	1/2199023255552" = 1'-0"	1/2199023255552" = 1'-0"
1/4398046511104" = 1'-0"	1/4398046511104" = 1'-0"	1/4398046511104" = 1'-0"	1/4398046511104" = 1'-0"
1/8796093022208" = 1'-0"	1/8796093022208" = 1'-0"	1/8796093022208" = 1'-0"	1/8796093022208" = 1'-0"
1/17592186044416" = 1'-0"	1/17592186044416" = 1'-0"	1/17592186044416" = 1'-0"	1/17592186044416" = 1'-0"
1/35184372088832" = 1'-0"	1/35184372088832" = 1'-0"	1/35184372088832" = 1'-0"	1/35184372088832" = 1'-0"
1/70368744177664" = 1'-0"	1/70368744177664" = 1'-0"	1/70368744177664" = 1'-0"	1/70368744177664" = 1'-0"
1/140737488355328" = 1'-0"	1/140737488355328" = 1'-0"	1/140737488355328" = 1'-0"	1/140737488355328" = 1'-0"
1/281474976710656" = 1'-0"	1/281474976710656" = 1'-0"	1/281474976710656" = 1'-0"	1/281474976710656" = 1'-0"
1/562949953421312" = 1'-0"	1/562949953421312" = 1'-0"	1/562949953421312" = 1'-0"	1/562949953421312" = 1'-0"
1/1125899906842624" = 1'-0"	1/1125899906842624" = 1'-0"	1/1125899906842624" = 1'-0"	1/1125899906842624" = 1'-0"
1/2251799813685248" = 1'-0"	1/2251799813685248" = 1'-0"	1/2251799813685248" = 1'-0"	1/2251799813685248" = 1'-0"
1/4503599627370496" = 1'-0"	1/4503599627370496" = 1'-0"	1/4503599627370496" = 1'-0"	1/4503599627370496" = 1'-0"
1/9007199254740992" = 1'-0"	1/9007199254740992" = 1'-0"	1/9007199254740992" = 1'-0"	1/9007199254740992" = 1'-0"
1/18014398509481984" = 1'-0"	1/18014398509481984" = 1'-0"	1/18014398509481984" = 1'-0"	1/18014398509481984" = 1'-0"
1/36028797018963968" = 1'-0"	1/36028797018963968" = 1'-0"	1/36028797018963968" = 1'-0"	1/36028797018963968" = 1'-0"
1/72057594037927936" = 1'-0"	1/72057594037927936" = 1'-0"	1/72057594037927936" = 1'-0"	1/72057594037927936" = 1'-0"
1/144115188075855872" = 1'-0"	1/144115188075855872" = 1'-0"	1/144115188075855872" = 1'-0"	1/144115188075855872" = 1'-0"
1/288230376151711744" = 1'-0"	1/288230376151711744" = 1'-0"	1/288230376151711744" = 1'-0"	1/288230376151711744" = 1'-0"
1/576460752303423488" = 1'-0"	1/576460752303423488" = 1'-0"	1/576460752303423488" = 1'-0"	1/576460752303423488" = 1'-0"
1/1152921504606846976" = 1'-0"	1/1152921504606846976" = 1'-0"	1/1152921504606846976" = 1'-0"	1/1152921504606846976" = 1'-0"
1/2305843009213693952" = 1'-0"	1/2305843009213693952" = 1'-0"	1/2305843009213693952" = 1'-0"	1/2305843009213693952" = 1'-0"
1/4611686018427387904" = 1'-0"	1/4611686018427387904" = 1'-0"	1/4611686018427387904" = 1'-0"	1/4611686018427387904" = 1'-0"
1/9223372036854775808" = 1'-0"	1/9223372036854775808" = 1'-0"	1/9223372036854775808" = 1'-0"	1/9223372036854775808" = 1'-0"
1/18446744073709551616" = 1'-0"	1/18446744073709551616" = 1'-0"	1/18446744073709551616" = 1'-0"	1/18446744073709551616" = 1'-0"
1/36893488147419103232" = 1'-0"	1/36893488147419103232" = 1'-0"	1/36893488147419103232" = 1'-0"	1/36893488147419103232" = 1'-0"
1/73786976294838206464" = 1'-0"	1/73786976294838206464" = 1'-0"	1/73786976294838206464" = 1'-0"	1/73786976294838206464" = 1'-0"
1/147573952589676412928" = 1'-0"	1/147573952589676412928" = 1'-0"	1/147573952589676412928" = 1'-0"	1/147573952589676412928" = 1'-0"
1/295147905179352825856" = 1'-0"	1/295147905179352825856" = 1'-0"	1/295147905179352825856" = 1'-0"	1/295147905179352825856" = 1'-0"
1/5902958103587056517056" = 1'-0"	1/5902958103587056517056" = 1'-0"	1/5902958103587056517056" = 1'-0"	1/5902958103587056517056" = 1'-0"
1/11805916207174113034112" = 1'-0"	1/11805916207174113034112" = 1'-0"	1/11805916207174113034112" = 1'-0"	1/11805916207174113034112" = 1'-0"
1/23611832414348226068224" = 1'-0"	1/23611832414348226068224" = 1'-0"	1/23611832414348226068224" = 1'-0"	1/23611832414348226068224" = 1'-0"
1/47223664828696452136448" = 1'-0"	1/47223664828696452136448" = 1'-0"	1/47223664828696452136448" = 1'-0"	1/47223664828696452136448" = 1'-0"
1/94447329657392904272896" = 1'-0"	1/94447329657392904272896" = 1'-0"	1/94447329657392904272896" = 1'-0"	1/94447329657392904272896" = 1'-0"
1/188894659314785808545792" = 1'-0"	1/188894659314785808545792" = 1'-0"	1/188894659314785808545792" = 1'-0"	1/188894659314785808545792" = 1'-0"
1/377789318629571617091584" = 1'-0"	1/377789318629571617091584" = 1'-0"	1/377789318629571617091584" = 1'-0"	1/377789318629571617091584" = 1'-0"
1/755578637259143234183168" = 1'-0"	1/755578637259143234183168" = 1'-0"	1/755578637259143234183168" = 1'-0"	1/755578637259143234183168" = 1'-0"
1/1511157274518286468366336" = 1'-0"	1/1511157274518286468366336" = 1'-0"	1/1511157274518286468366336" = 1'-0"	1/1511157274518286468366336" = 1'-0"
1/3022314549036572936732672" = 1'-0"	1/3022314549036572936732672" = 1'-0"	1/3022314549036572936732672" = 1'-0"	1/3022314549036572936732672" = 1'-0"
1/6044629098073145873465344" = 1'-0"	1/6044629098073145873465344" = 1'-0"	1/6044629098073145873465344" = 1'-0"	1/6044629098073145873465344" = 1'-0"
1/12089258196146291746930688" = 1'-0"	1/12089258196146291746930688" = 1'-0"	1/12089258196146291746930688" = 1'-0"	1/12089258196146291746930688" = 1'-0"
1/24178516392292583493861376" = 1'-0"	1/24178516392292583493861376" = 1'-0"	1/24178516392292583493861376" = 1'-0"	1/24178516392292583493861376" = 1'-0"
1/48357032784585166987722752" = 1'-0"	1/48357032784585166987722752" = 1'-0"	1/48357032784585166987722752" = 1'-0"	1/48357032784585166987722752" = 1'-0"
1/96714065569170333975445504" = 1'-0"	1/96714065569170333975445504" = 1'-0"	1/96714065569170333975445504" = 1'-0"	1/96714065569170333975445504" = 1'-0"
1/193428131138340667950891008" = 1'-0"	1/193428131138340667950891008" = 1'-0"	1/193428131138340667950891008" = 1'-0"	1/193428131138340667950891008" = 1'-0"
1/386856262276681335901782016" = 1'-0"	1/386856262276681335901782016" = 1'-0"	1/386856262276681335901782016" = 1'-0"	1/386856262276681335901782016" = 1'-0"
1/773712524553362671803564032" = 1'-0"	1/773712524553362671803564032" = 1'-0"	1/773712524553362671803564032" = 1'-0"	1/773712524553362671803564032" = 1'-0"
1/1547425049106725343607128064" = 1'-0"	1/1547425049106725343607128064" = 1'-0"	1/1547425049106725343607128064" = 1'-0"	1/1547425049106725343607128064" = 1'-0"
1/3094850098213450687214256128" = 1'-0"	1/3094850098213450687214256128" = 1'-0"	1/3094850098213450687214256128" = 1'-0"	1/3094850098213450687214256128" = 1'-0"
1/6189700196426901374428512256" = 1'-0"	1/6189700196426901374428512256" = 1'-0"	1/6189700196426901374428512256" = 1'-0"	1/6189700196426901374428512256" = 1'-0"
1/12379400392853802748857024512" = 1'-0"	1/12379400392853802748857024512" = 1'-0"	1/12379400392853802748857024512" = 1'-0"	1/12379400392853802748857024512" = 1'-0"
1/24758800785707605497714049024" = 1'-0"	1/24758800785707605497714049024" = 1'-0"	1/24758800785707605497714049024" = 1'-0"	1/24758800785707605497714049024" = 1'-0"
1/49517601571415210995428098048" = 1'-0"	1/49517601571415210995428098048" = 1'-0"	1/49517601571415210995428098048" = 1'-0"	1/49517601571415210995428098048" = 1'-0"
1/99035203142830421990856196096" = 1'-0"	1/99035203142830421990856196096" = 1'-0"	1/99035203142830421990856196096" = 1'-0"	1/99035203142830421990856196096" = 1'-0"
1/198070406285660843981712392192" = 1'-0"	1/198070406285660843981712392192" = 1'-0"	1/198070406285660843981712392192" = 1'-0"	1/198070406285660843981712392192" = 1'-0"
1/396140812571321687963424784384" = 1'-0"	1/396140812571321687963424784384" = 1'-0"	1/396140812571321687963424784384" = 1'-0"	1/396140812571321687963424784384" = 1'-0"
1/792281625142643375926849568768" = 1'-0"	1/792281625142643375926849568768" = 1'-0"	1/792281625142643375926849568768" = 1'-0"	1/792281625142643375926849568768" = 1'-0"
1/1584563250285286751853699137536" = 1'-0"	1/1584563250285286751853699137536" = 1'-0"	1/1584563250285286751853699137536" = 1'-0"	1/1584563250285286751853699137536" = 1'-0"
1/3169126500570573503707398275072" = 1'-0"	1/3169126500570573503707398275072" = 1'-0"	1/3169126500570573503707398275072" = 1'-0"	1/3169126500570573503707398275072" = 1'-0"
1/6338253001141147007414796550144" = 1'-0"	1/6338253001141147007414796550144" = 1'-0"	1/6338253001141147007414796550144" = 1'-0"	1/6338253001141147007414796550144" = 1'-0"
1/12676506002282294014829593100288" = 1'-0"	1/12676506002282294014829593100288" = 1'-0"	1/12676506002282294014829593100288" = 1'-0"	1/12676506002282294014829593100288" = 1'-0"
1/25353012004564588029659186200576" = 1'-0"	1/25353012004564588029659186200576" = 1'-0"	1/25353012004564588029659186200576" = 1'-0"	1/25353012004564588029659186200576" = 1'-0"
1/50706024009129176059318372401152" = 1'-0"	1/50706024009129176059318372401152" = 1'-0"	1/50706024009129176059318372401152" = 1'-0"	1/50706024009129176059318372401152" = 1'-0"

PDR RIDS

8405240556

